
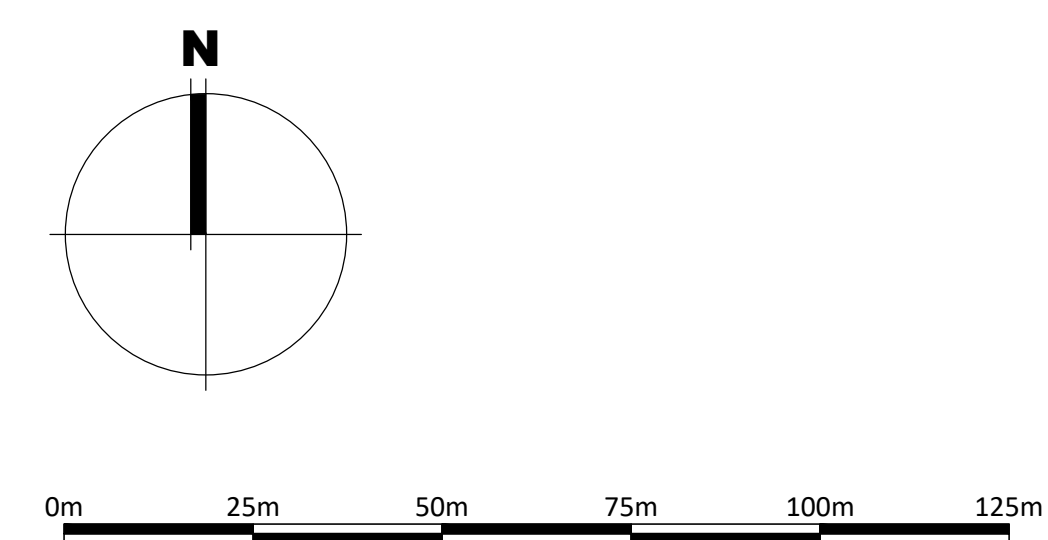


Proposed Residential Development At Kilbride, Arklow, Co. Wicklow
EXISTING SITE PLAN - 1:1000 - SHEET 1 OF 2

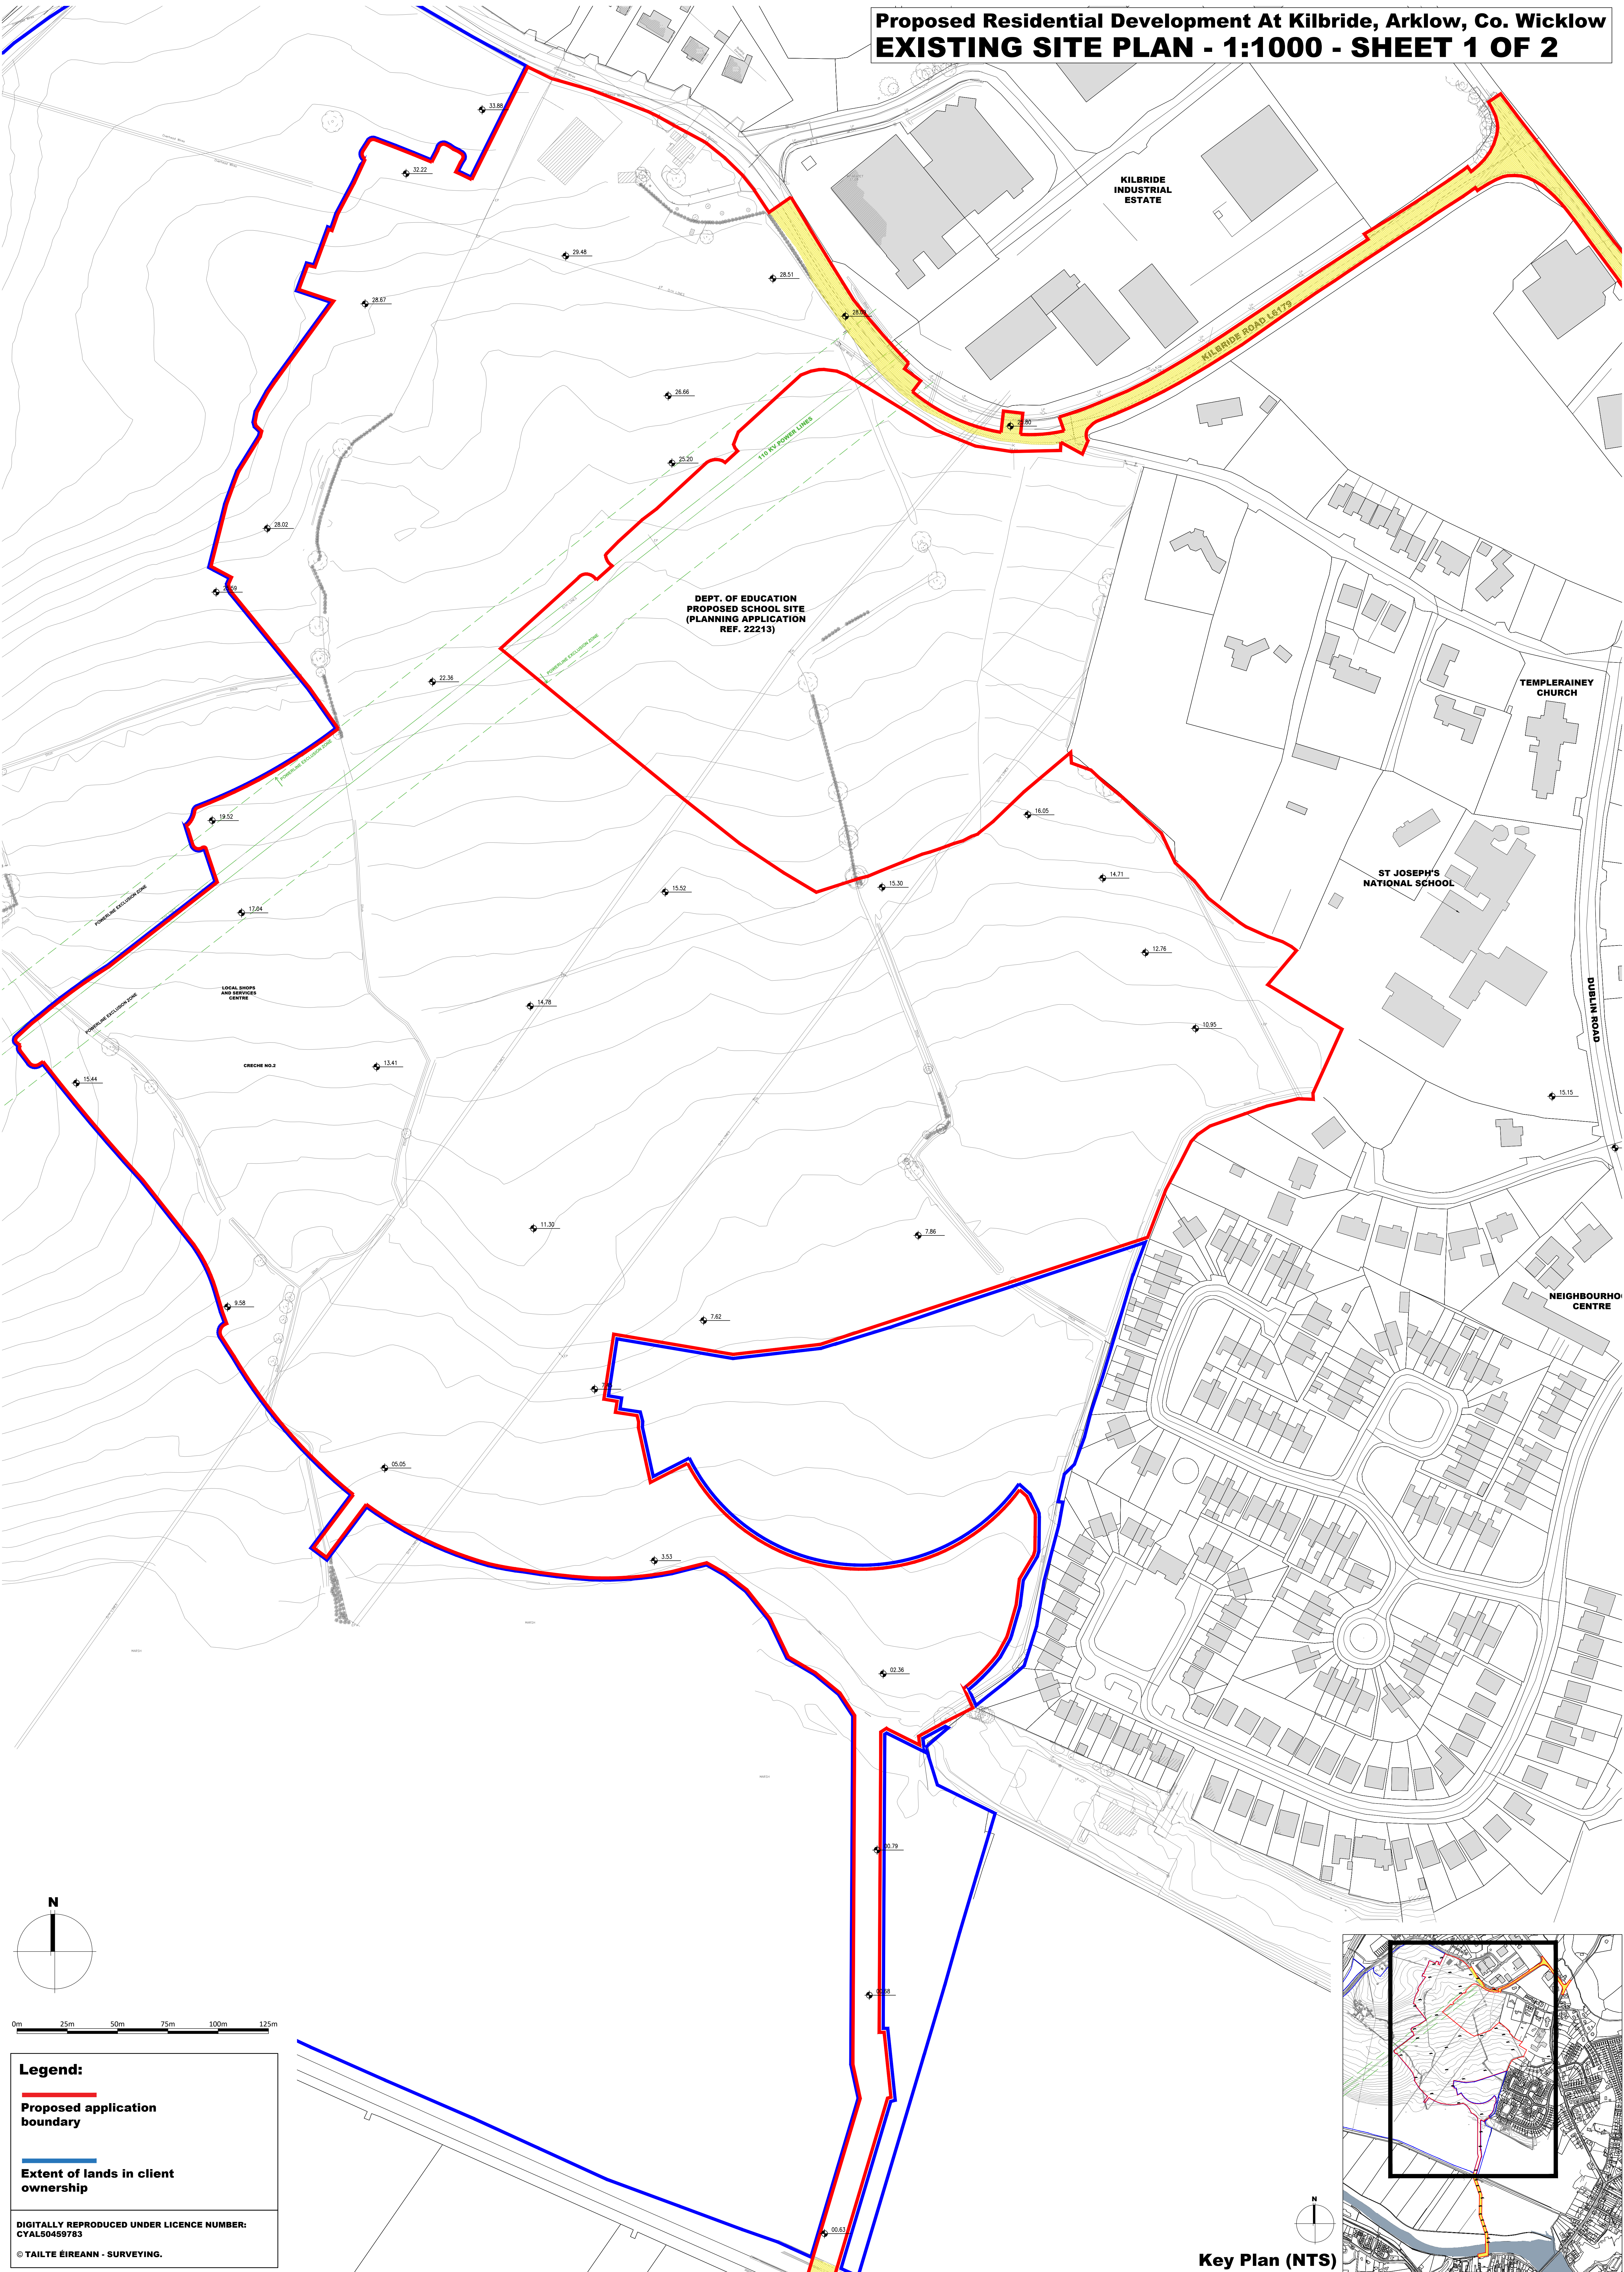

Legend:

Proposed application boundary


Extent of lands in client ownership

DIGITALLY REPRODUCED UNDER LICENCE NUMBER: CYAL50459783

© TAILTE ÉIREANN - SURVEYING.

Notes:	Issue Status	No.	Date	Revision	Initials
1. Copyright Reserved	Progress	01	13/05/24	Planning Issue	RT
2. Work to signed dimensions only. Do not scale drawing.	Planning Application				
3. The contractor is responsible for checking all levels and dimensions on site and shall refer all discrepancies to the Architect.	Price Cert				
4. Where appropriate, for details of c.s. structure, or mechanical and electrical details, see Engineers drawings.	Disability Cert				
5. Proprietary items shall be fixed in strict accordance with manufacturers instructions.	Transfer				
6. Scope of preliminary items shall be checked with the designer.	Construction				
7. The contractor shall be responsible for the coordination of structure, finishes and services.	As-Built				
	Information Only				

Key Plan (NTS)

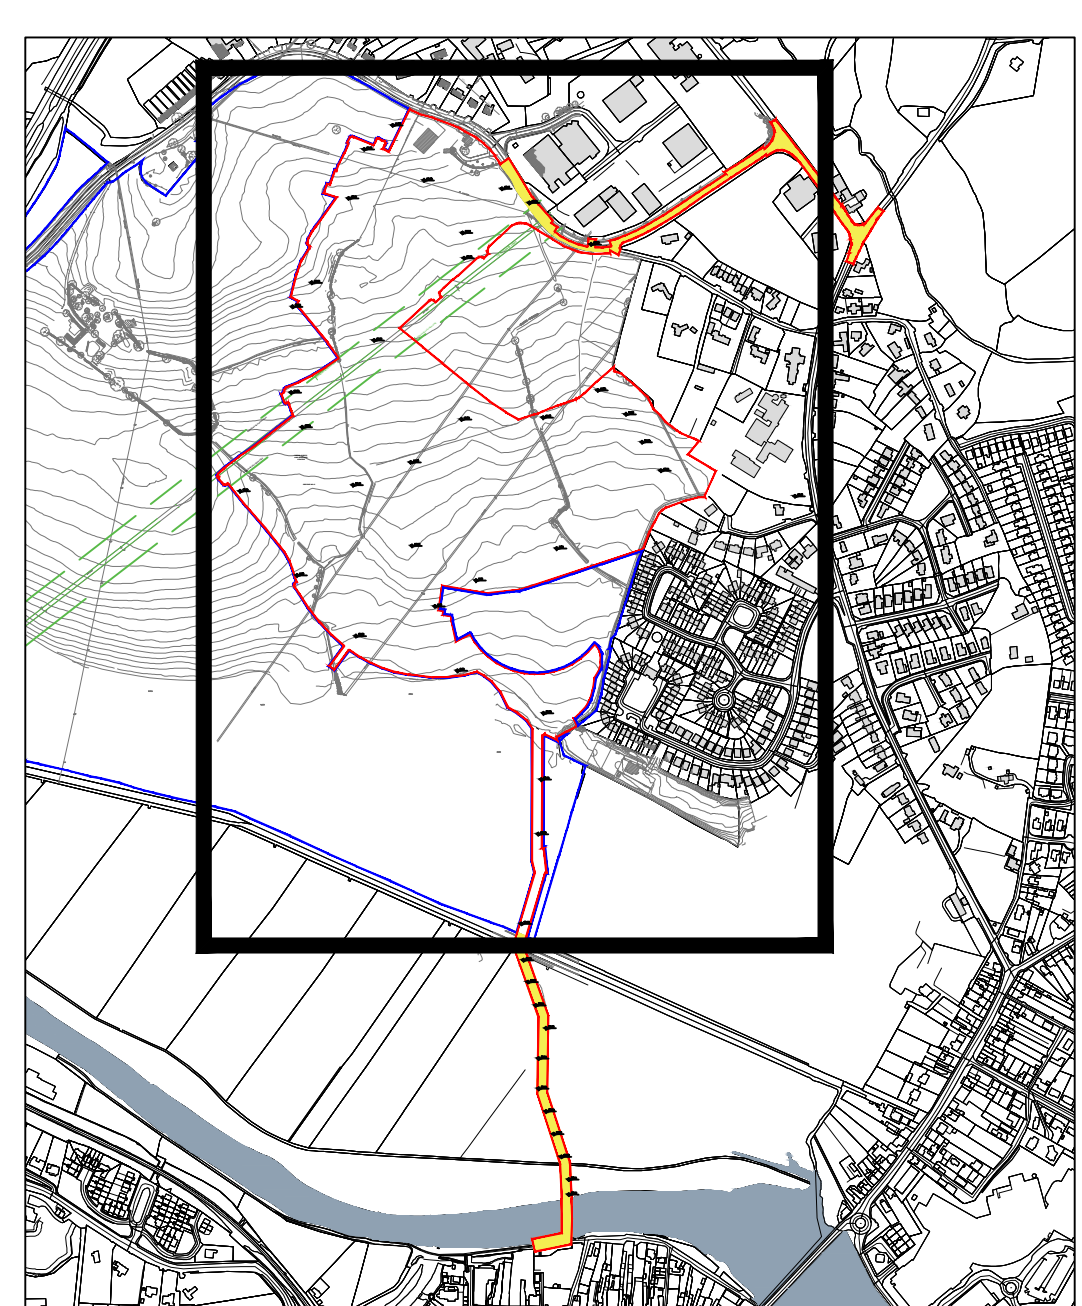

Mixed Use Residential & Commercial Development at Kilbride, Arklow, Co. Wicklow

Drawing No: 6191-PP-050

Scale: 1:1000@A0

Rev: 01

Drawn: RT

Date: 13/05/25

bkd architects
BURRE-KENNEDY DOYLE