



Proposed Residential Development At Kilbride, Arklow, Co. Wicklow
PHASE 1 PROPOSED TAKING IN CHARGE PLAN

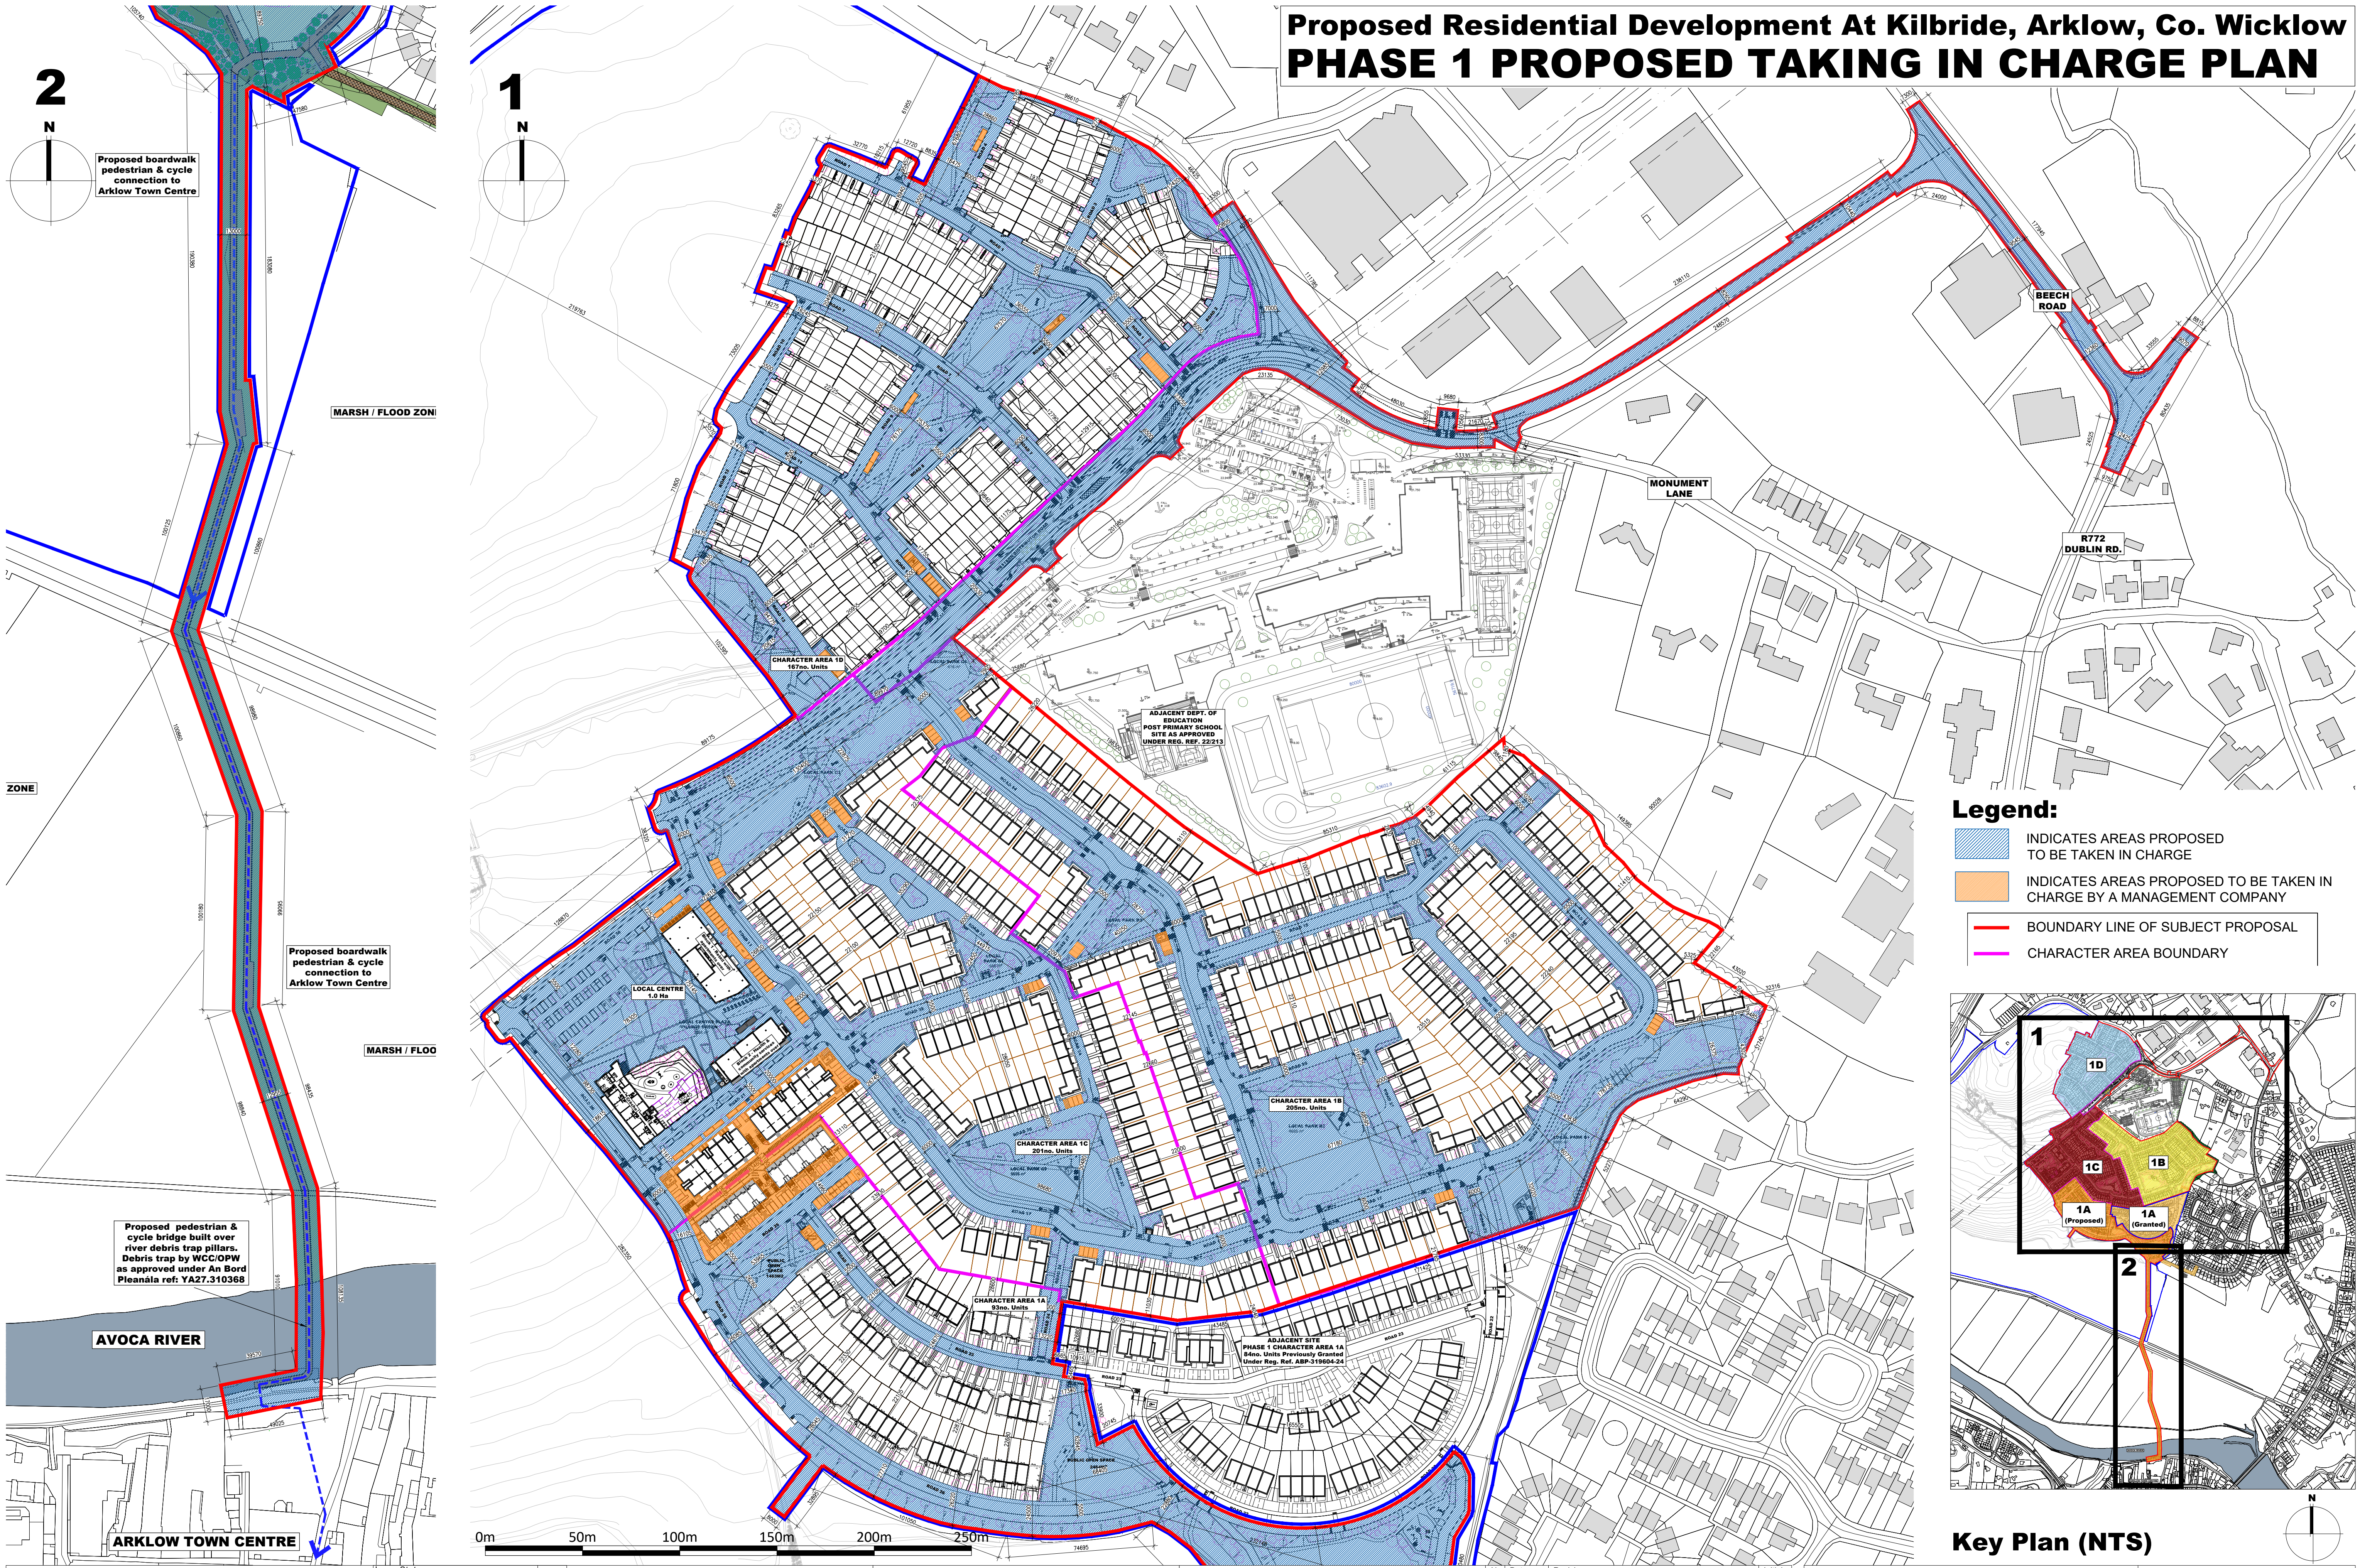

- Legend:**
- INDICATES AREAS PROPOSED TO BE TAKEN IN CHARGE
 - INDICATES AREAS PROPOSED TO BE TAKEN IN CHARGE BY A MANAGEMENT COMPANY
 - BOUNDARY LINE OF SUBJECT PROPOSAL
 - CHARACTER AREA BOUNDARY

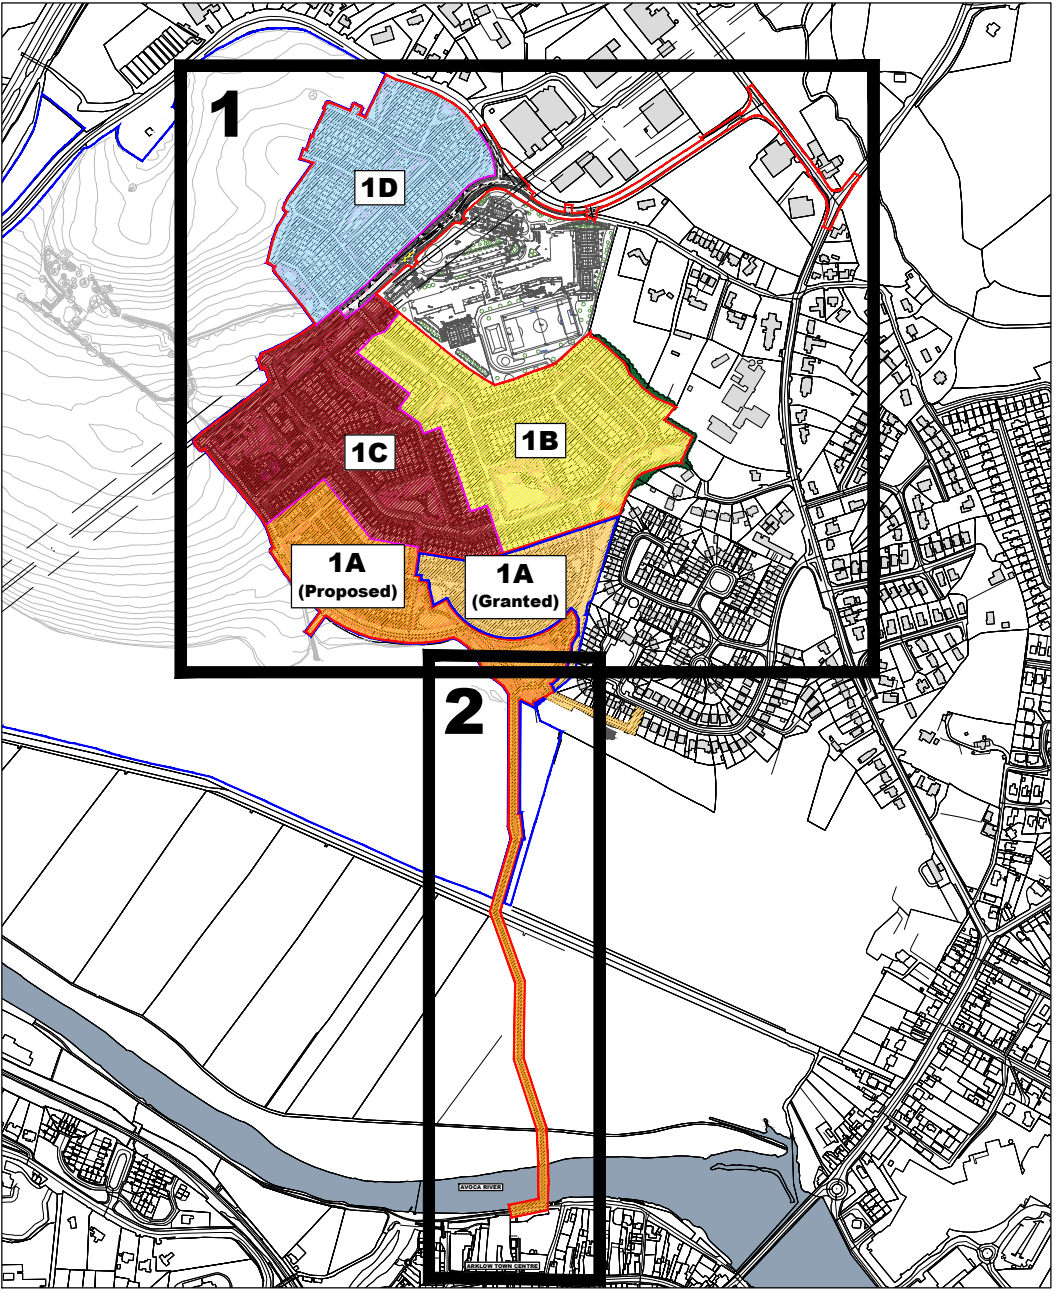

Key Plan (NTS)

- Notes
1. Copyright Reserved
 2. Work to figured dimensions only. Do not scale drawing
 3. The contractor is responsible for checking all levels and dimensions on site and shall refer all discrepancies to the Architect
 4. Where appropriate, for details of r.c. structure, or mechanical and electrical details, see Engineers drawings
 5. Proprietary items shall be fixed in strict accordance with manufacturers instructions.
 6. Sizes of proprietary items shall be checked with manufacturer.
 7. The contractor shall be responsible for the coordination of structure, finishes and services.

- Issue Status
- | | |
|------------------|----------------------|
| Progress | Planning Application |
| Fire Cert | |
| Disability Cert | |
| Tender | |
| Construction | |
| As Built | |
| Information Only | |

No.	Date	Revision	Initials
01	16/05/25	Planning Issue	ED

Project	Mixed Use Residential & Commercial Development at Kilbride, Arklow, Co. Wicklow
Drawing Title	PHASE 1 - PROPOSED TAKING IN CHARGE PLAN
Drawing No	6191-PP-109
Scale	1:1500@A1
Rev	01
Drawn	ED
Date	16/05/25

6-7 HARDOULT TERRACE, DUBLIN 2, IRELAND
t +353-1-618 2400 f +353-1-676 7396
e architecture@bkd.ie
www.bkd.ie

bkdarchitects
BURKE-KENNEDY DOYLE