


01 Character Area 1B Contiguous Street Elevation - ROAD 14 WEST




02 Character Area 1B Contiguous Street Elevation - ROAD 14 WEST



04 Character Area 1B Contiguous Street Elevation - ROAD 14 EAST

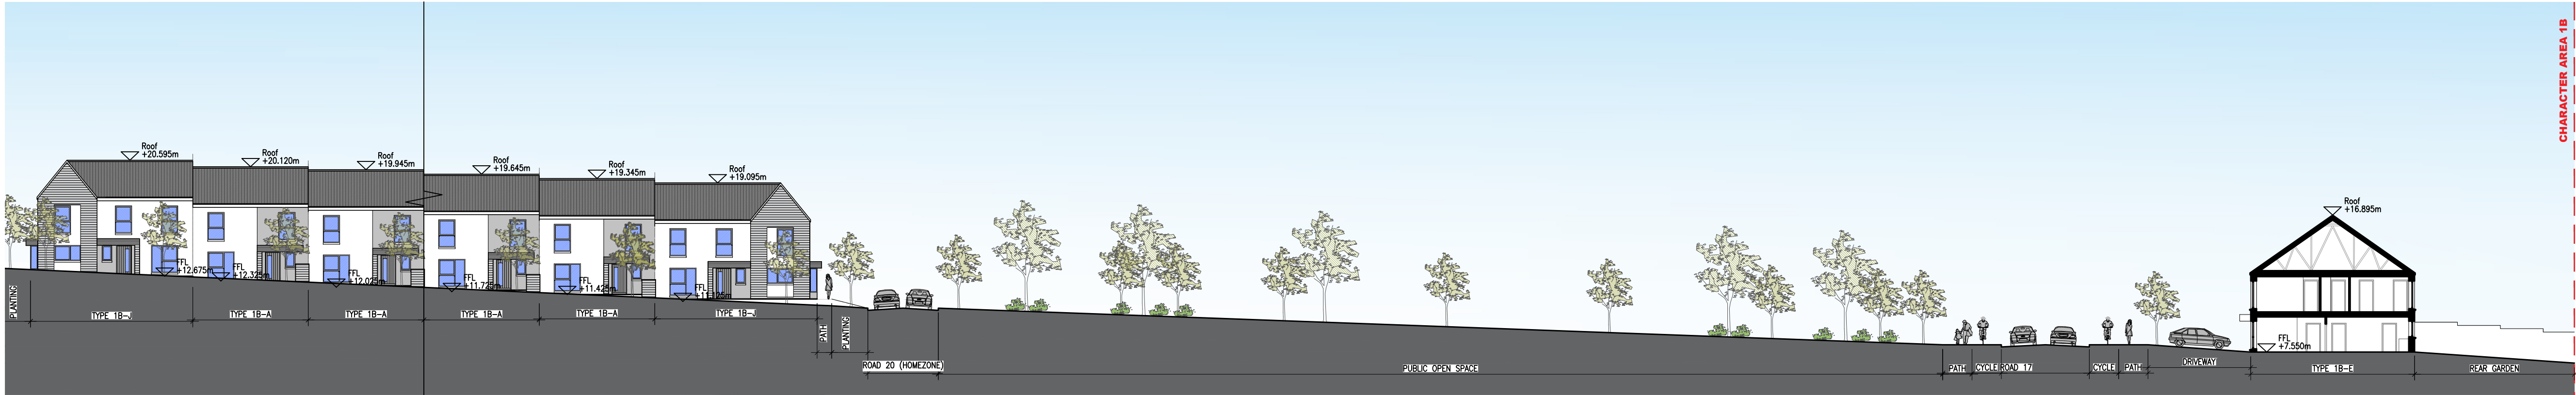

05 Character Area 1B Contiguous Street Elevation - ROAD 14 EAST

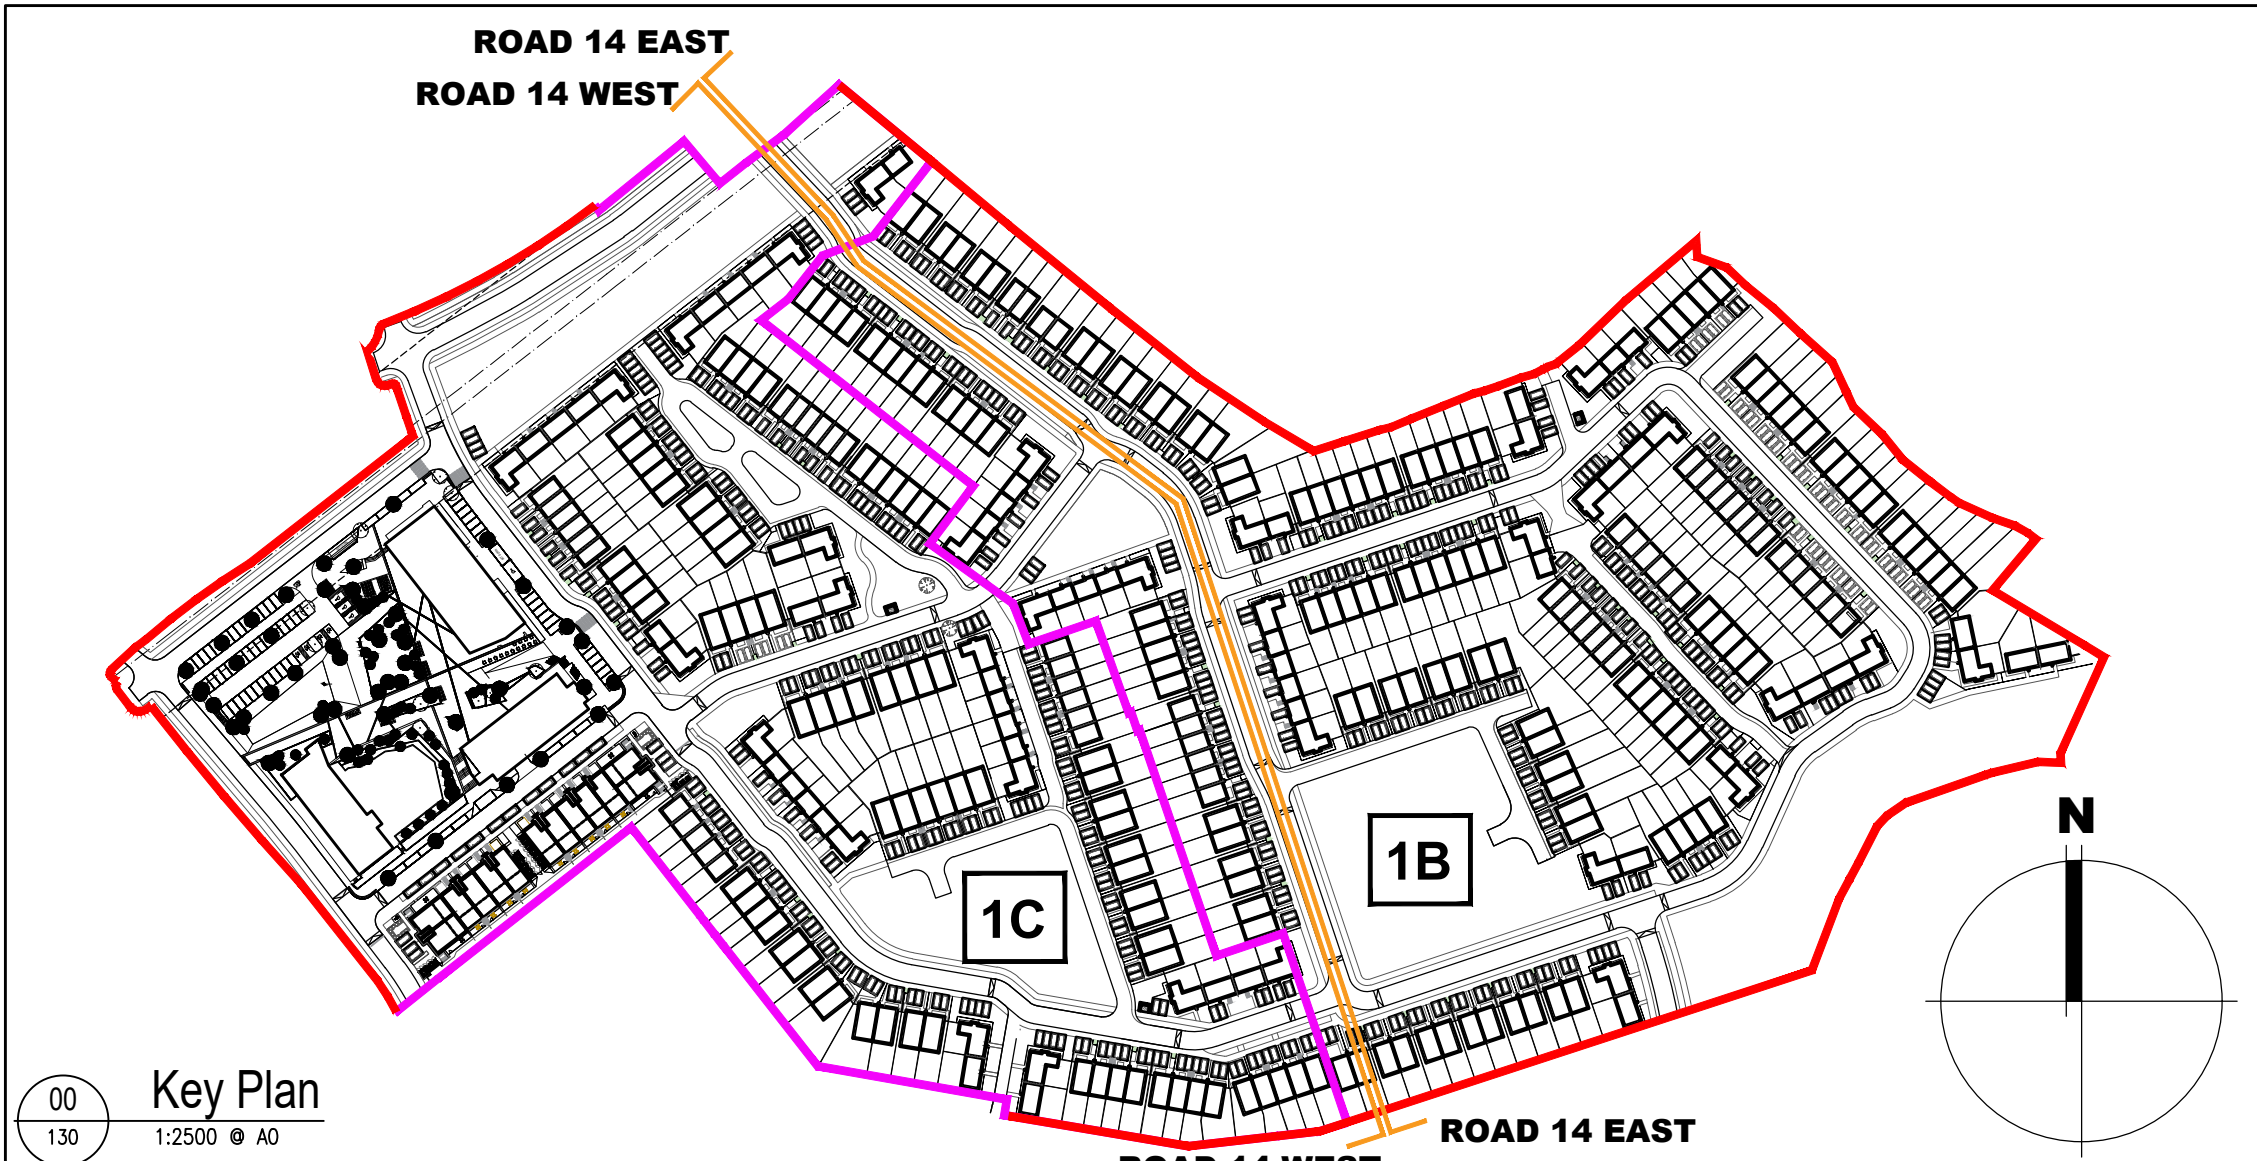

Notes		Issue Status		Project		Drawing Title		Drawing No.		Scale		Rev.		Date		bkd architects	
1. Copyright Reserved		Progress		Mixed Use Residential & Commercial Development		at Kilbride, Arklow, Co. Wicklow		6191-PP-130		1:250, 1:500@AC		05		15/05/25		BARRY-KENNEDY DOYLE	
2. Work to be signed dimension only. Do not scale drawing.		Planning Application		Drawn by: PM		Checked by: PM		Date: 15/05/25		Scale: 1:250, 1:500@AC		Rev: 05		Date: 15/05/25		bkd architects	
3. The contractor is responsible for checking all levels and dimensions on site and shall refer all discrepancies to the Architect.		Fire Cert		Drawn by: PM		Checked by: PM		Date: 15/05/25		Scale: 1:250, 1:500@AC		Rev: 05		Date: 15/05/25		bkd architects	
4. Where appropriate, for details of i.e. structure, or mechanical and electrical details, see Engineers drawing.		Disability Cert		Drawn by: PM		Checked by: PM		Date: 15/05/25		Scale: 1:250, 1:500@AC		Rev: 05		Date: 15/05/25		bkd architects	
5. Proprietary items shall be fixed in place in accordance with manufacturers instructions.		Type Cert		Drawn by: PM		Checked by: PM		Date: 15/05/25		Scale: 1:250, 1:500@AC		Rev: 05		Date: 15/05/25		bkd architects	
6. Scope of preliminary items shall be checked with manufacturer.		Construction		Drawn by: PM		Checked by: PM		Date: 15/05/25		Scale: 1:250, 1:500@AC		Rev: 05		Date: 15/05/25		bkd architects	
7. The contractor shall be responsible for the coordination of structure, finishes and services.		As Built		Drawn by: PM		Checked by: PM		Date: 15/05/25		Scale: 1:250, 1:500@AC		Rev: 05		Date: 15/05/25		bkd architects	
		Information Only		Drawn by: PM		Checked by: PM		Date: 15/05/25		Scale: 1:250, 1:500@AC		Rev: 05		Date: 15/05/25		bkd architects	