



01 Character Area 1B/1C Contiguous Street Elevation - ROAD 31 NORTH
1:500 @ A0




02 Character Area 1B/1C Contiguous Street Elevation - ROAD 32 NORTH
1:250@A0



03 Character Area 1B/1C Contiguous Street Elevation - ROAD 32/31 SOUTH
1:500 @ A0



04 Character Area 1B/1C Contiguous Street Elevation - ROAD 31 SOUTH
1:250@A0

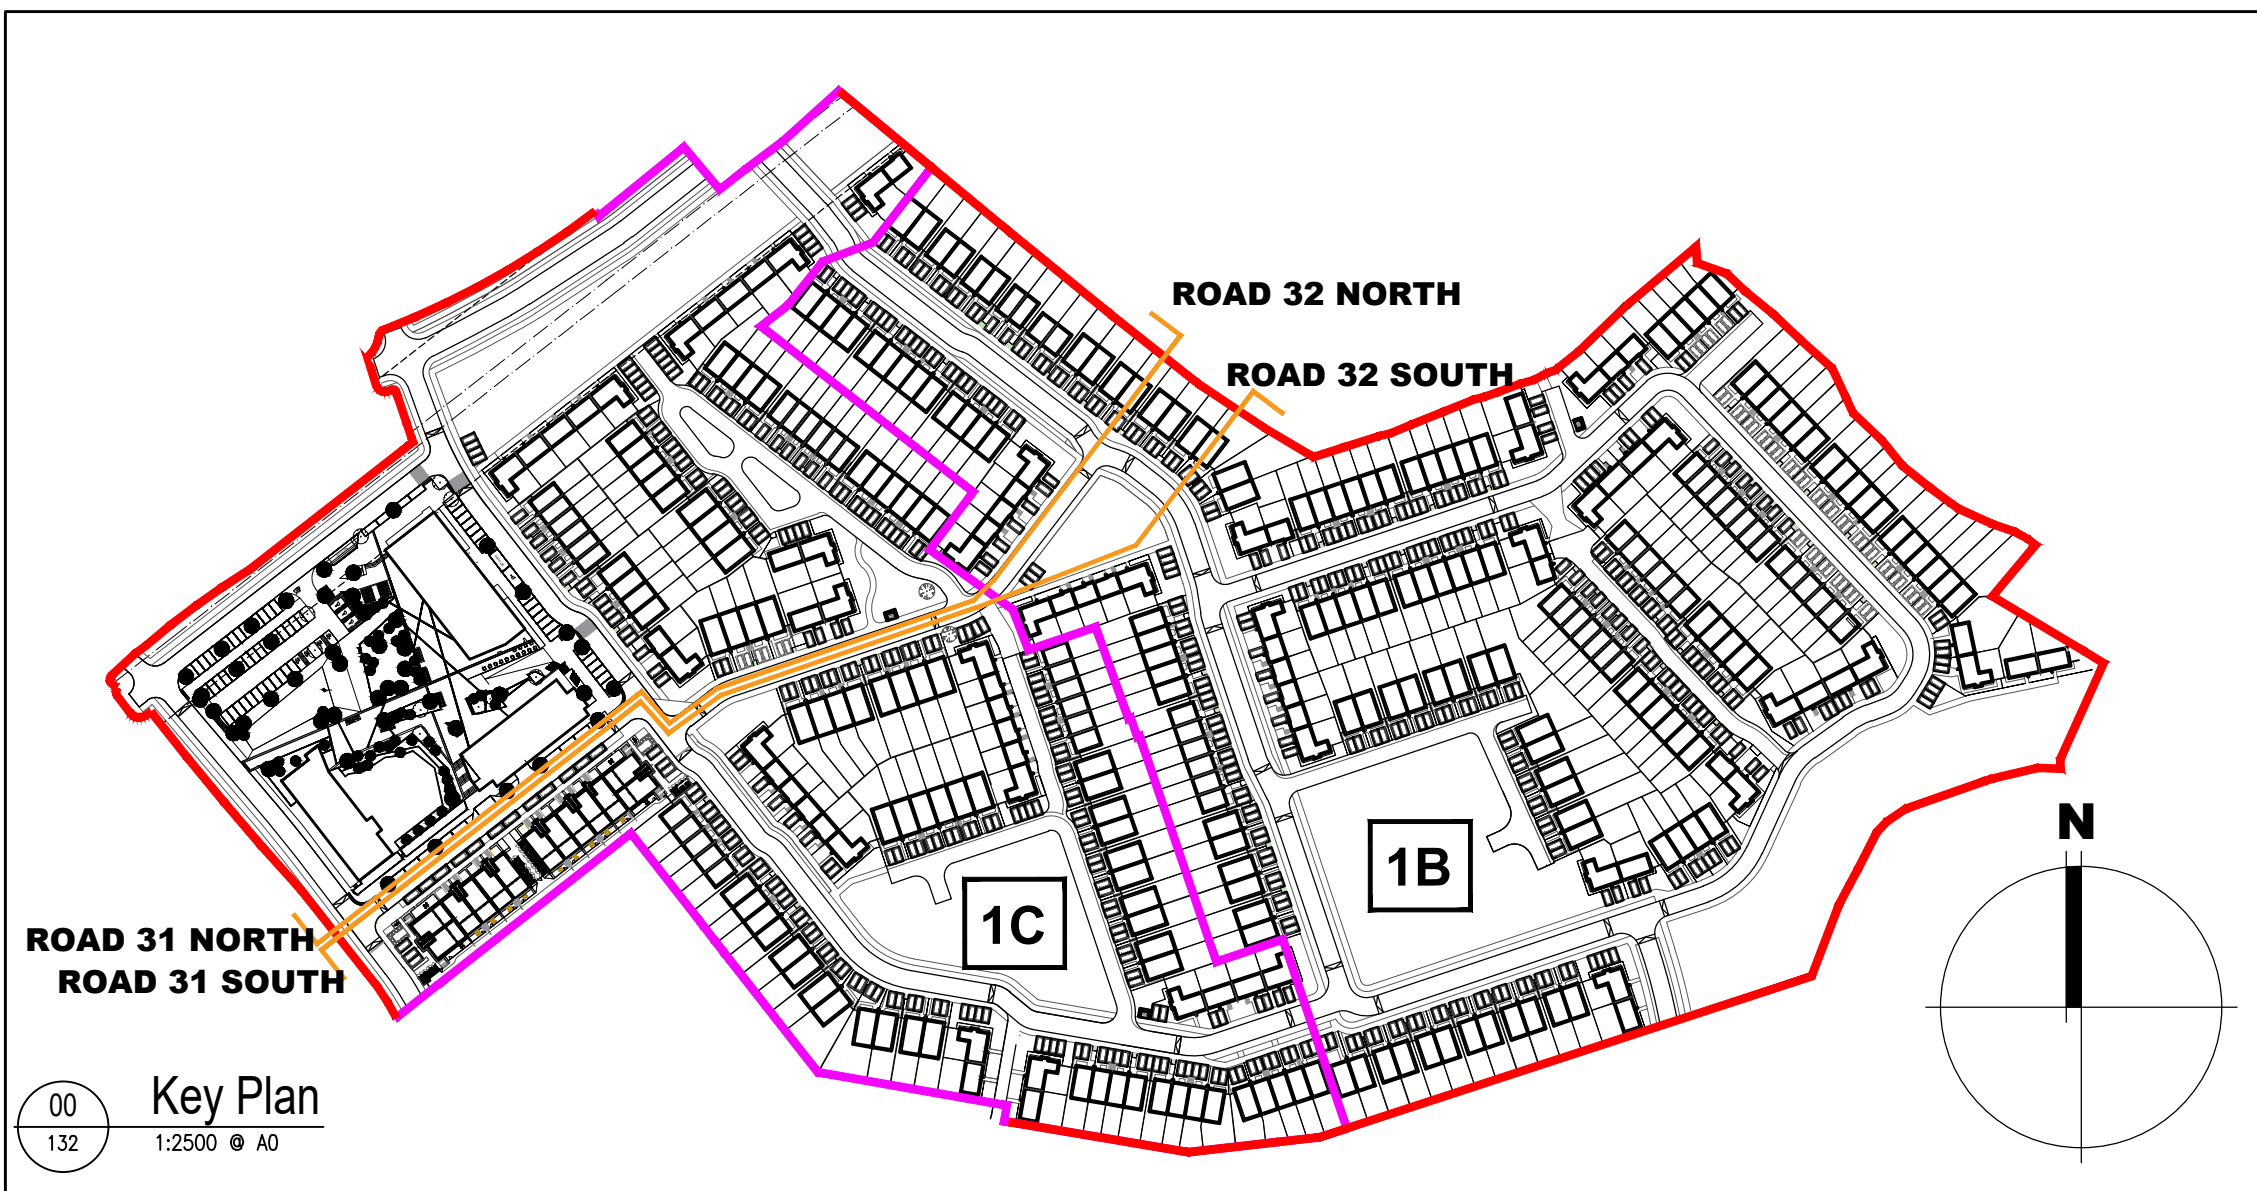

No. Date Revision		Initials	Project		Mixed Use Residential & Commercial Development at Kilbride, Arklow, Co. Wicklow		© 7 HANCOCK TERRACE, DUBLIN 8, IRELAND T: +353 1 438 8800 F: +353 1 438 8801 www.bkd.ie
01	25/09/24	ED	01	25/09/24	ED	01	25/09/24
02	25/09/24	ED	02	25/09/24	ED	02	25/09/24
03	08/04/25	PM	03	08/04/25	PM	03	08/04/25
04	16/04/25	ED	04	16/04/25	ED	04	16/04/25
05	15/09/25	ED	05	15/09/25	ED	05	15/09/25

Drawing No. 6191-PP-132		Scale 1:250, 1:500@A0		Rev. 05		Drawn ED, PM		Date 15/09/25	
-------------------------	--	-----------------------	--	---------	--	--------------	--	---------------	--

bkdarchitects		BURRE-SKENNEDY DOYLE	
---------------	--	----------------------	--

Notes:
1. Copyright Reserved
2. Work to agreed dimensions only. Do not scale drawing.
3. The contractor is responsible for checking all levels and dimensions on site and shall refer all discrepancies to the Architect.
4. Where appropriate, for details of e.g. structure, or mechanical and electrical details, see Engineers drawings.
5. Proprietary items shall be fixed in strict accordance with manufacturers instructions.
6. Scope of preliminary items shall be checked with manufacturer.
7. The contractor shall be responsible for the coordination of structure, finishes and services.

Issue/Status
Progress
Planning Application
Permit
Disability Cert
Type/Construction
As Built
Information Only

15/09/2025 14:28:59