




01 Character Area 1B/1C Contiguous Street Elevation - ROADS 33 & 34 EAST

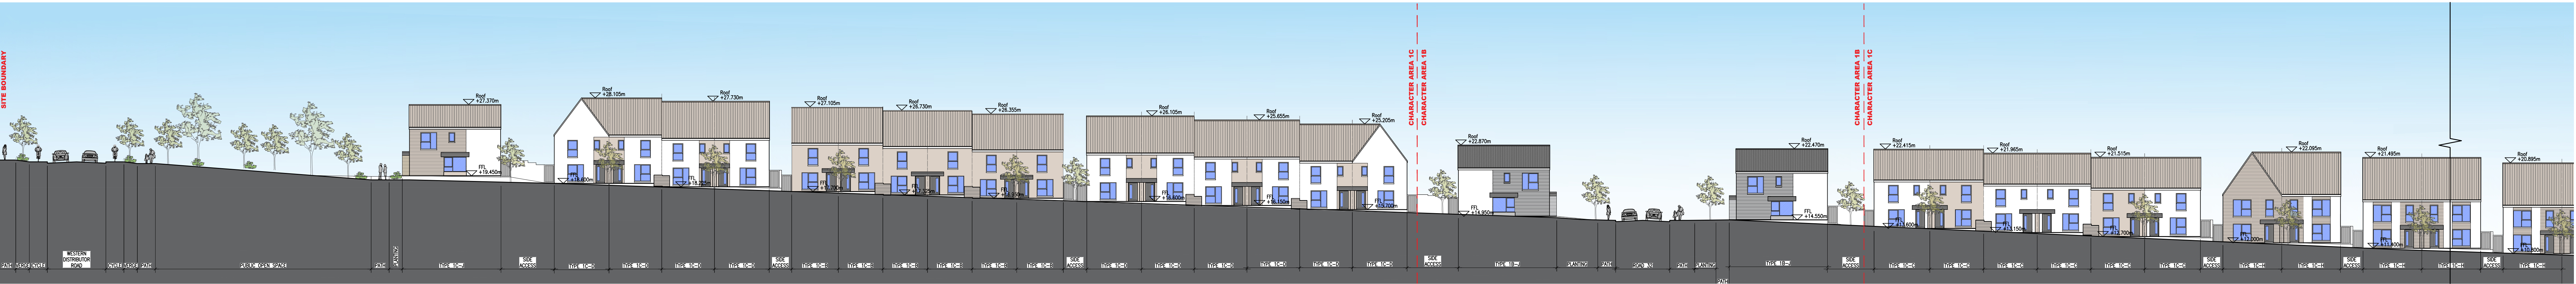


02 Character Area 1B/1C Contiguous Street Elevation - ROADS 33 & 34 EAST

Notes	
1. Copyright Reserved	
2. Work to be signed dimension only. Do not scale drawing	
3. The contractor is responsible for checking all levels and dimensions on site and shall refer all discrepancies to the Architect	
4. Where appropriate, for details of e.g. structure, or mechanical and electrical details, see Engineers drawings	
5. Proprietary items shall be fixed in strict accordance with manufacturers instructions	
6. Scope of preliminary items shall be checked with manufacturer	
7. The contractor shall be responsible for the coordination of structure, finishes and services	

Issue Status	
Progress	
Planning Application	
Final Cert	
Disability Cert	
Type Cert	
Construction	
As Built	
Information Only	

01 Project Section - Currents 101 Andrew Horgan/CAD/Drawings/Planning/2025/Site Drawings/01-APP-030_Street Elevations.dwg 15/05/2025 14:24:09

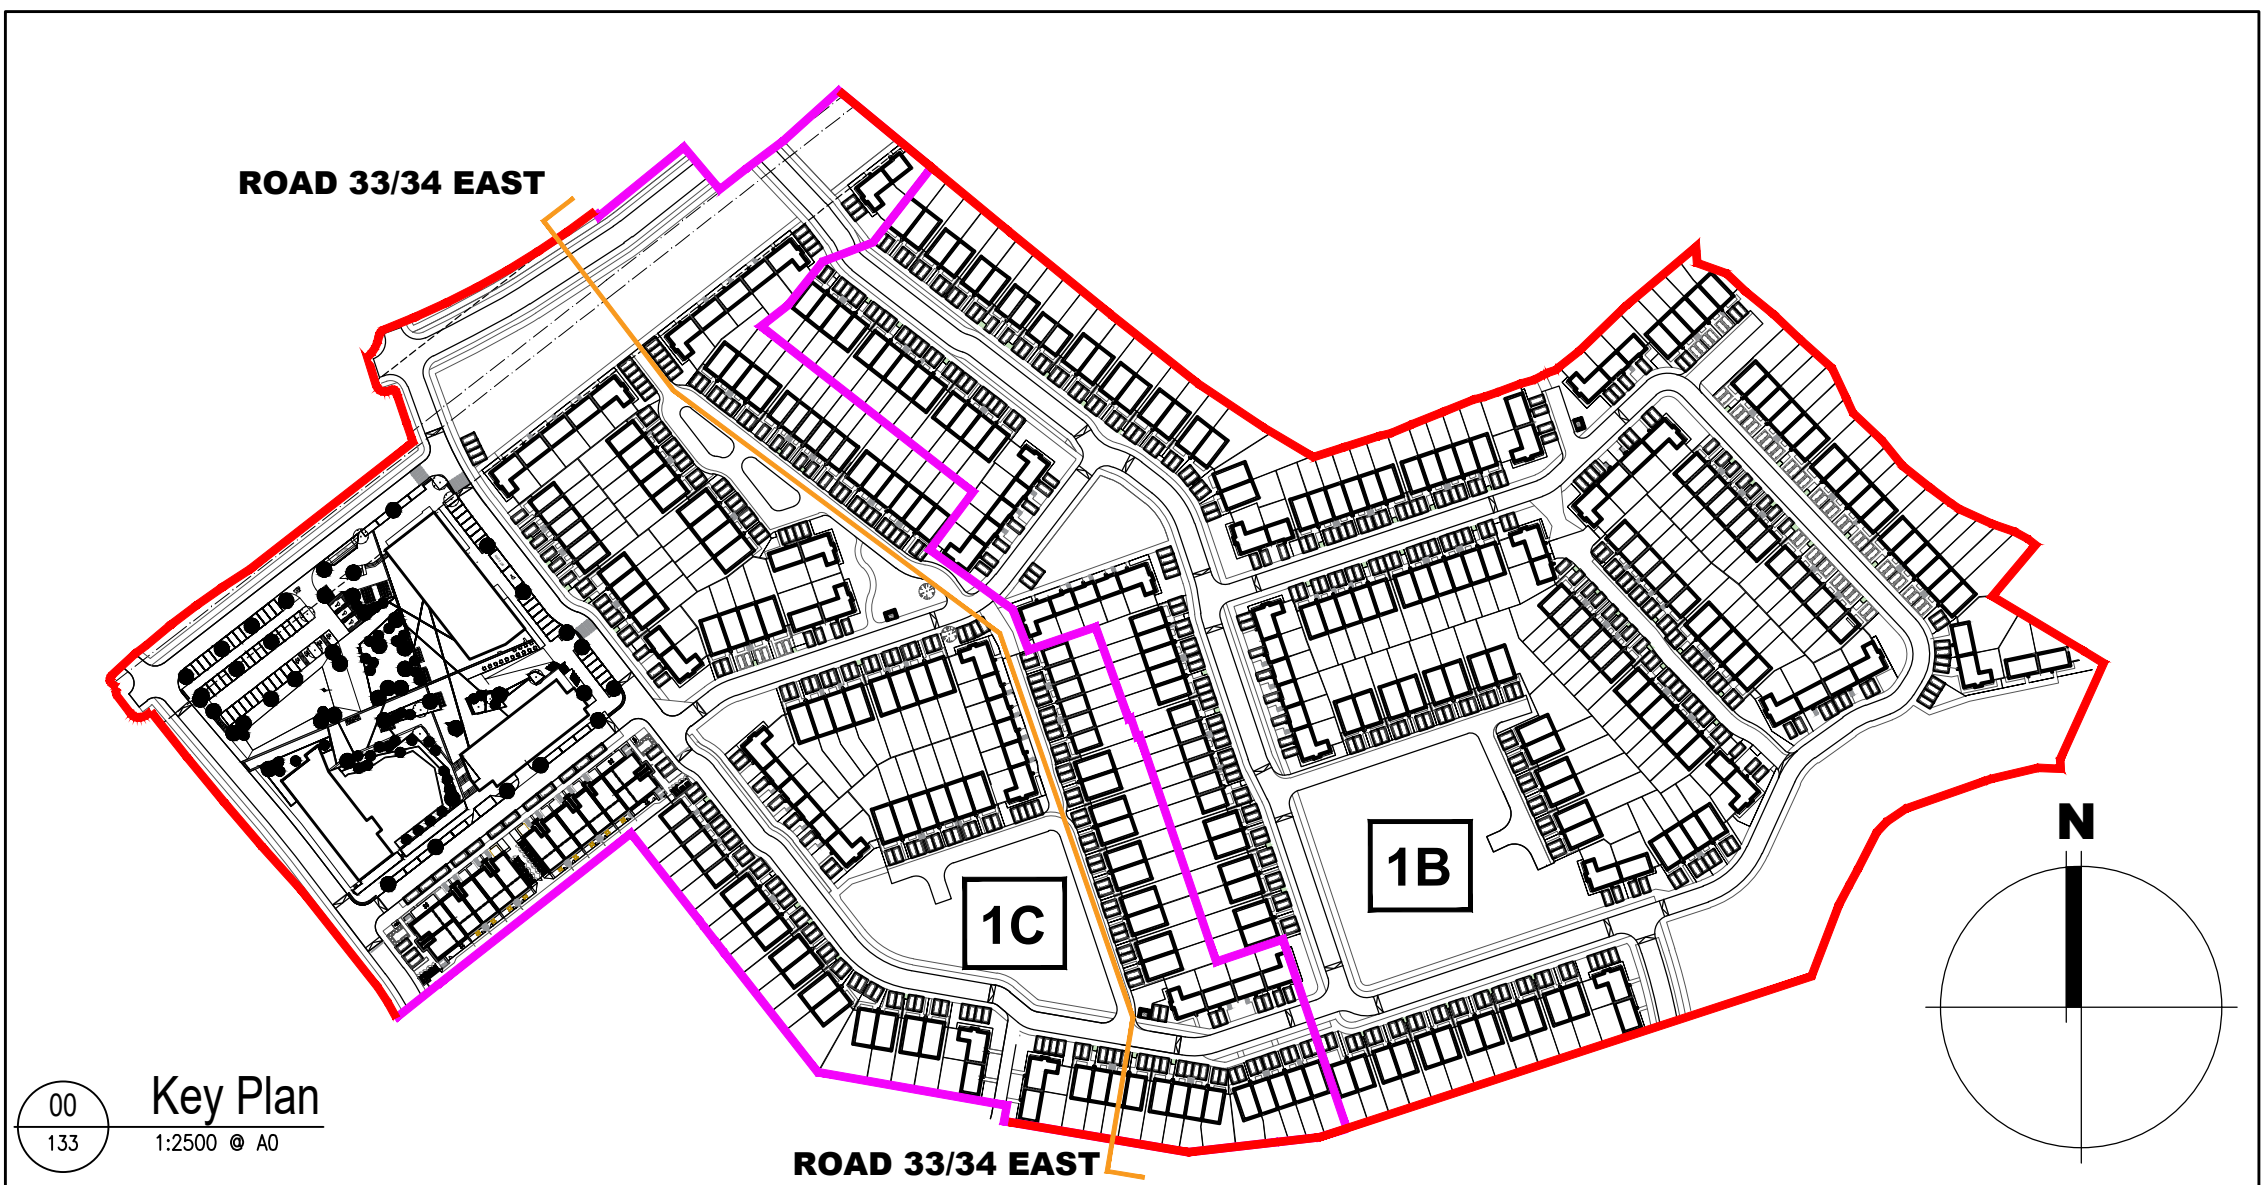

00 Key Plan

No.	Date	Revision	Initials
01	25/09/24	Draft Issue for Cds	ED
02	25/10/24	LRD Pre Planning Issue	ED
03	08/04/25	Levels updated and cousted - house types updated	PM
04	16/04/25	Draft Planning Issue	ED
05	15/05/25	Pending Issue	ED

Project Mixed Use Residential & Commercial Development at Kilbride, Arklow, Co. Wicklow

Drawing Title CHARACTER AREA 1B AND 1C STREET ELEVATIONS - SHEET 4 OF 4

Drawing No. 6191-PP-133
Scale 1:200 & 1:500@A0 Rev 05 Drawn ED, PM Date 15/05/25

8-7 HANQUITY TERRACE, DUBLIN 8, IRELAND
T: +353 1 4581800 F: +353 1 4581801
www.bkd.ie

bkdarchitects
BURREN-SENNEDY DOYLE