
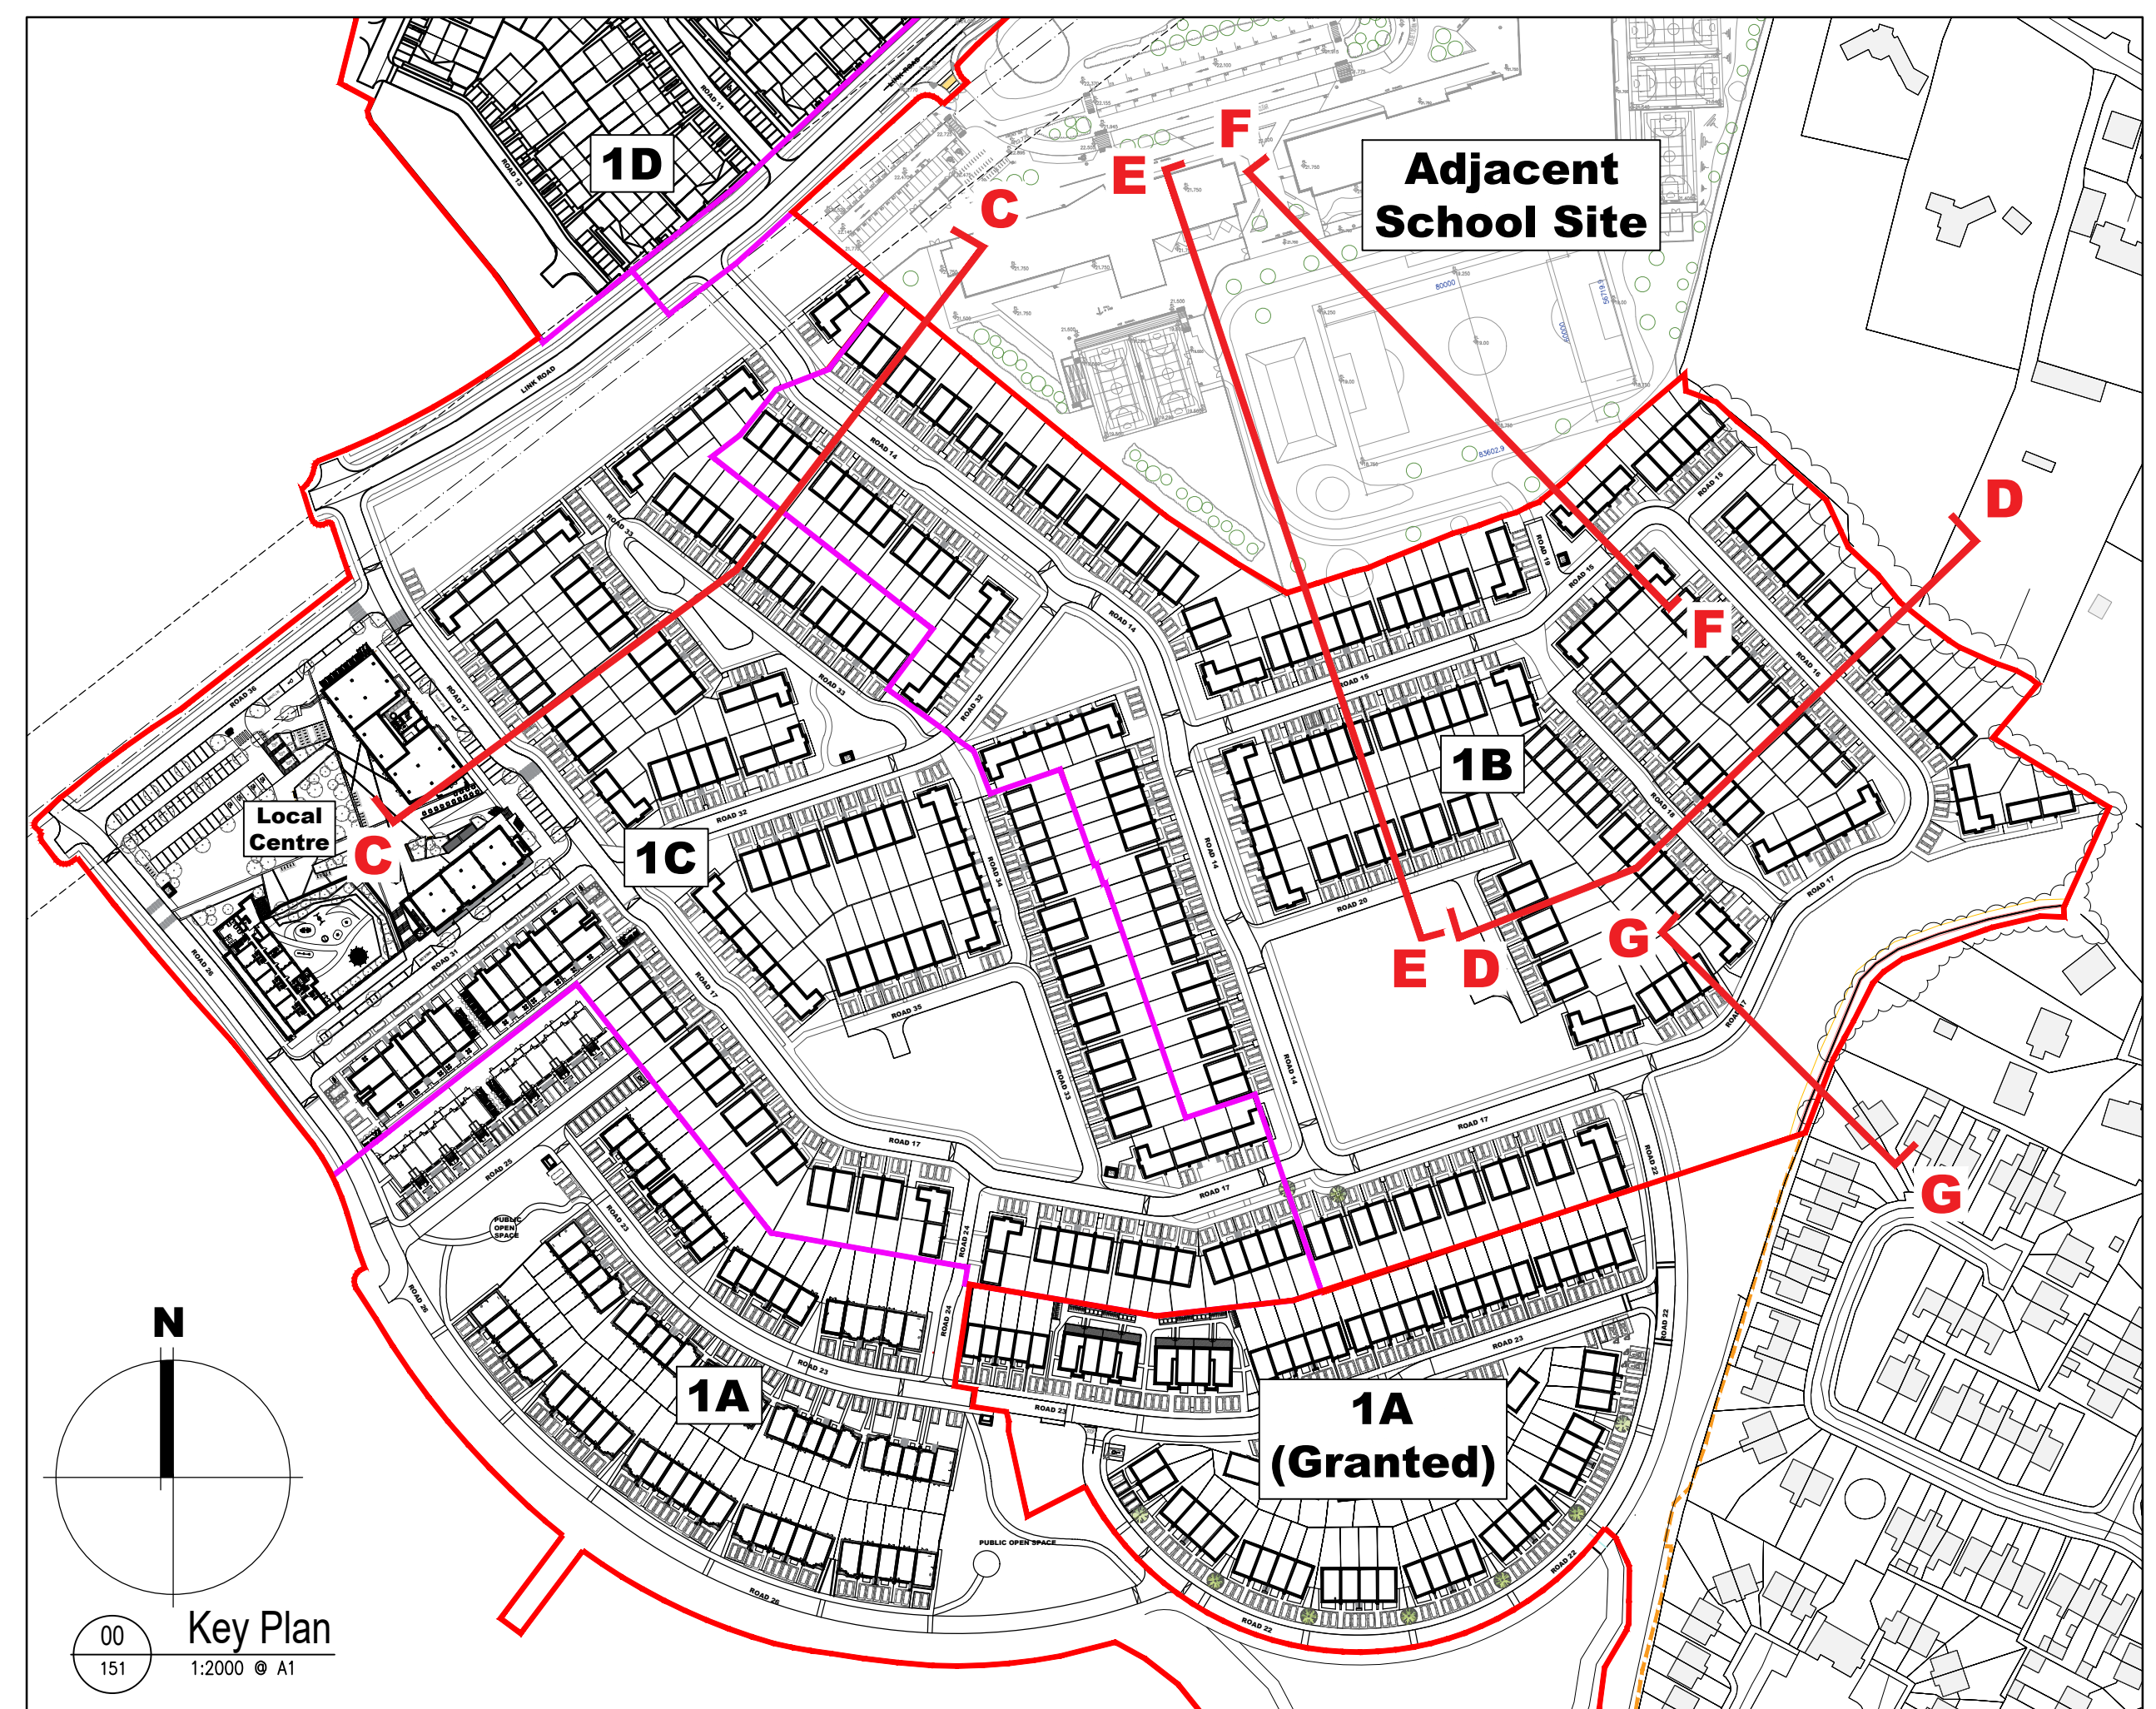
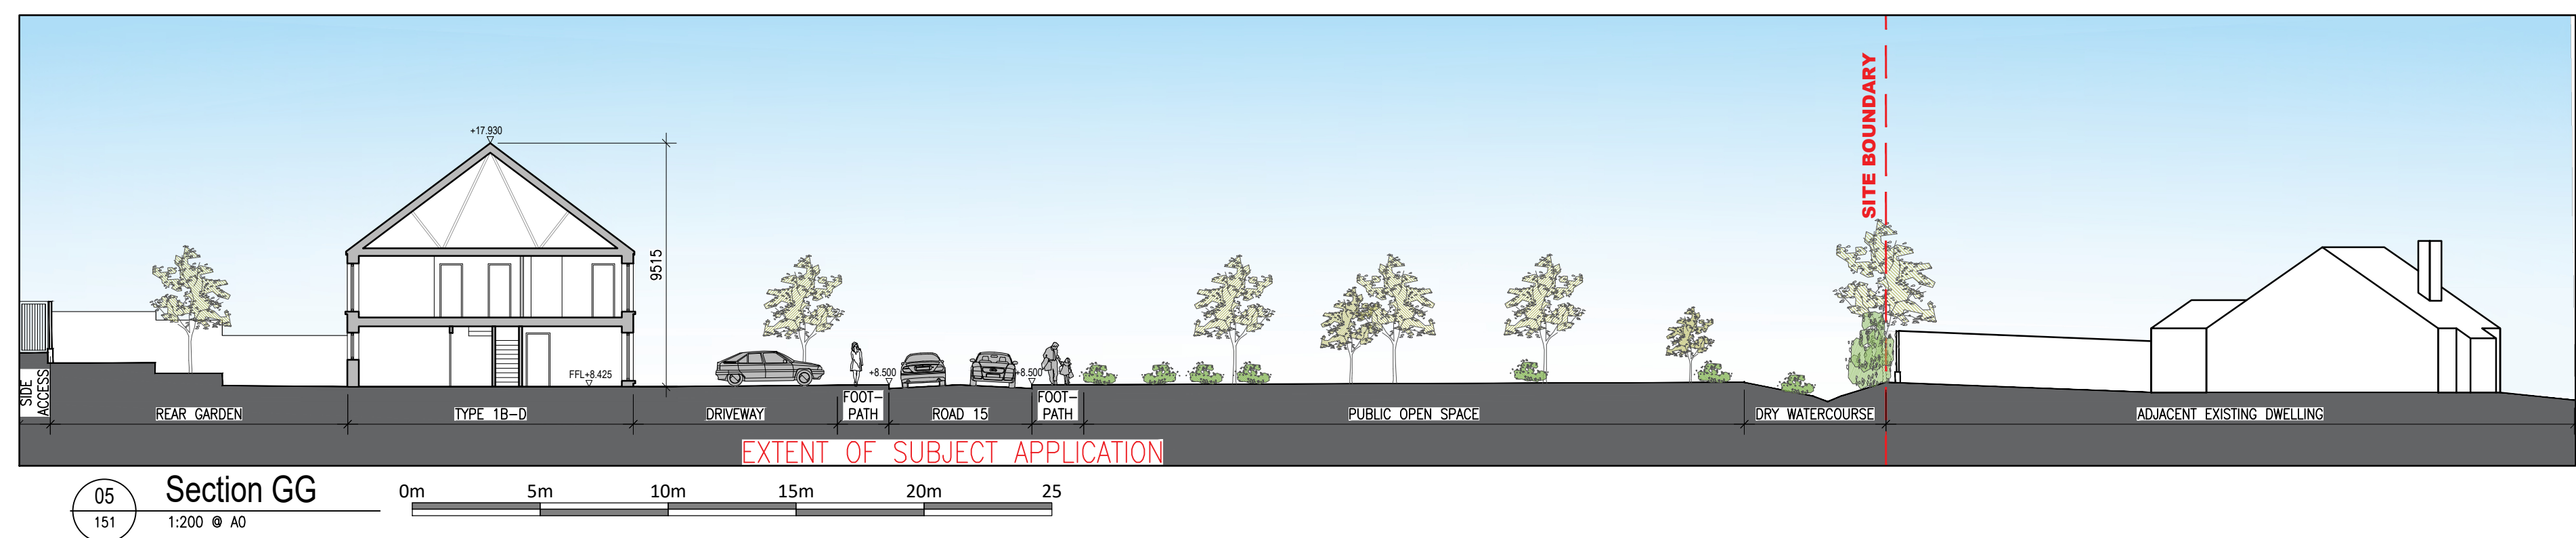
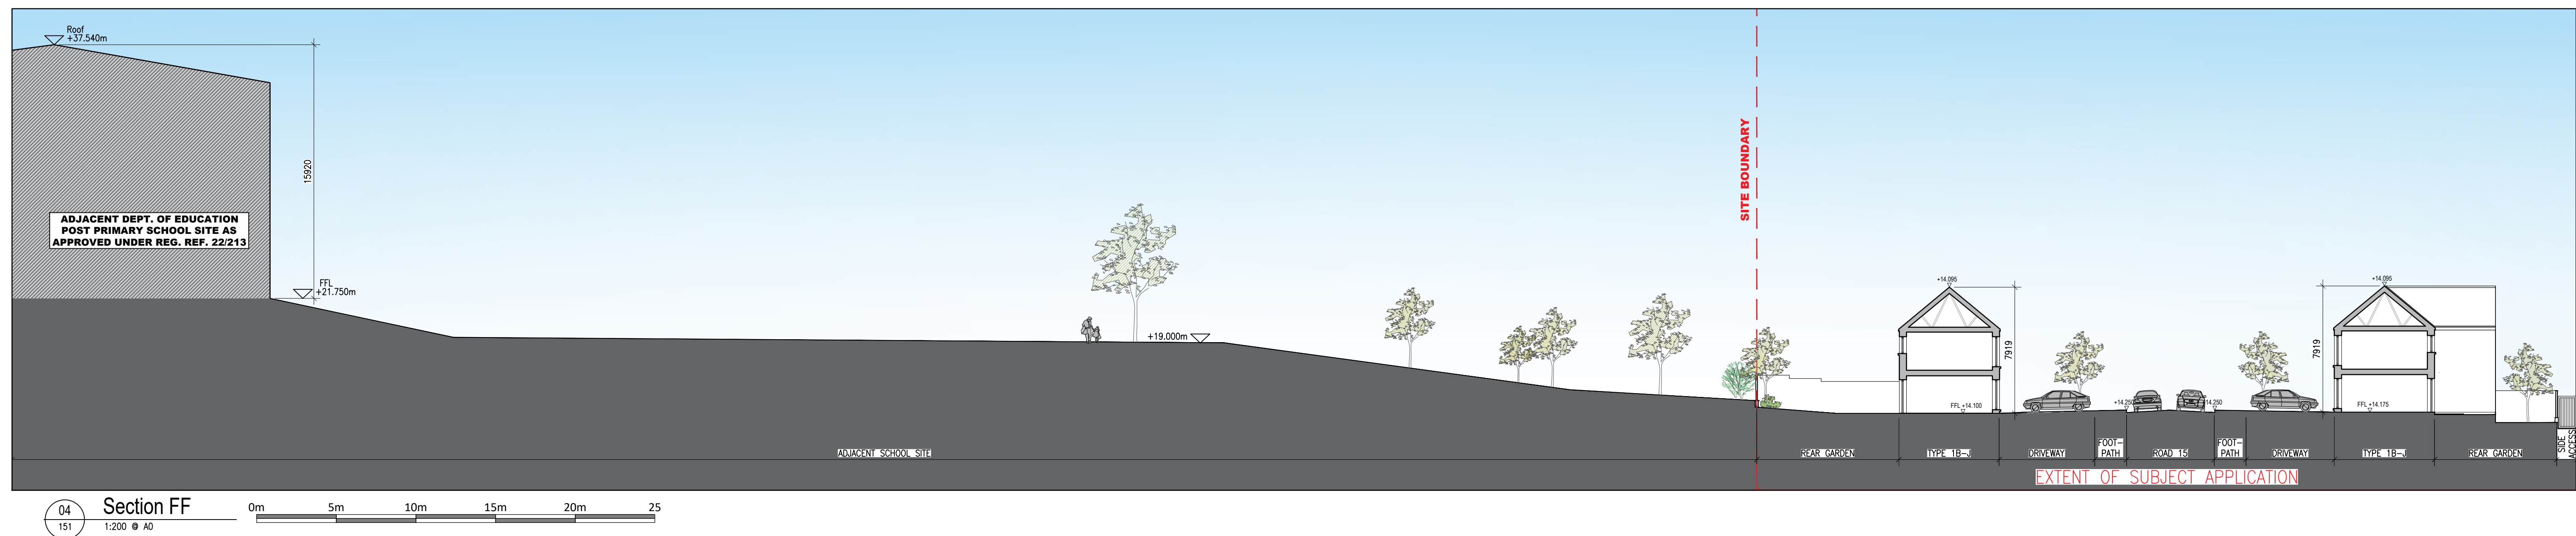
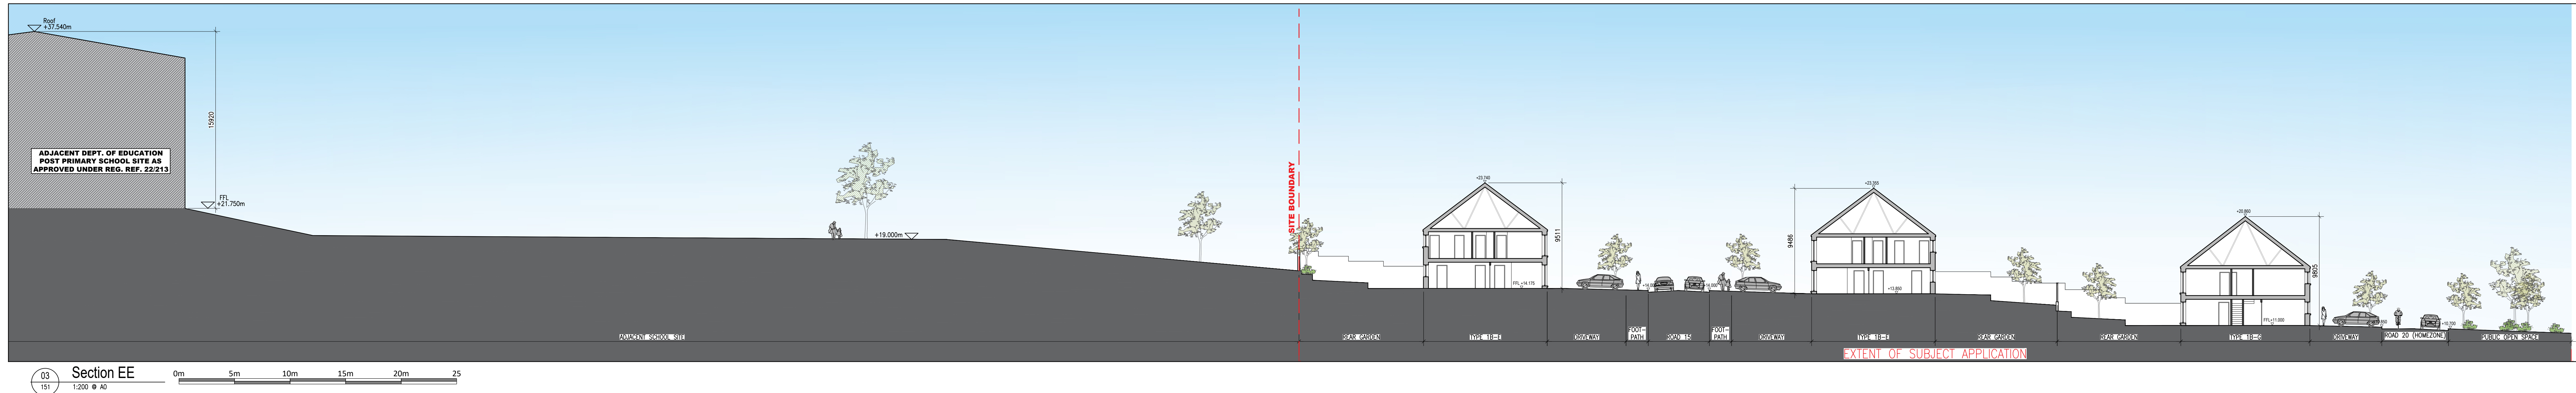


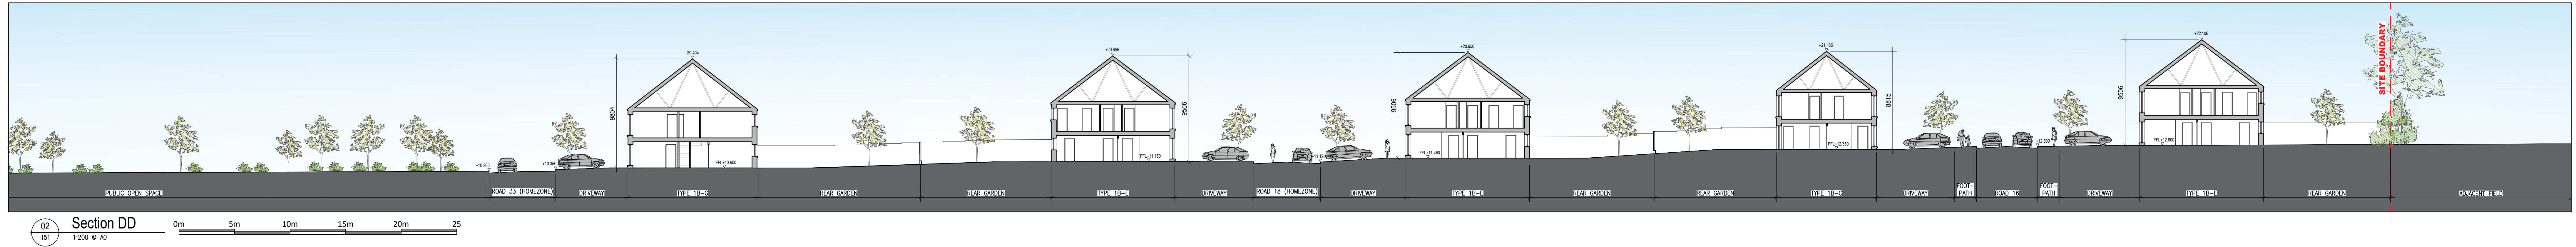

Notes 1. Copyright Reserved 2. Plot is Special dimension only. Do not scale drawing. 3. The contractor is responsible for checking all levels and dimensions on site and shall refer all discrepancies to the Architect 4. Where applicable, for details of all structures, or mechanical and electrical details, see Engineer's drawings. 5. Popularity items shall be fixed in strict accordance with manufacturers instructions. 6. Details of proprietary items shall be checked with manufacturer. 7. The contractor shall be responsible for the coordination of structural, finishes and services. W:\Project Section - Current\0191 Aldous Housing\AOZ\Drawings\Planning 2023\Site Drawings\0191-PP-151_Site Sections.dwg 11:43:24						Issue Status Proposed Planning Application Firm Cert Disability Cert Tender Construction As Built Information Only						Initials ED					
Project Mixed Use Residential & Commercial Development at Kilbirnie, Arklow, Co. Wicklow Character Area 1B and 1C - Site Sections Sheet 2 of 3 Drawing No: 6191-APP-151 Scale: 1:200 @ A0 Date: 15/05/25						Revision Rev 01 Drawn: PJM, ED						Client BURKE-KENNEDY DOYLE					