




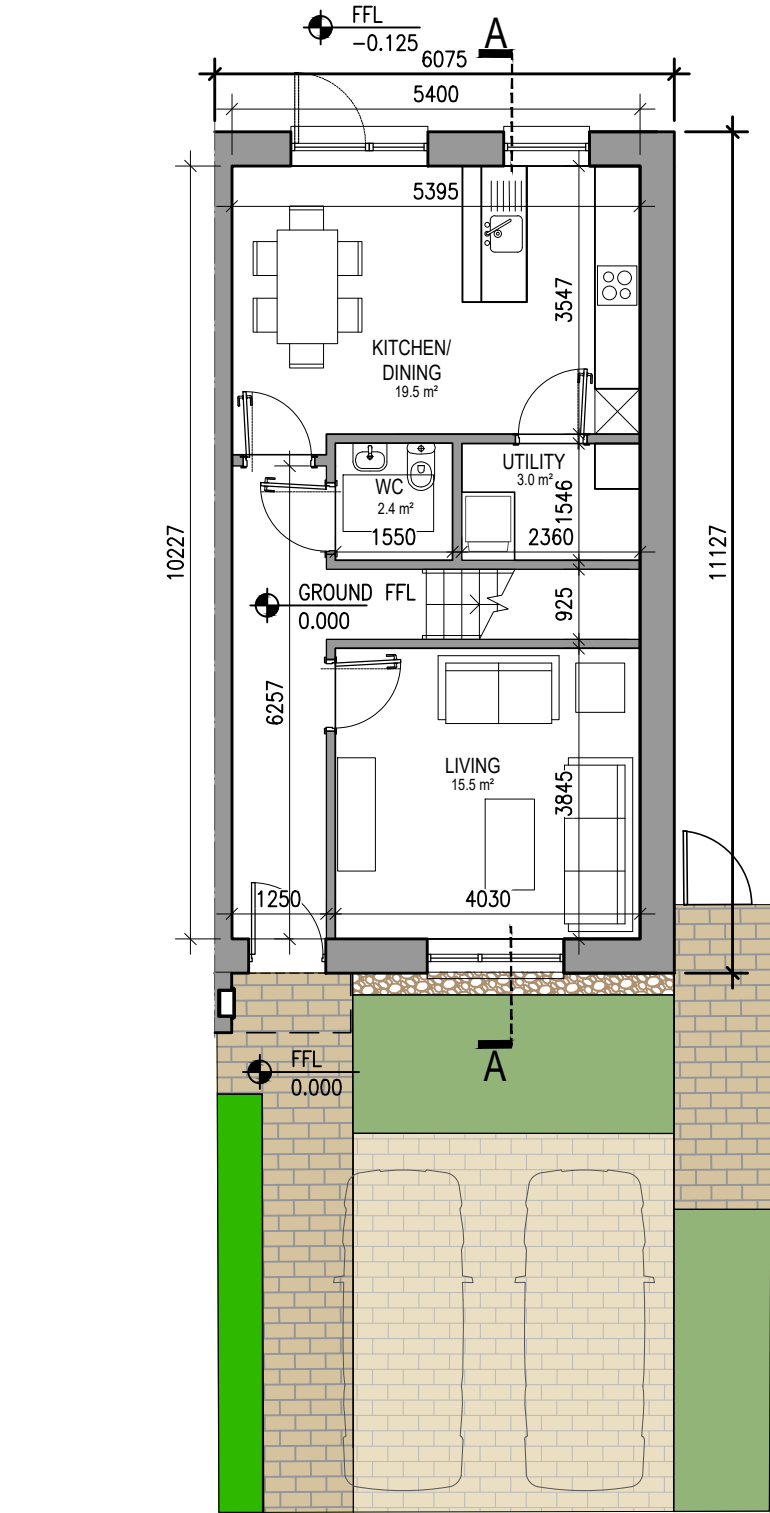


01 Type D2 - Ground Floor Plan
1:100@A1
3 BED HOUSE

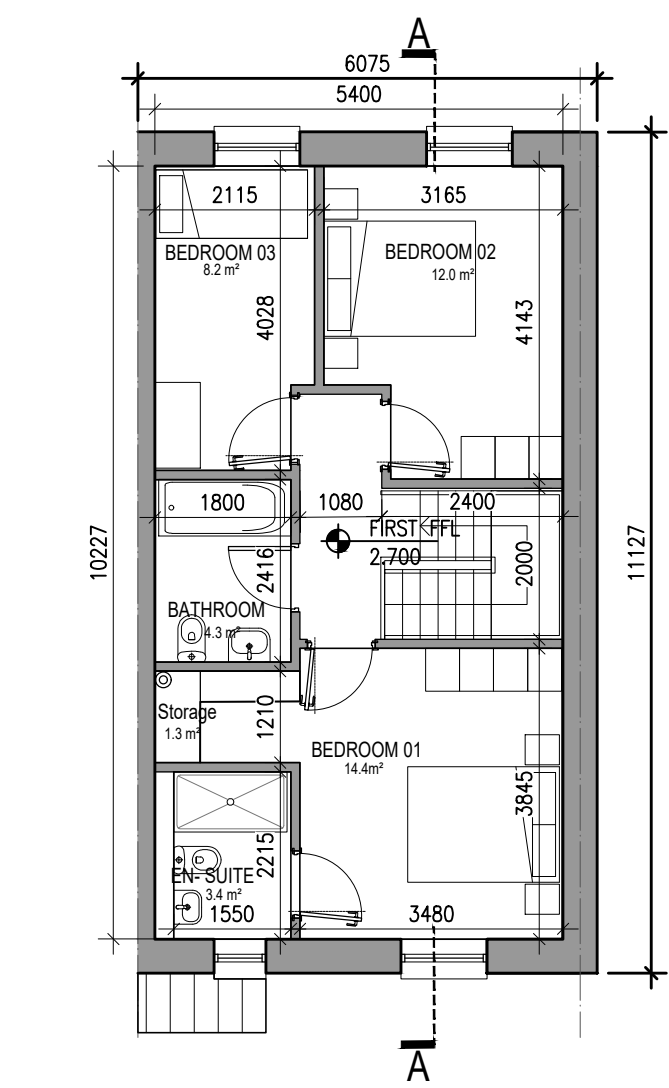


02 Type D2 - First Floor Plan
1:100@A1
3 BED HOUSE

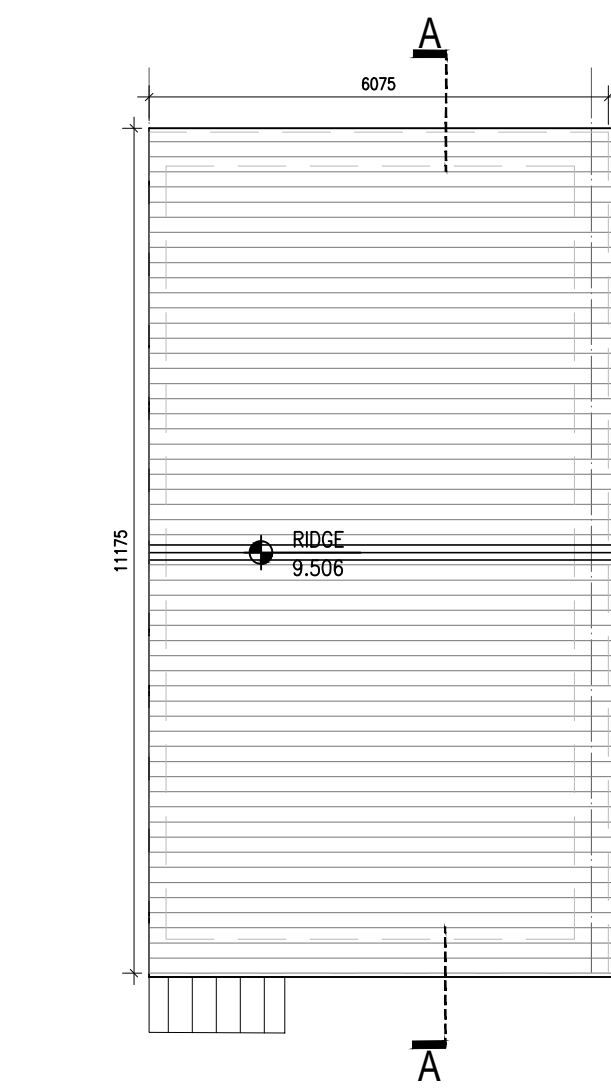


03 Type D2 - Roof Plan - V1
1:100@A1
3 BED HOUSE

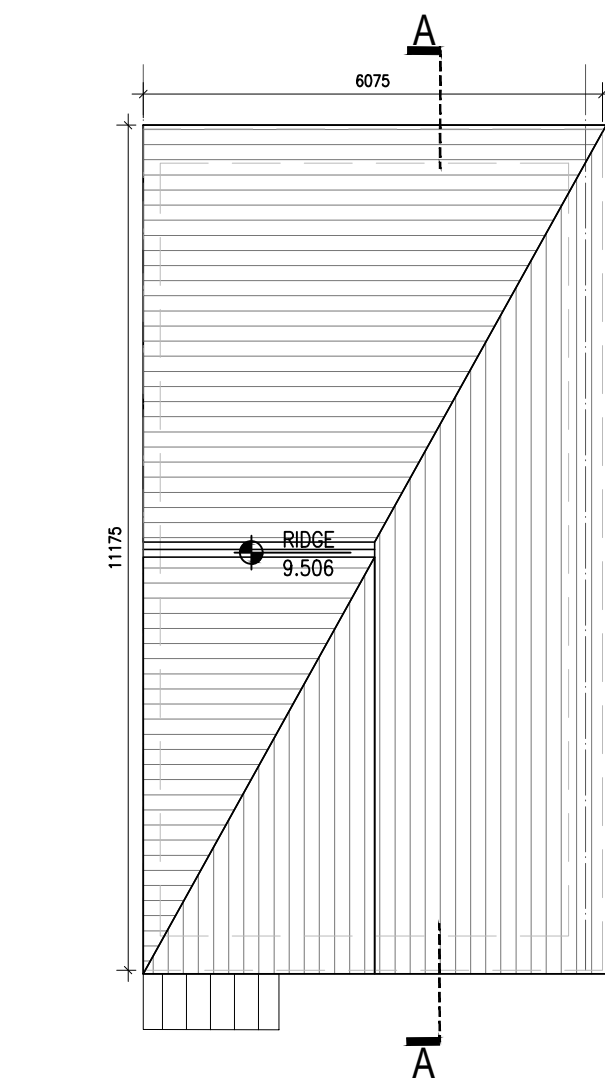


04 Type D2 - Roof Plan - V2
1:100@A1
3 BED HOUSE

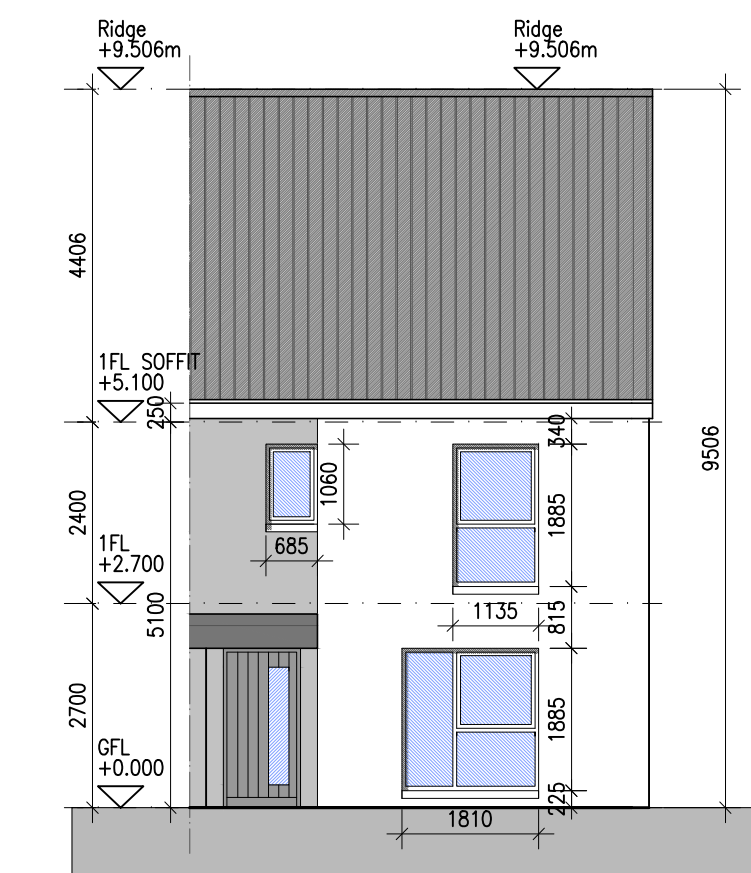


05 Type D2 - Front Elevation [Character Area 1B V1]
1:100@A1
3 BED HOUSE

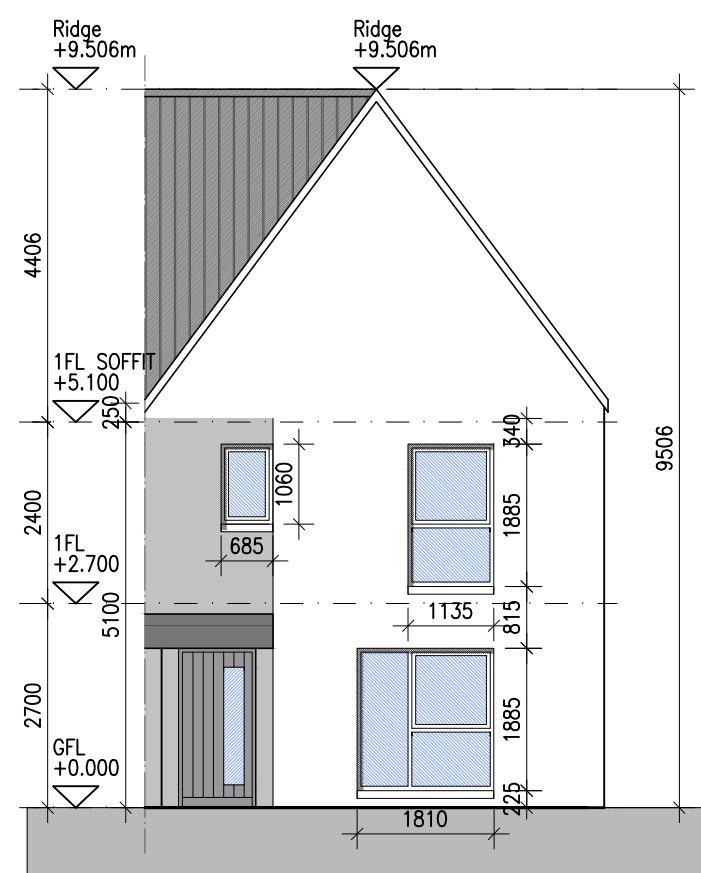


06 Type D2 - Front Elevation [Character Area 1B V2]
1:100@A1
3 BED HOUSE

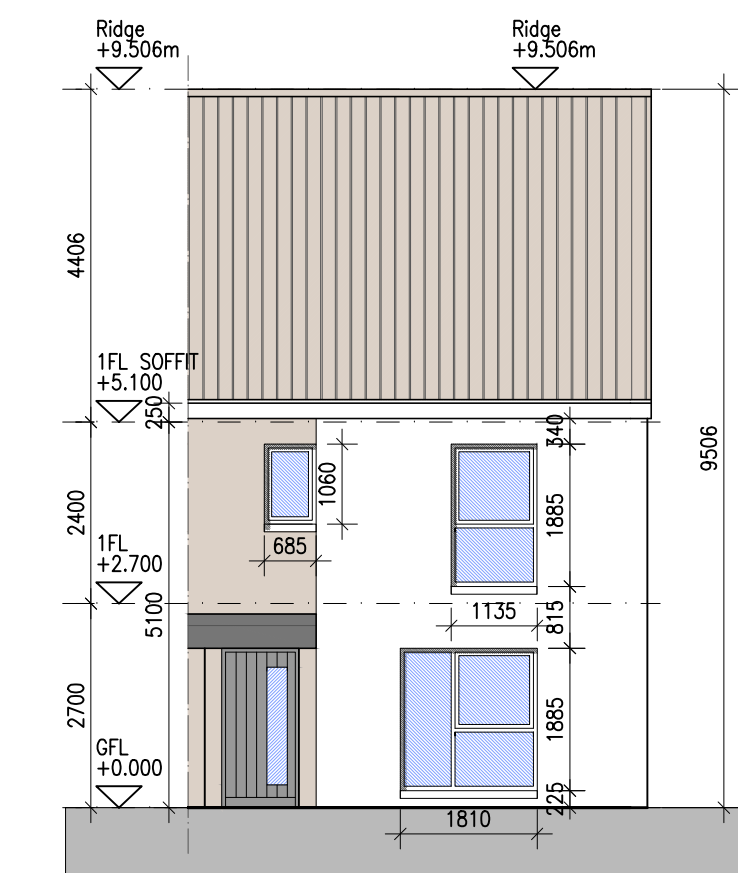


07 Type D2 - Front Elevation [Character Area 1C V1]
1:100@A1
3 BED HOUSE

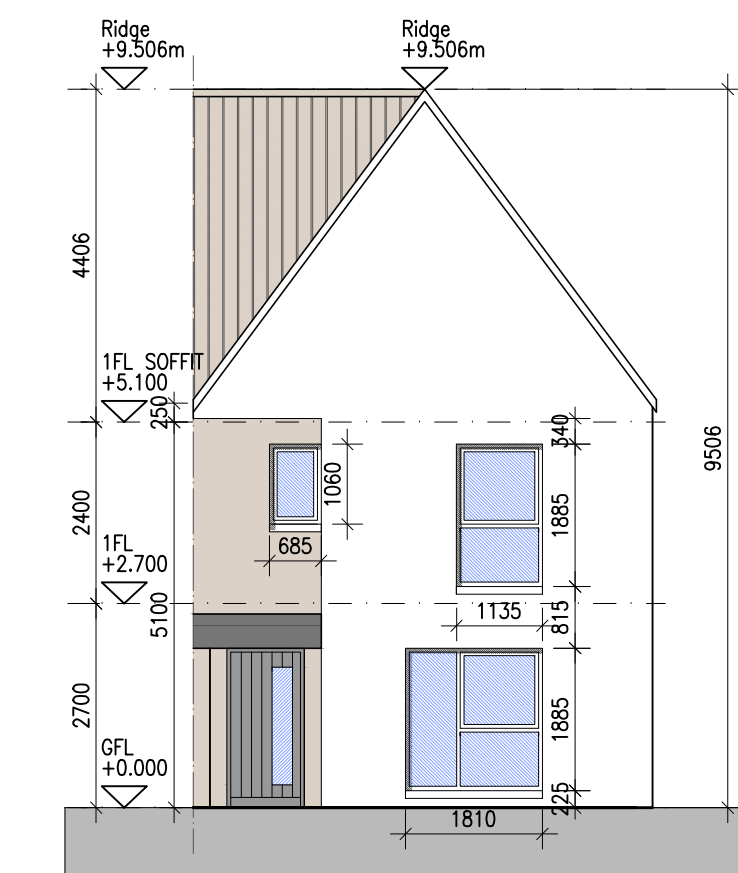


08 Type D2 - Front Elevation [Character Area 1C V2]
1:100@A1
3 BED HOUSE

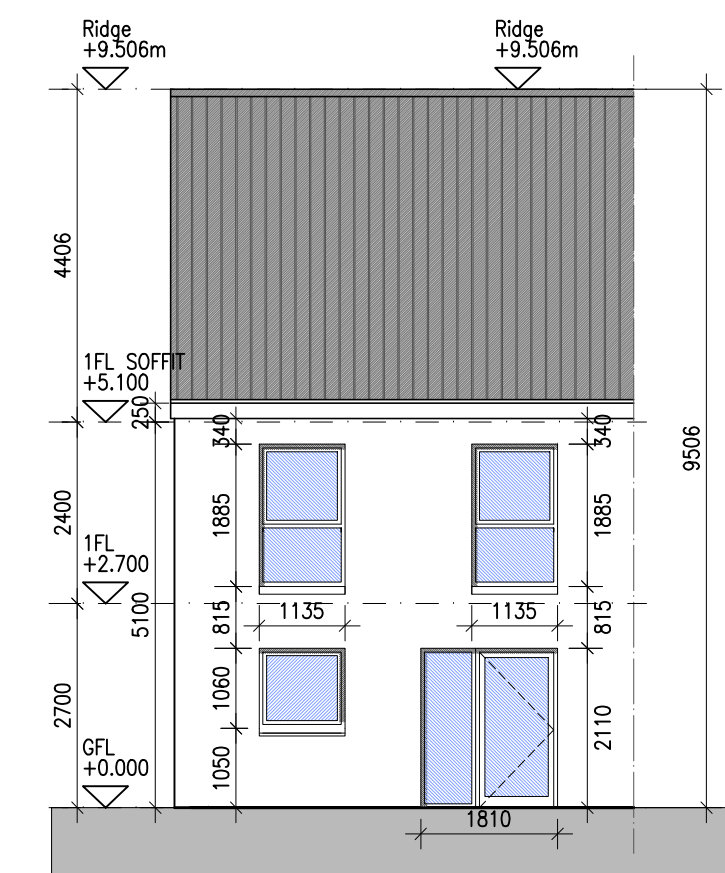


09 Type D2 - Rear Elevation [V1]
1:100@A1
3 BED HOUSE

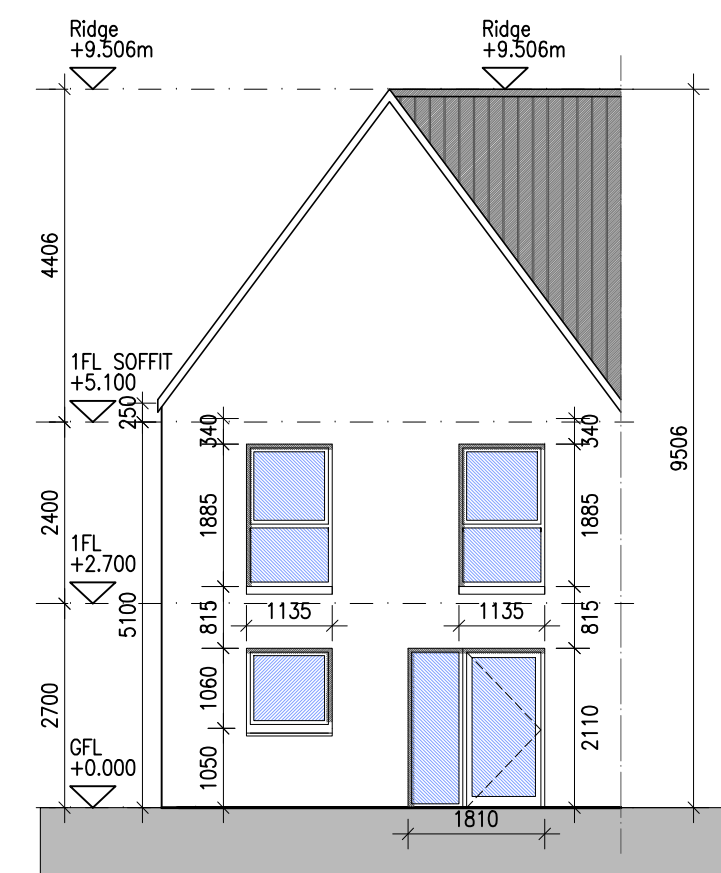


10 Type D2 - Rear Elevation [V2]
1:100@A1
3 BED HOUSE

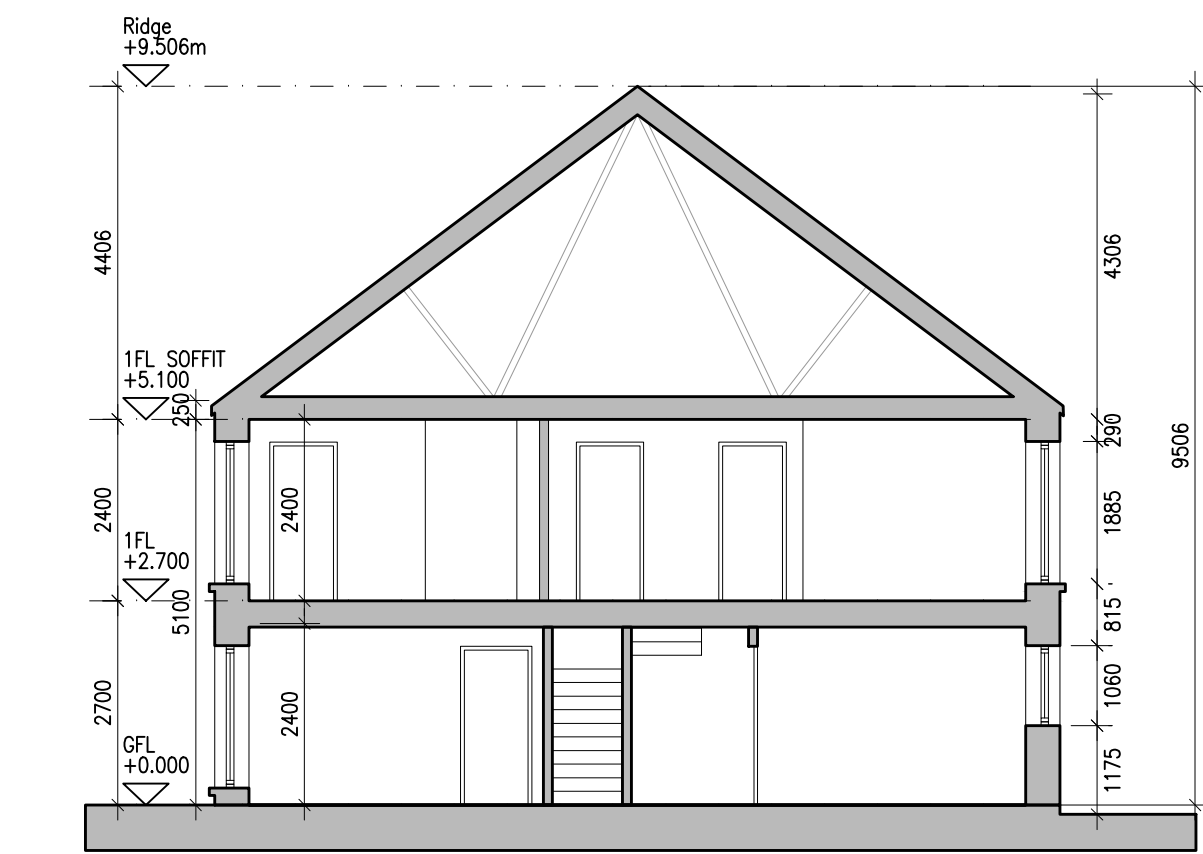

11 Type D2 - Section AA
1:100@A1
3 BED HOUSE

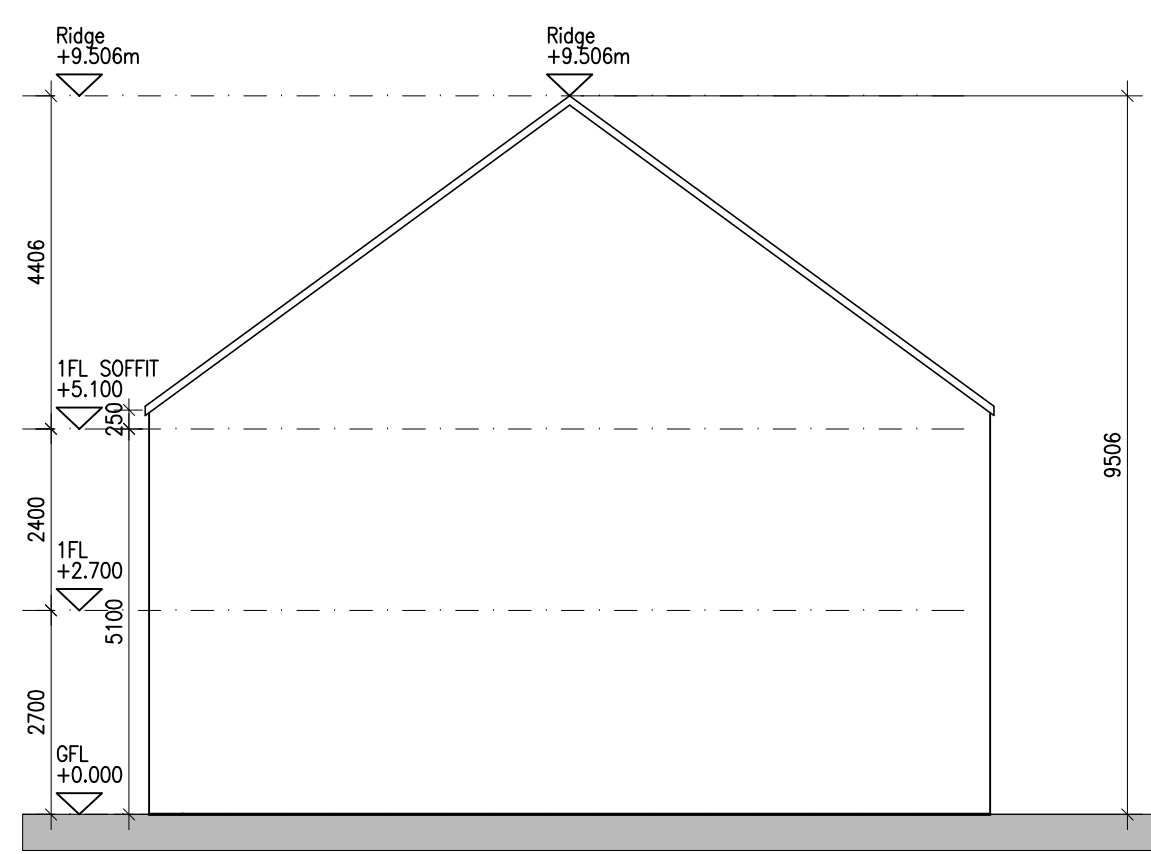


12 Type D2 - Side Elevation V1
1:100@A1
3 BED HOUSE

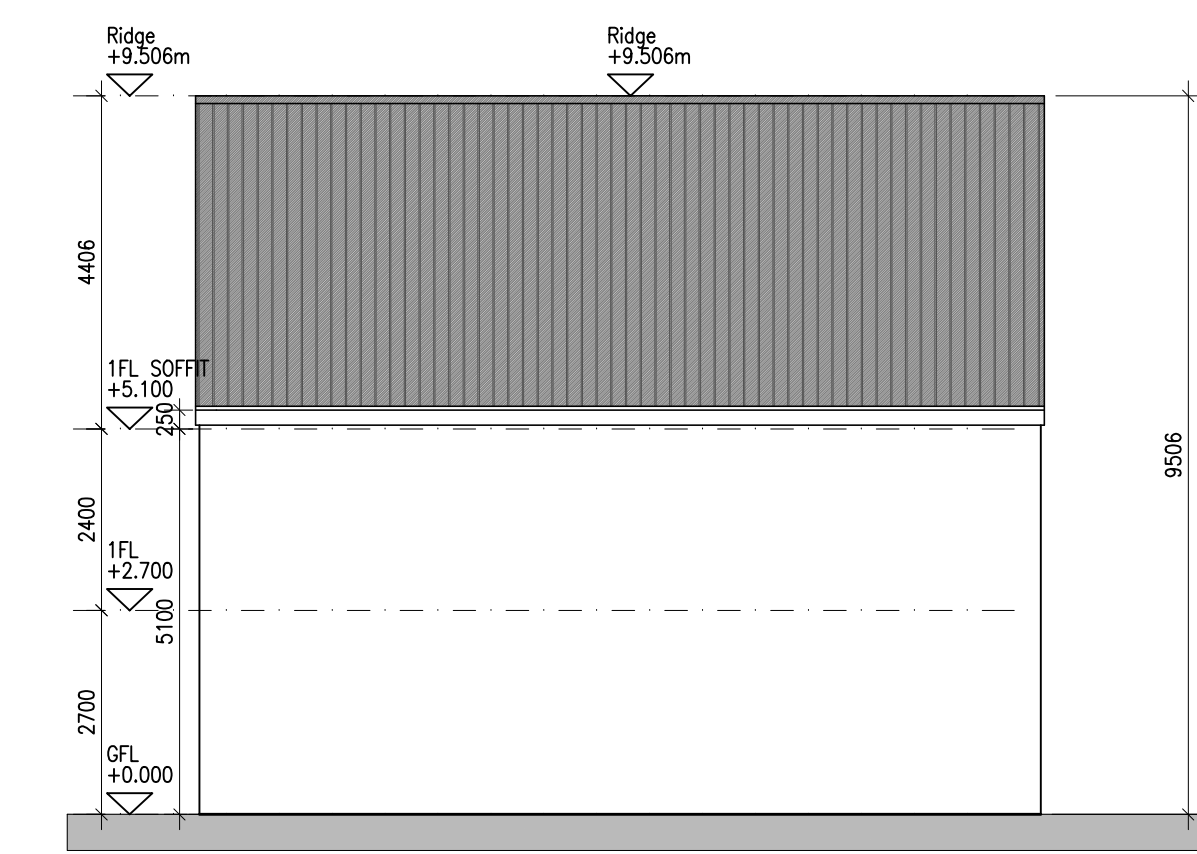

13 Type D2 - Side Elevation V2
1:100@A1
3 BED HOUSE

HOUSE TYPE D2
Ground floor area 55.2m²
First floor area 55.2m²
Total Floor Area (3-bed unit): 110.4m²

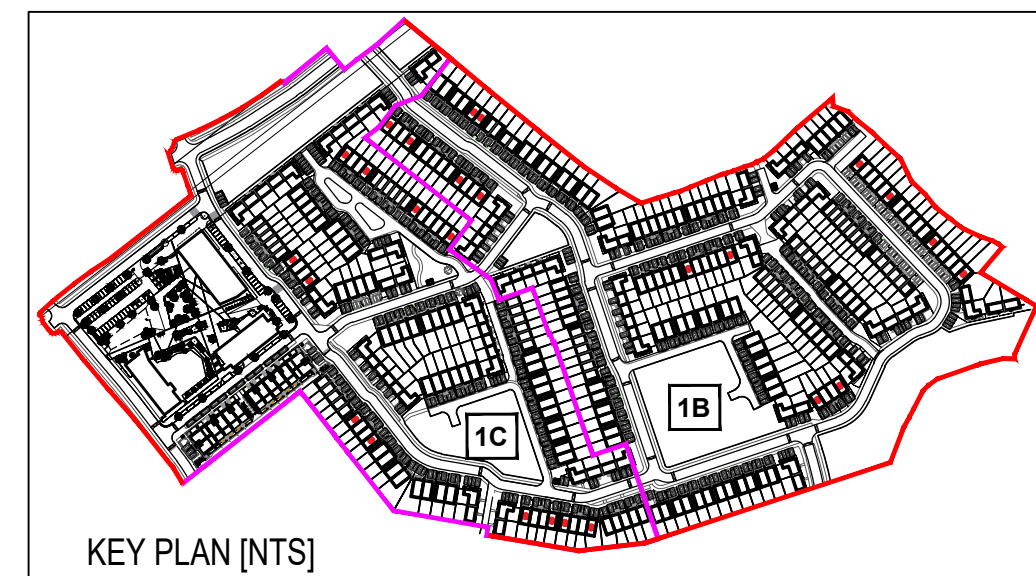

Notes	1. Copyright Reserved	Issue Status	Progress	Planning Application	Fire Cert	Disability Cert	Tender	Construction	As Built	Information Only	3_204 (D1, D2).dwg 14/05/2025	No.	Date	Revision	Initials
	2. Work to figured dimensions only. Do not scale drawing														
3. The contractor is responsible for checking all levels and dimensions on site and shall refer all discrepancies to the Architect	4. Where appropriate, for details of r.c. structure, or mechanical and electrical details, see Engineers drawings	5. Proprietary items shall be fixed in strict accordance with manufacturers instructions.	6. Sizes of proprietary items shall be checked with manufacturer.	7. The contractor shall be responsible for the coordination of structure, finishes and services.	8. The contractor shall be responsible for the coordination of structure, finishes and services.	9. The contractor shall be responsible for the coordination of structure, finishes and services.	10. The contractor shall be responsible for the coordination of structure, finishes and services.	11. The contractor shall be responsible for the coordination of structure, finishes and services.	12. The contractor shall be responsible for the coordination of structure, finishes and services.	13. The contractor shall be responsible for the coordination of structure, finishes and services.	14. The contractor shall be responsible for the coordination of structure, finishes and services.	01	10/03/25	Draft Planning Issue	PMN
15. The contractor shall be responsible for the coordination of structure, finishes and services.	16. The contractor shall be responsible for the coordination of structure, finishes and services.	17. The contractor shall be responsible for the coordination of structure, finishes and services.	18. The contractor shall be responsible for the coordination of structure, finishes and services.	19. The contractor shall be responsible for the coordination of structure, finishes and services.	20. The contractor shall be responsible for the coordination of structure, finishes and services.	21. The contractor shall be responsible for the coordination of structure, finishes and services.	22. The contractor shall be responsible for the coordination of structure, finishes and services.	23. The contractor shall be responsible for the coordination of structure, finishes and services.	24. The contractor shall be responsible for the coordination of structure, finishes and services.	25. The contractor shall be responsible for the coordination of structure, finishes and services.	26. The contractor shall be responsible for the coordination of structure, finishes and services.	02	10/04/25	Draft Planning Issue	ED
13:10:44															

Project		Mixed Use Residential & Commercial Development at Kilbride, Arklow, Co. Wicklow		6-7 HARBOUR TERRACE, DUBLIN 2, IRELAND t +353-1-618 2400 f +353-1-618 7396 e architecture@bkd.ie www.bkd.ie	
Drawing Title		CHARACTER AREA 1B AND 1C - HOUSE TYPES D2			
Drawing No		6191-PP-204			
Scale	1:100@A1	Rev	02	Drawn	PMN, ED
		Date	10/04/25		



bkdarchitects
BURKE-KENNEDY DOYLE