




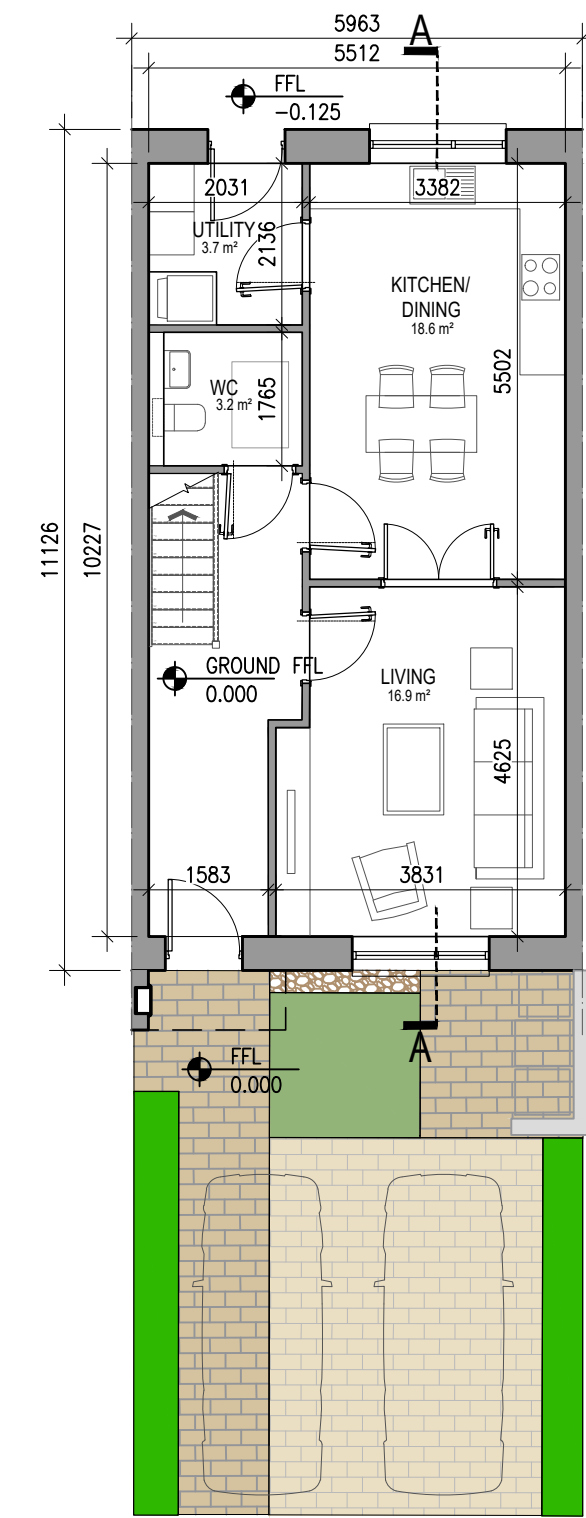


01 Type E1 - Ground Floor Plan
1:100@A1 3 BED HOUSE

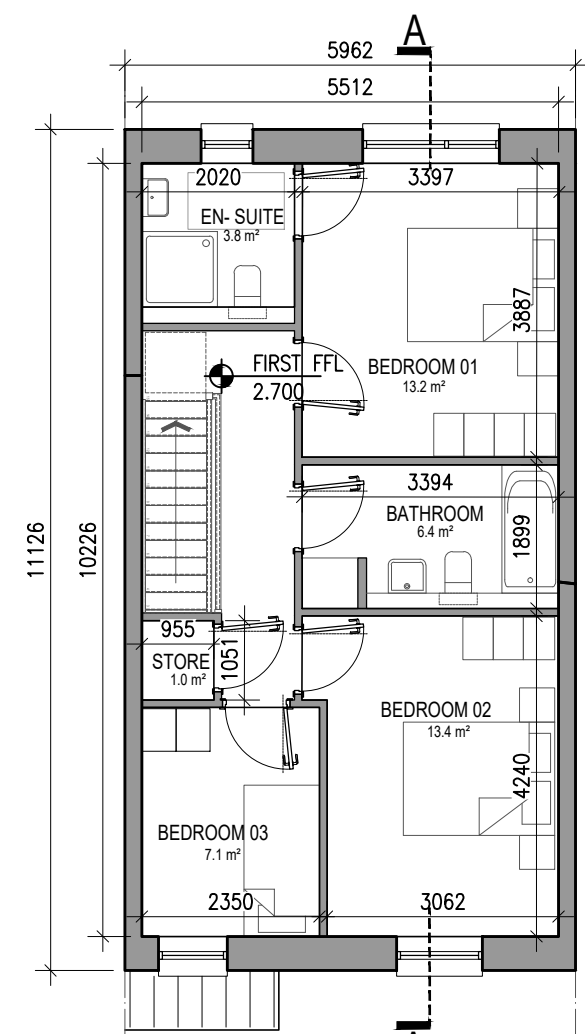


02 Type E1 - First Floor Plan
1:100@A1 3 BED HOUSE

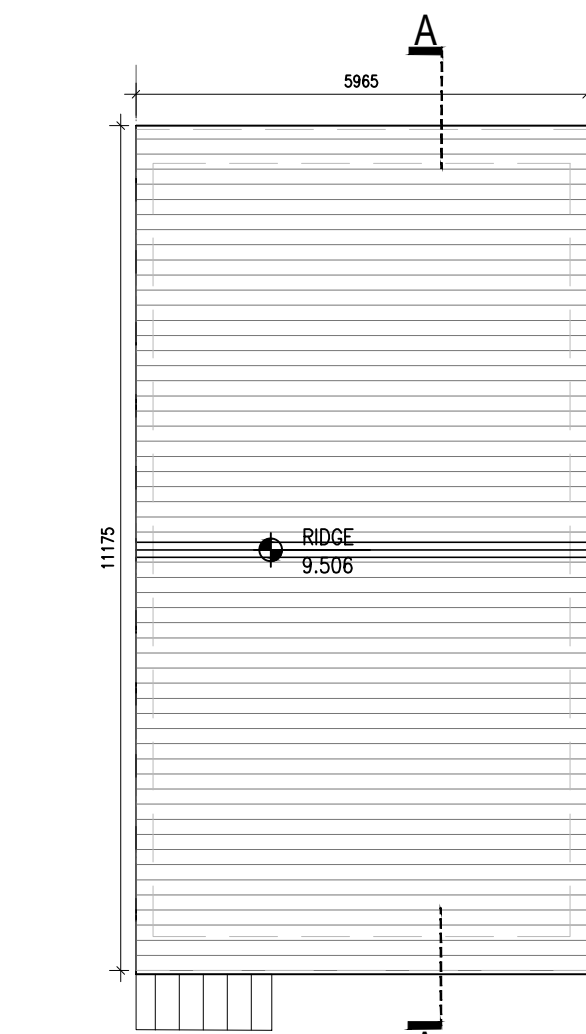


03 Type E1 - Roof Plan
1:100@A1 3 BED HOUSE

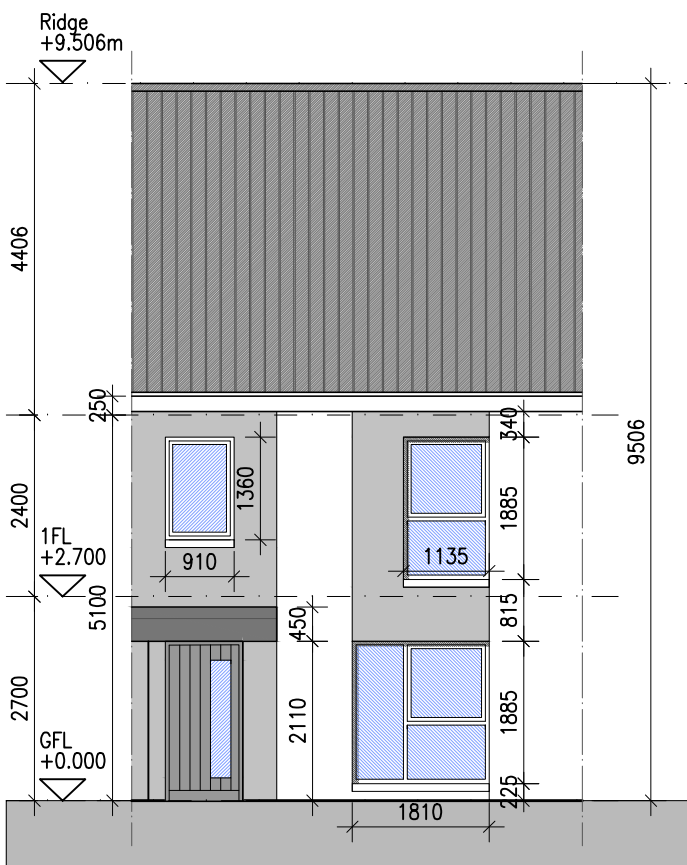


04 Type E1 - Front Elevation [Character Area 1B]
1:100@A1 3 BED HOUSE

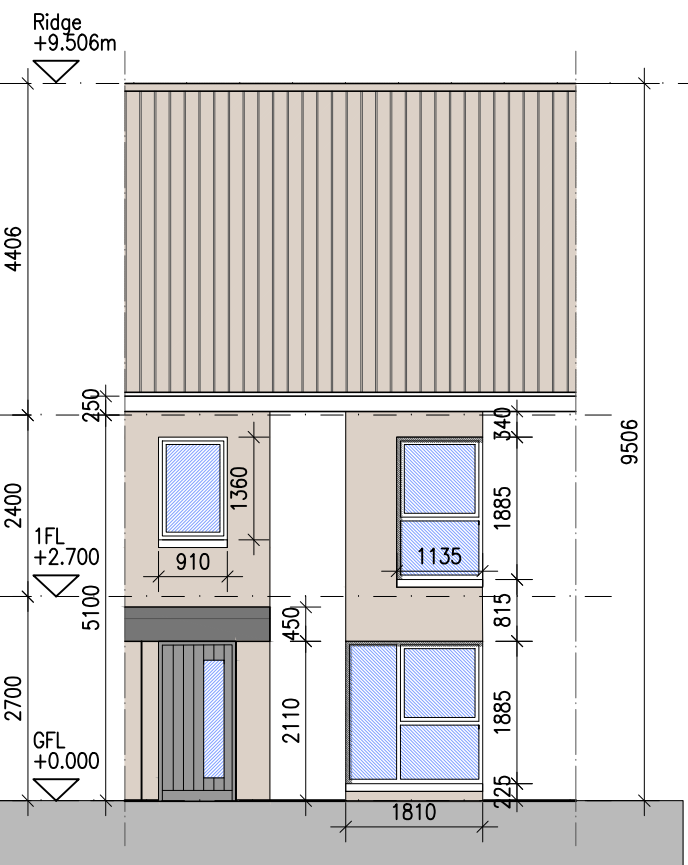

05 Type E1 - Front Elevation [Character Area 1C]
1:100@A1 3 BED HOUSE

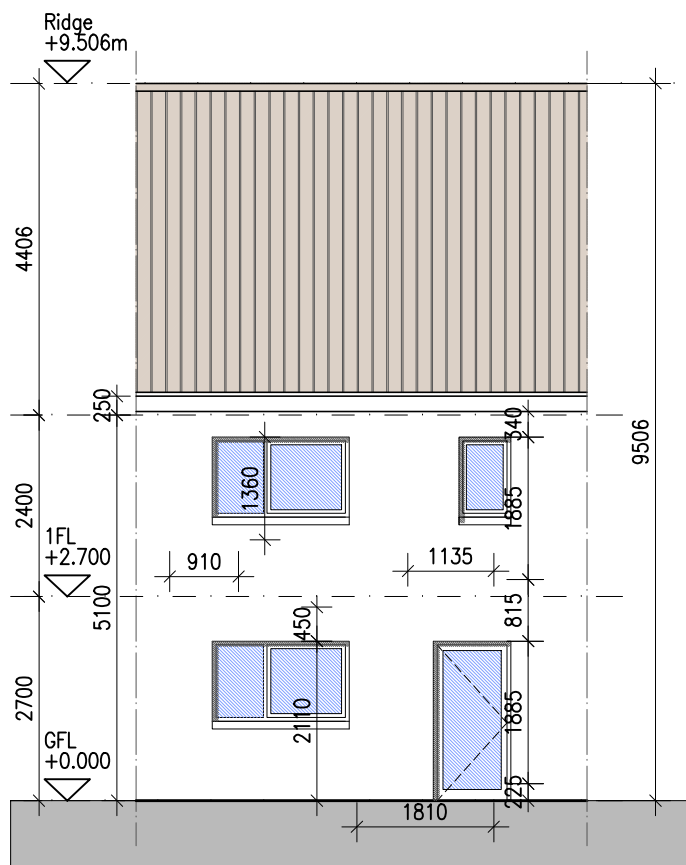


06 Type E1 - Rear Elevation
1:100@A1 3 BED HOUSE

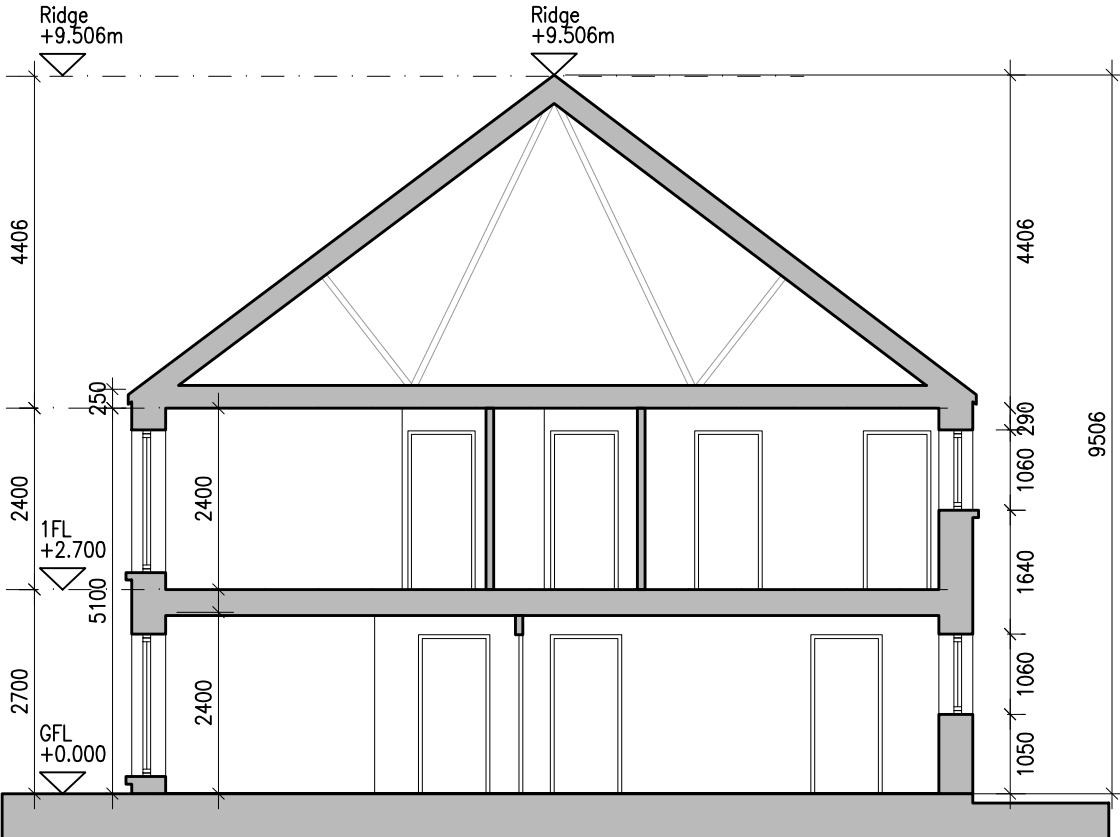

07 Type E1 - Section AA
1:100@A1 3 BED HOUSE

HOUSE TYPE E1	
Ground floor area	56.4m²
First floor area	56.4m²
Total Floor Area (3-bed unit):	112.8m²

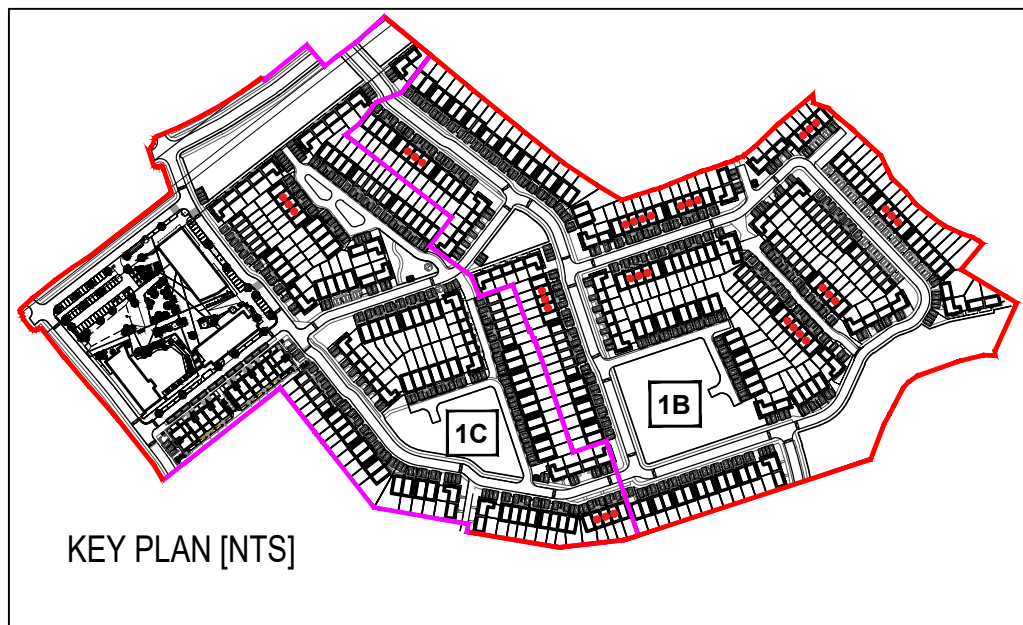

- Notes
1. Copyright Reserved
 2. Work to figure dimensions only. Do not scale drawing
 3. The contractor is responsible for checking all levels and dimensions on site and shall refer all discrepancies to the Architect
 4. Where appropriate, for details of r.c. structure, or mechanical and electrical details, see Engineers drawings
 5. Proprietary items shall be fixed in strict accordance with manufacturers instructions.
 6. Sizes of proprietary items shall be checked with manufacturer.
 7. The contractor shall be responsible for the coordination of structure, finishes and services.

Issue Status	
Progress	
Planning Application	
Fire Cert	
Disability Cert	
Tender	
Construction	
As Built	

Information Only 5_206 (E1 - E2) dwg 14/05/2025

No.	Date	Revision	Initials
01	10/03/25	Draft Planning Issue	PMN
02	10/04/25	Draft Planning Issue	ED

Project **Mixed Use Residential & Commercial Development at Kilbride, Arklow, Co. Wicklow**

Drawing Title CHARACTER AREA 1B AND 1C - HOUSE TYPE E1

Drawing No 6191-PP-205

Scale 1:100@A1 Rev 02 Drawn PMN, ED Date 10/04/25

6-7 HARDOURT TERRACE, DUBLIN 2, IRELAND

T +353-1-618 2400 F +353-1-676 7396

www.bkd.ie

bkdarchitects
BURKE-KENNEDY DOYLE