




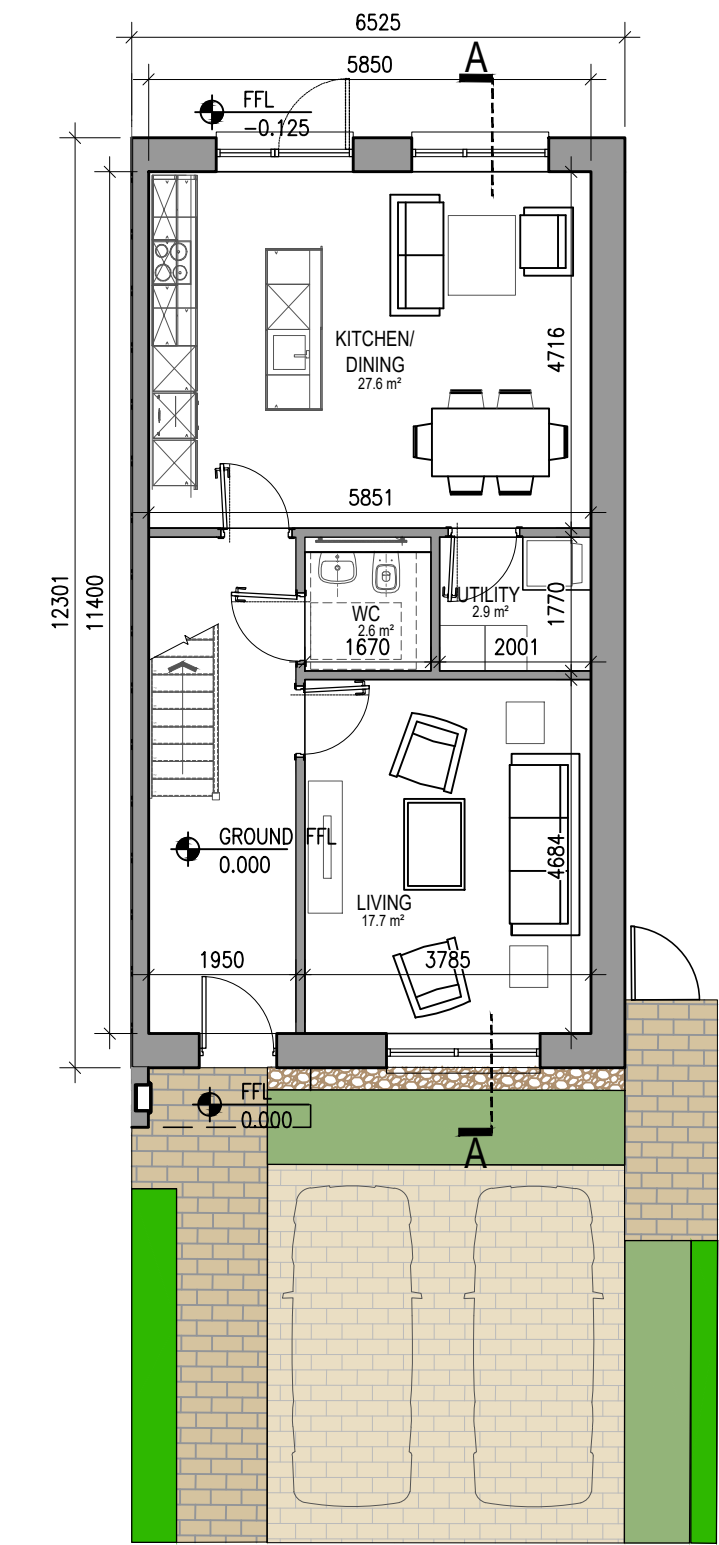

01 Type H2 - Ground Floor Plan
1:100@A1 4 BED HOUSE

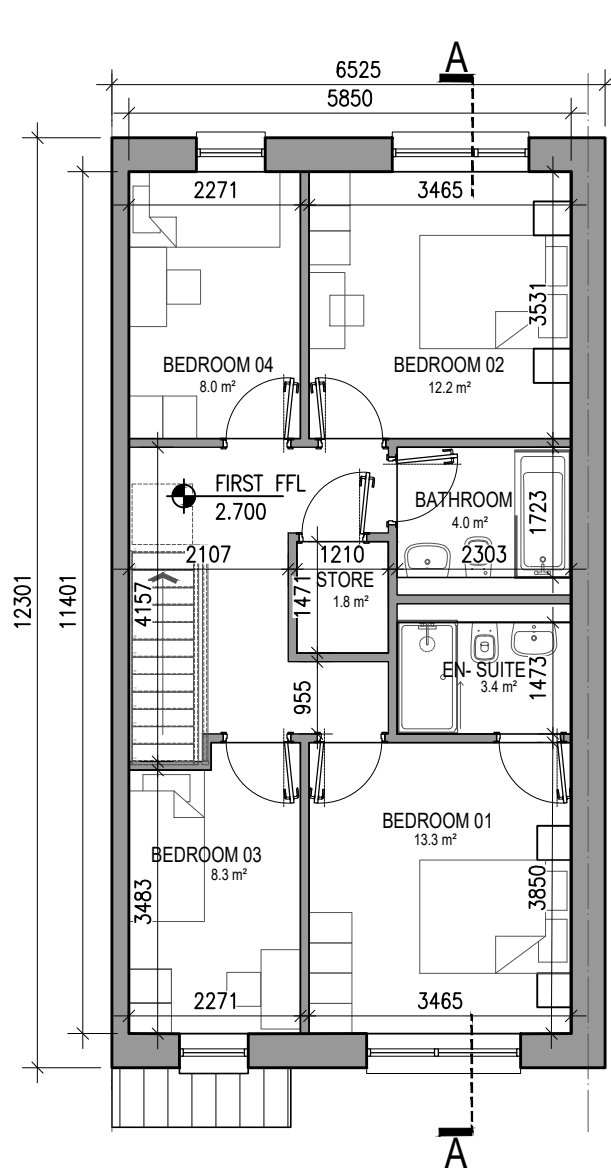


02 Type H2 - First Floor Plan
1:100@A1 4 BED HOUSE

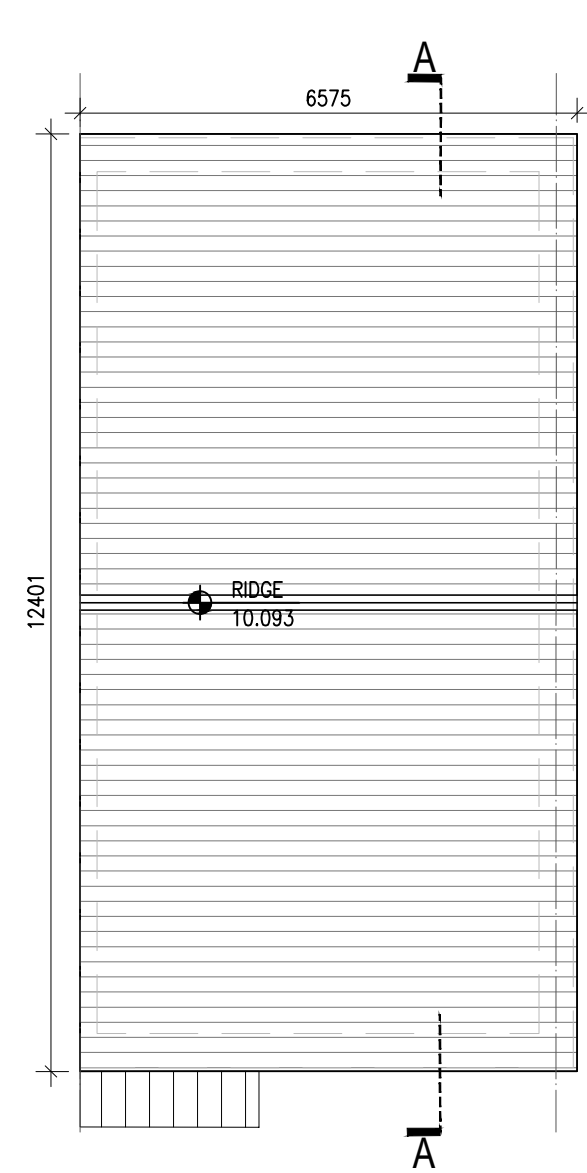

03 Type H2 - Roof Plan
1:100@A1 4 BED HOUSE

HOUSE TYPE H2
Ground floor area 66.7m²
First floor area 66.7m²
Total Floor Area (4-bed unit): 133.4m²

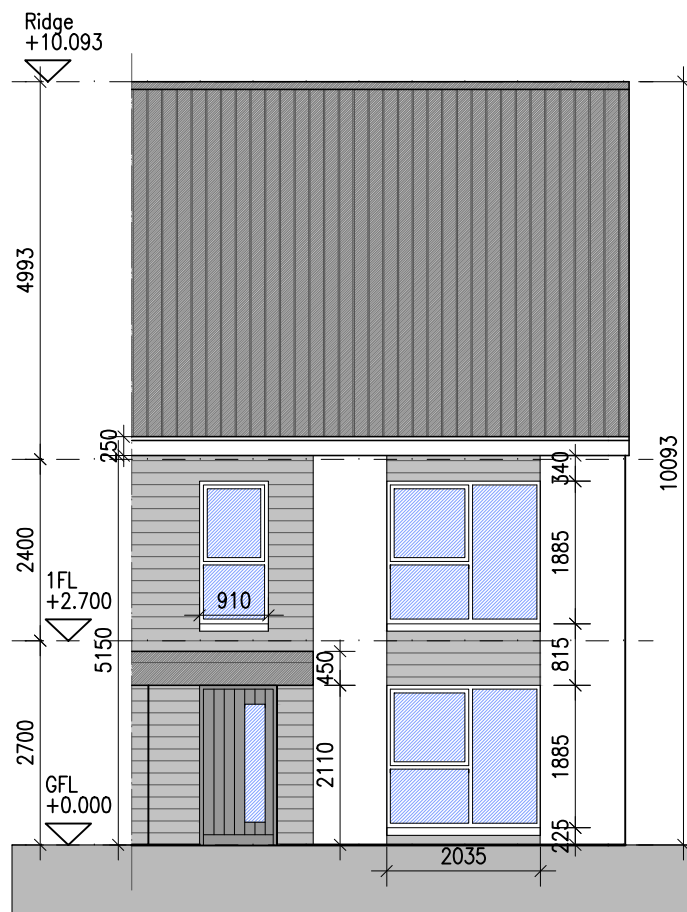


04 Type H2 - Front Elevation [Character Area 1B_V1]
1:100@A1 4 BED HOUSE




05 Type H2 - Front Elevation [Character Area 1B_V2]
1:100@A1 4 BED HOUSE




06 Type H2 - Front Elevation [Character Area 1C_V1]
1:100@A1 4 BED HOUSE

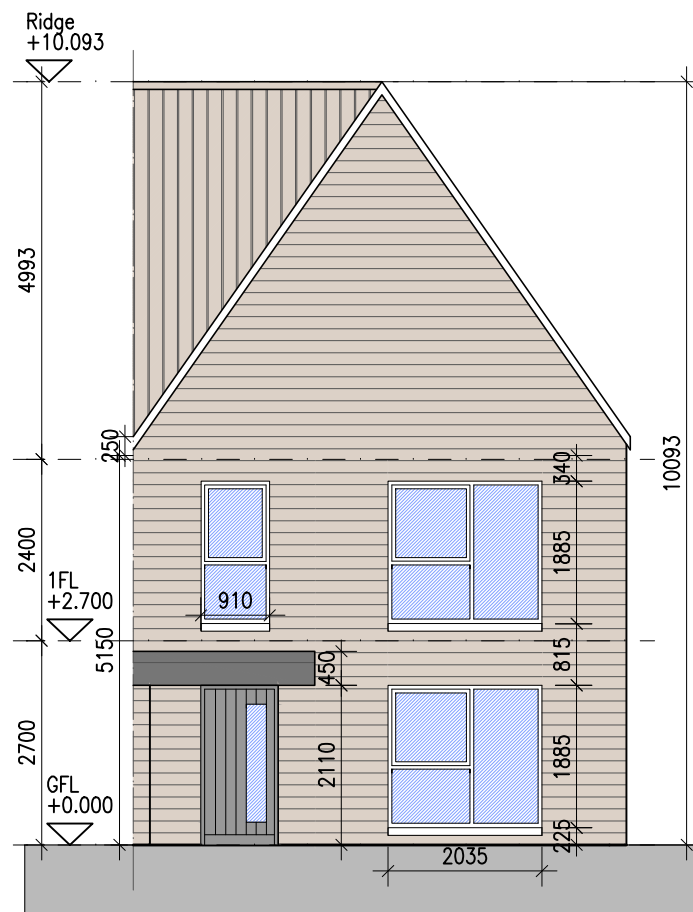


07 Type H2 - Front Elevation [Character Area 1C_V2]
1:100@A1 4 BED HOUSE

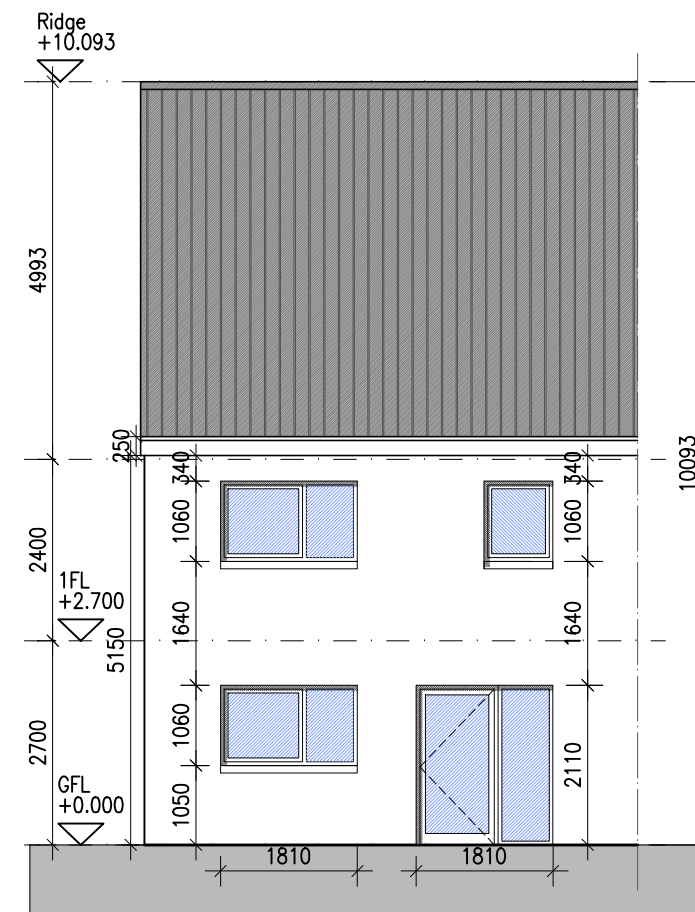


08 Type H2 - Rear Elevation [V1]
1:100@A1 4 BED HOUSE

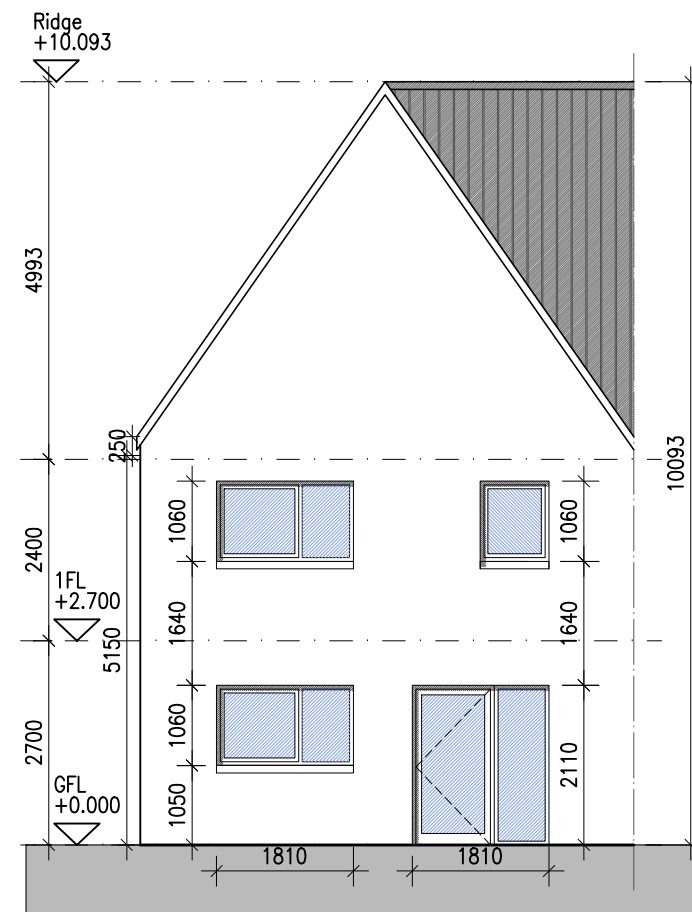


09 Type H2 - Rear Elevation [V2]
1:100@A1 4 BED HOUSE

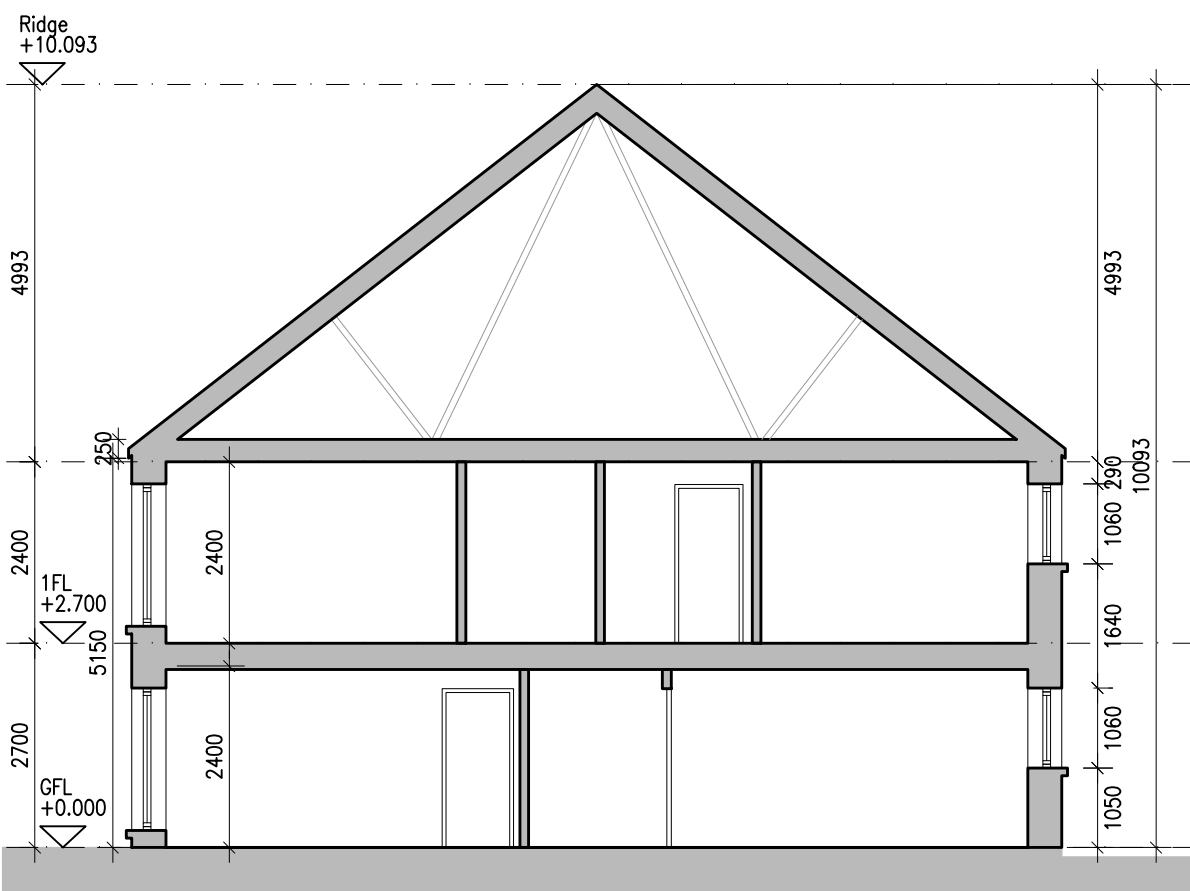


10 Type H2 - Section AA
1:100@A1 4 BED HOUSE

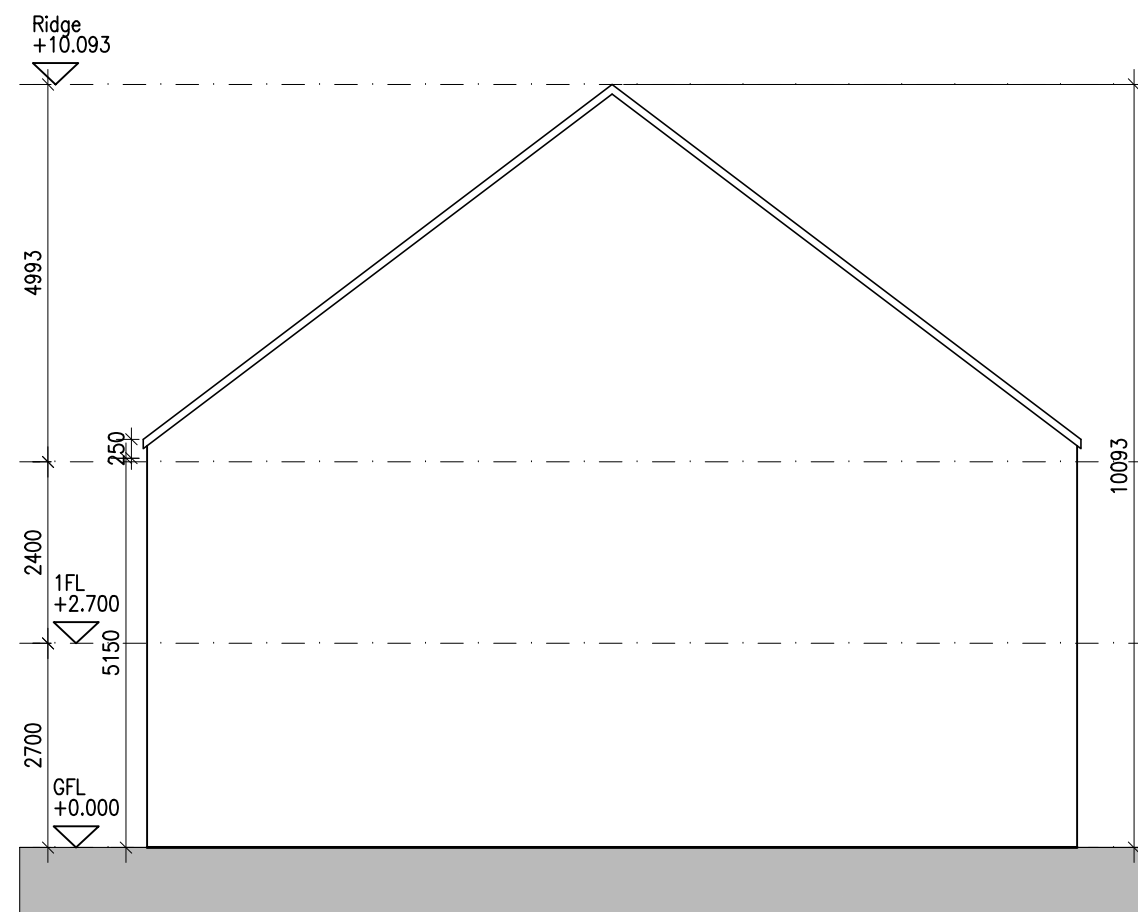

11 Type H2 - Side Elevation [V1]
1:100@A1 4 BED HOUSE

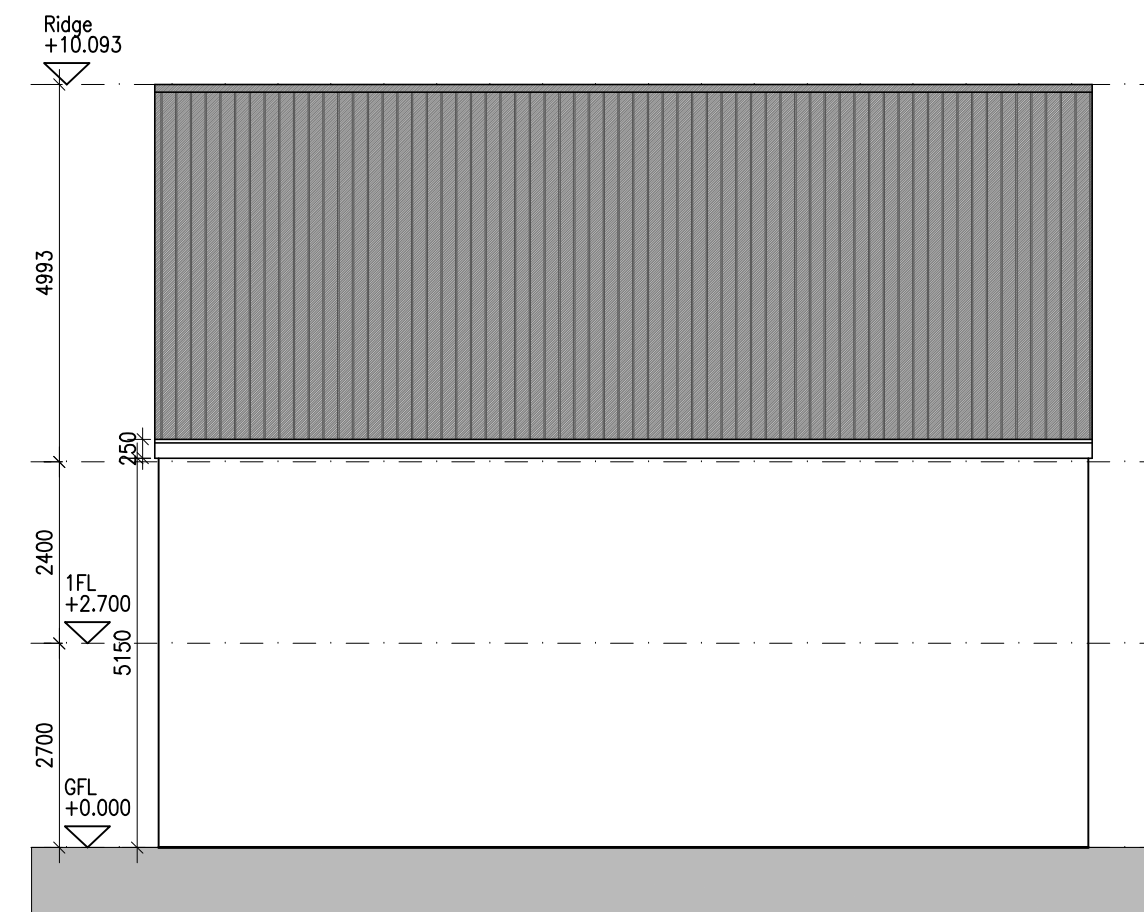

12 Type H2 - Side Elevation [V2]
1:100@A1 4 BED HOUSE

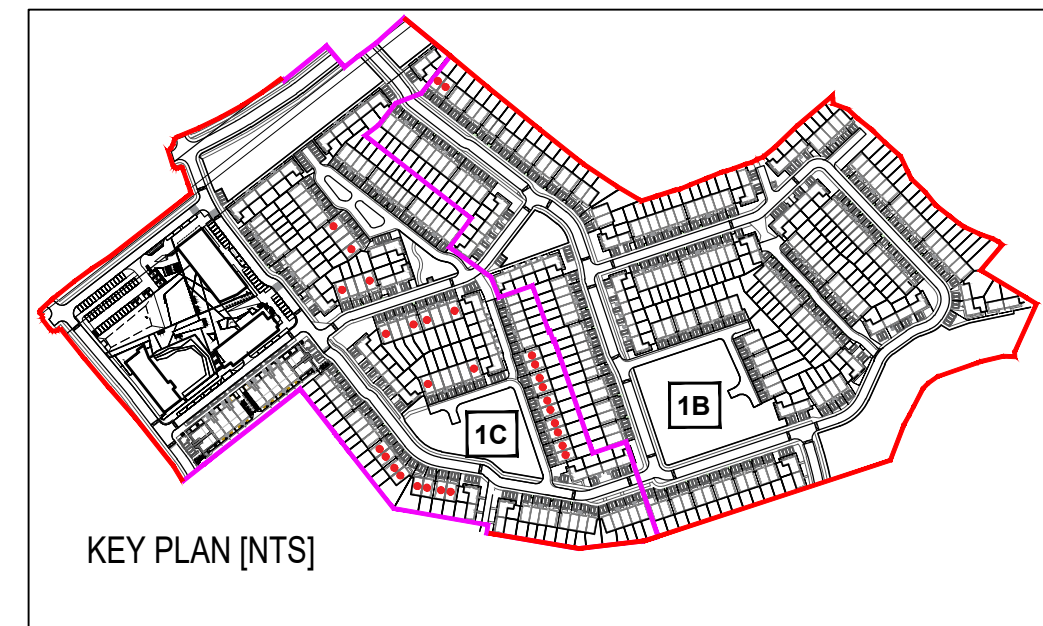

Notes	Issue Status
1. Copyright Reserved	Progress
2. Work to figure dimensions only. Do not scale drawing	Planning Application
3. The contractor is responsible for checking all levels and dimensions on site and shall refer all discrepancies to the Architect	Fire Cert
4. Where appropriate, for details of r.c. structure, or mechanical and electrical details, see Engineers drawings	Disability Cert
5. Proprietary items shall be fixed in strict accordance with manufacturers instructions.	Tender
6. Sizes of proprietary items shall be checked with manufacturer.	Construction
7. The contractor shall be responsible for the coordination of structure, finishes and services	As Built
8. The contractor shall be responsible for the coordination of structure, finishes and services	Information Only

12/59/52

No.	Date	Revision	Initials
01	15/05/25	Planning Issue	ED

Project	Mixed Use Residential & Commercial Development at Kilbride, Arklow, Co. Wicklow				6-7 HARDCOURT TERRACE, DUBLIN 2, IRELAND t +353-1-818 2400 f +353-1-876 7396 a architecture@bkd.ie www.bkd.ie	
Drawing Title	CHARACTER AREA 1B AND 1C - HOUSE TYPE H2				 BURKE-KENNEDY DOYLE	
Drawing No	6191-PP-210					
Scale	1:100@A1					
Rev	01	Drawn	PMN, ED	Date	15/05/25	