

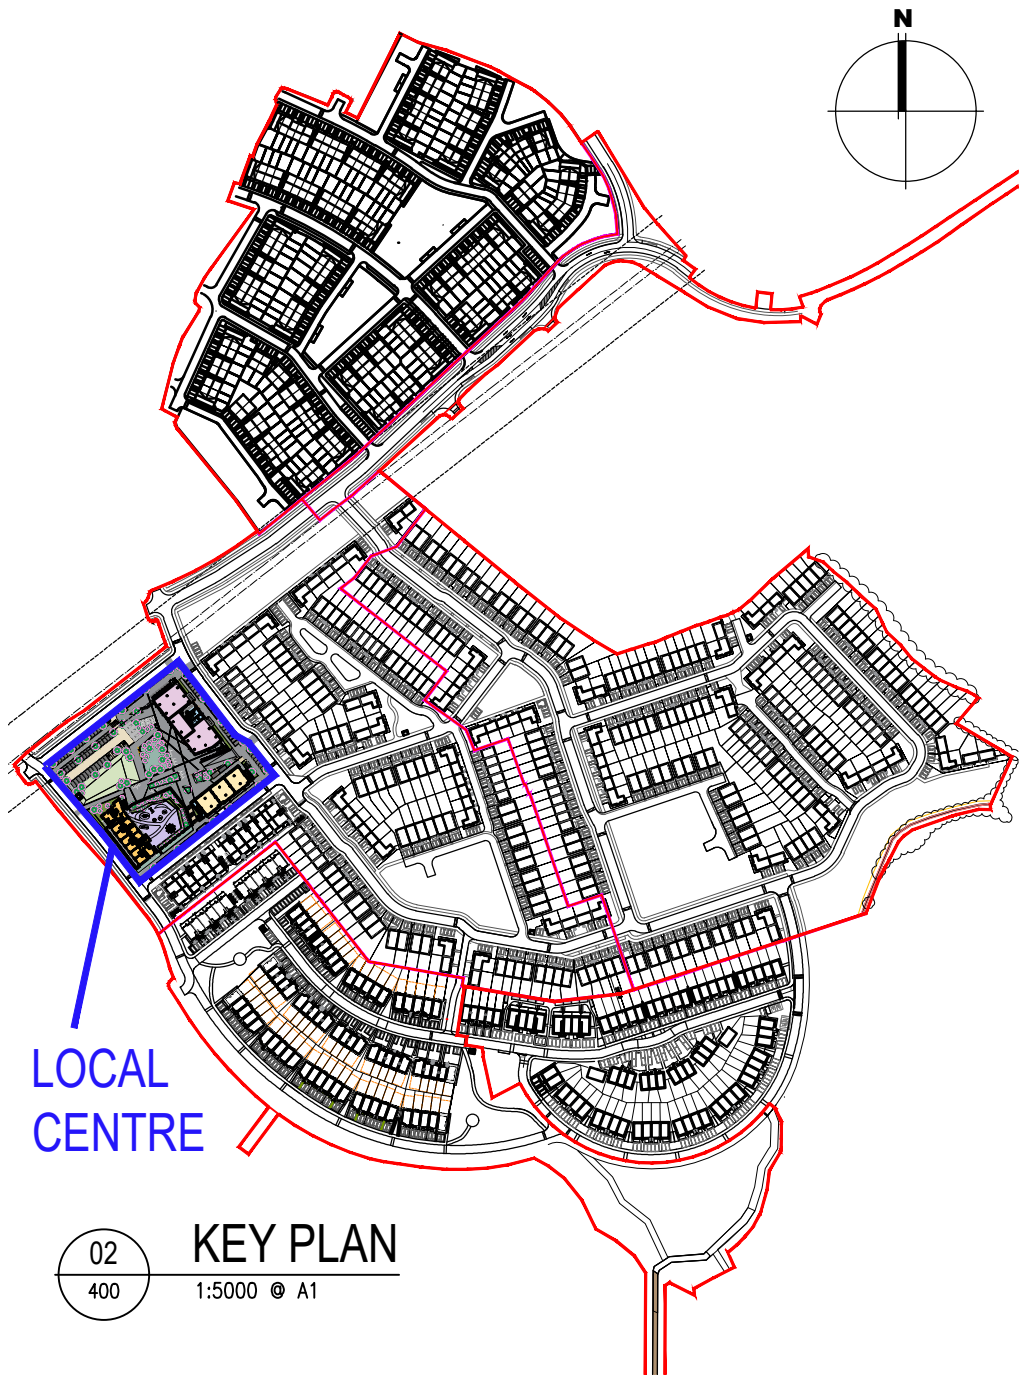


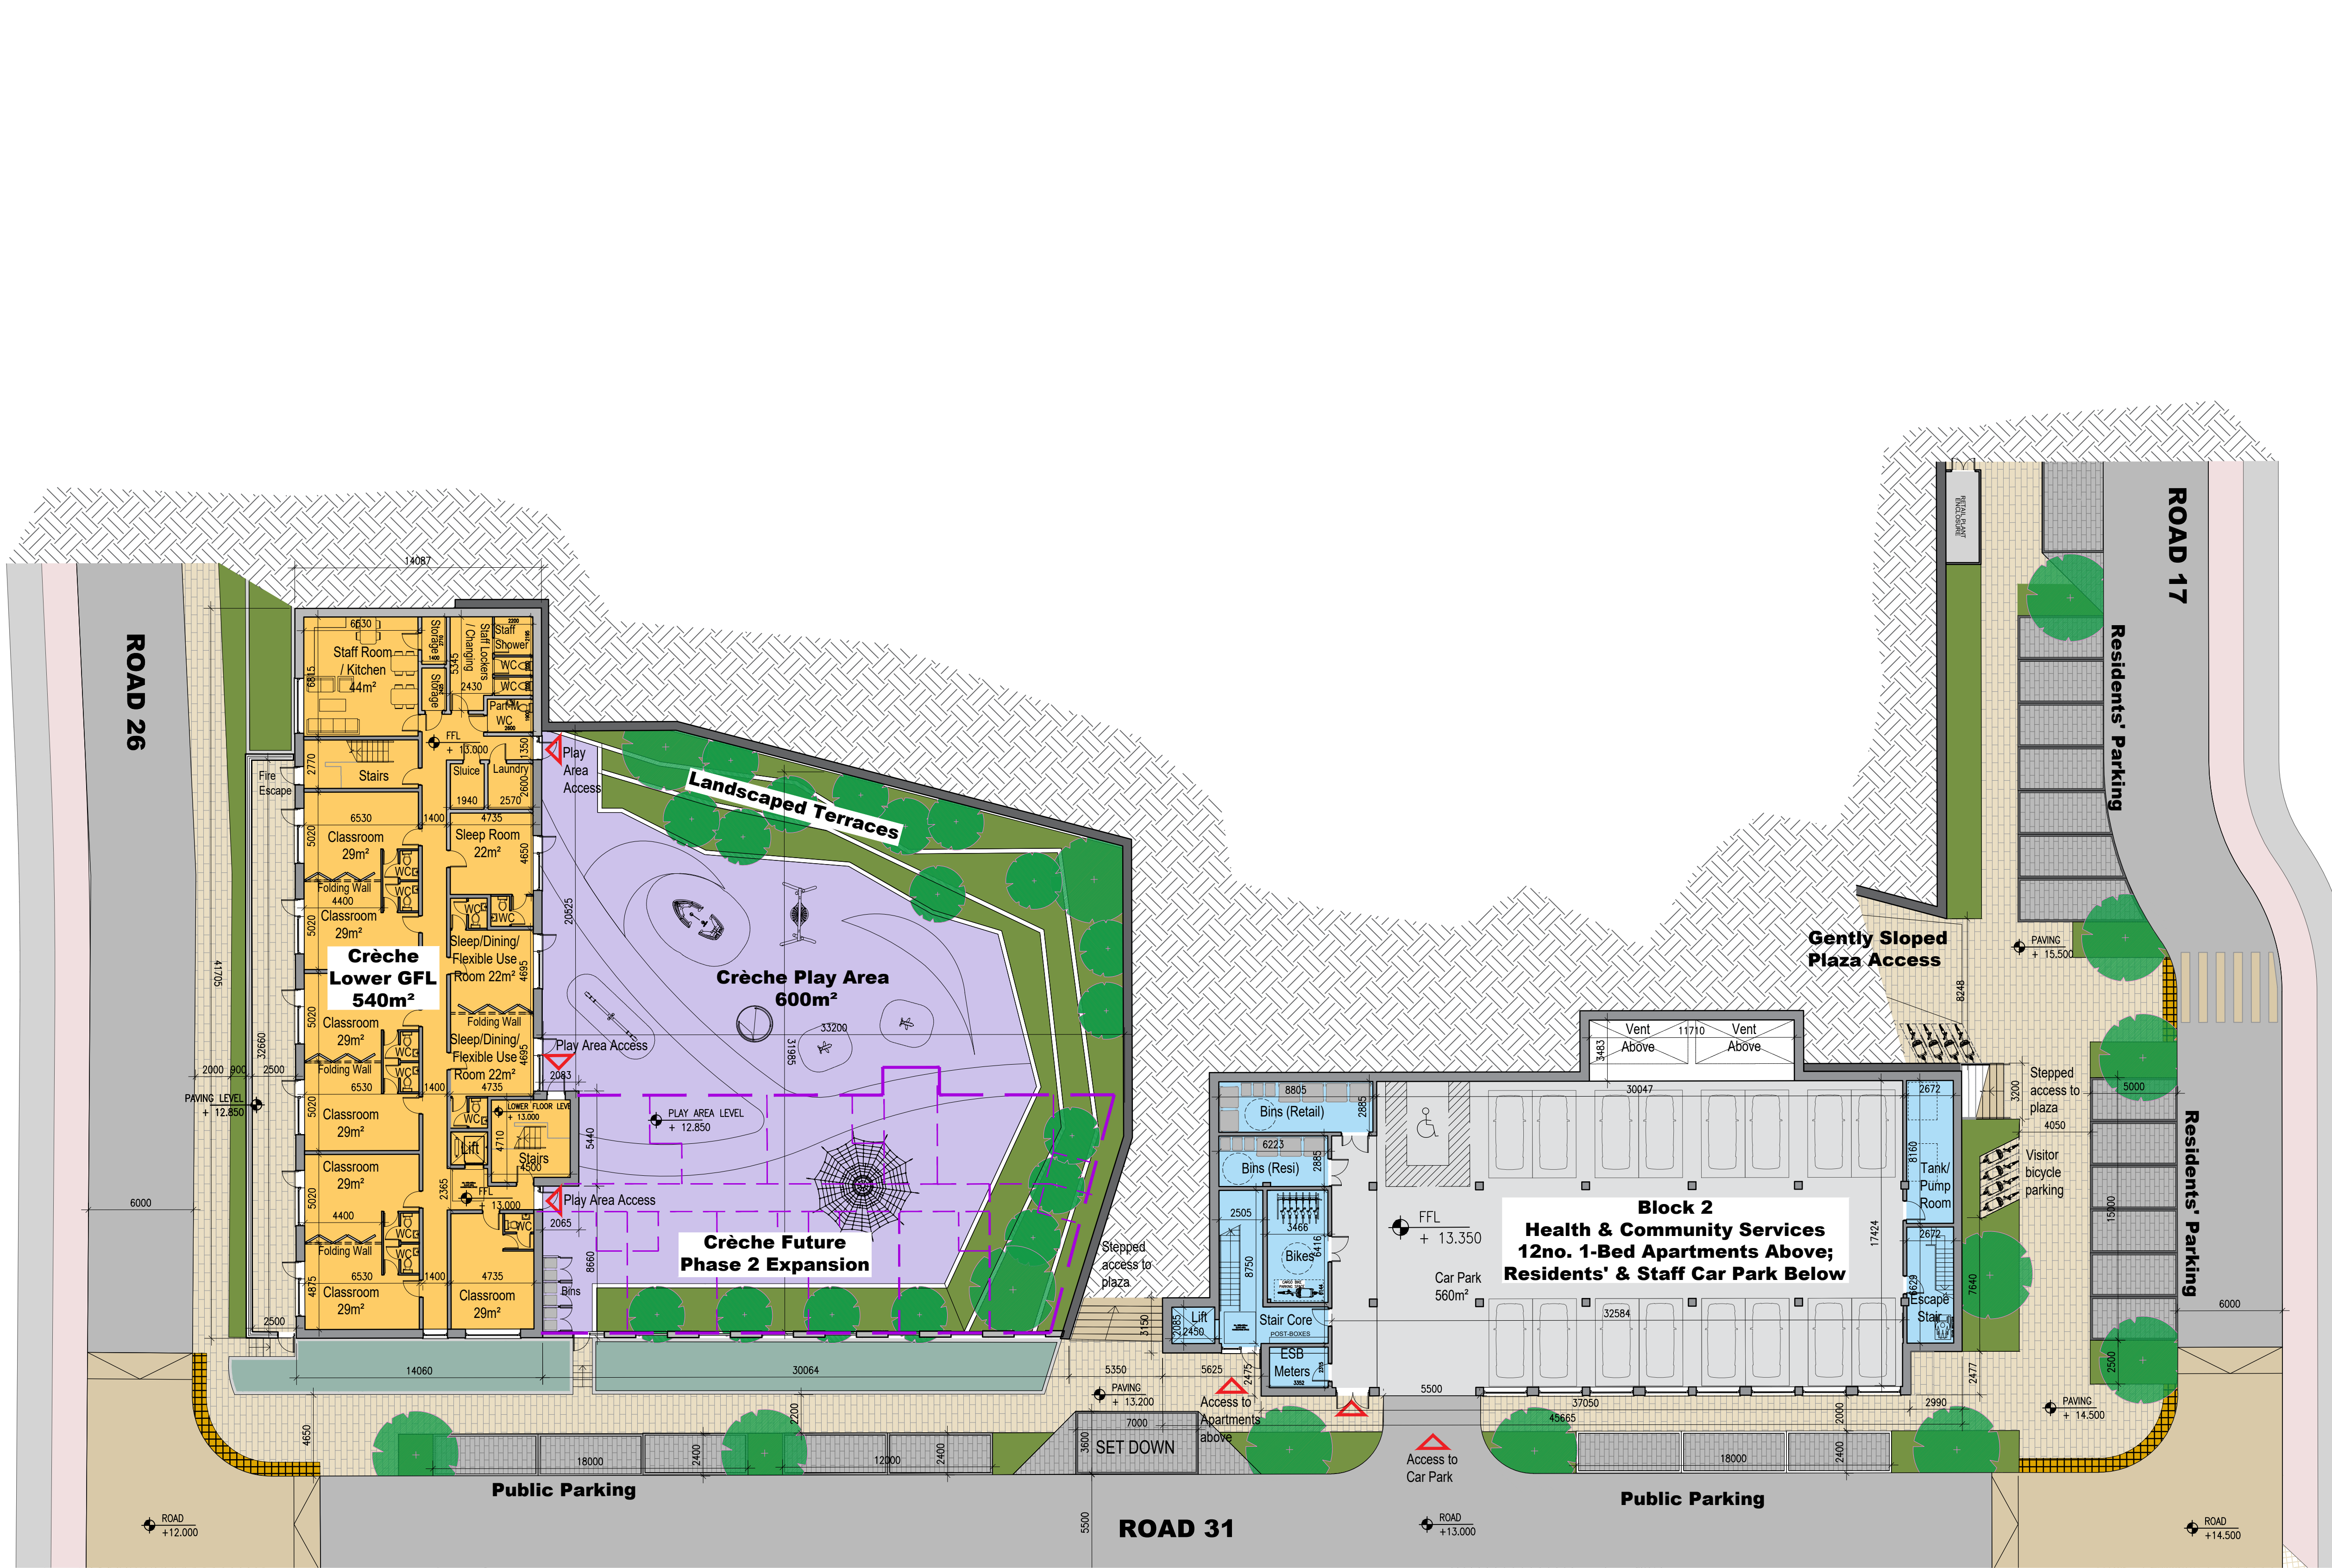

02
400
KEY PLAN
1:5000 @ A1

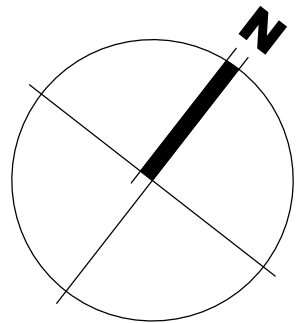

0m 5m 10m 15m 20m 25m

01
400
LOCAL CENTRE - LOWER GROUND FLOOR PLAN
1:200 @ A1

- Notes
1. Copyright Reserved
 2. Work to figured dimensions only. Do not scale drawing
 3. The contractor is responsible for checking all levels and dimensions on site and shall refer all discrepancies to the Architect
 4. Where appropriate, for details of r.c. structure, or mechanical and electrical details, see Engineers drawings
 5. Proprietary items shall be fixed in strict accordance with manufacturers instructions.
 6. Sizes of proprietary items shall be checked with manufacturer.
 7. The contractor shall be responsible for the coordination of structure, finishes and services.

Issue Status

Progress	Planning Application	■
Fire Cert		
Disability Cert		
Tender		
Construction		
As Built		
Information Only		

No.	Date	Revision	Initials
01	27/03/25	Draft Planning Issue	ED
02	16/04/25	Draft Planning Issue	ED
03	12/05/25	Draft Planning Issue	ED

Project
**Mixed Use Residential & Commercial Development
at Kilbride, Arklow, Co. Wicklow**

Drawing Title
LOCAL CENTRE - LOWER GROUND FLOOR PLAN

Drawing No
6191-PP-400

Scale
1:200@A1

Rev
02

Drawn
ED

Date
12/05/25

6-7 HARDOURT TERRACE, DUBLIN 2, IRELAND
t +353 1 618 2400 f +353 1 676 7396
a architecture@bkd.ie
www.bkd.ie

bkdarchitects
BURKE-KENNEDY DOYLE