
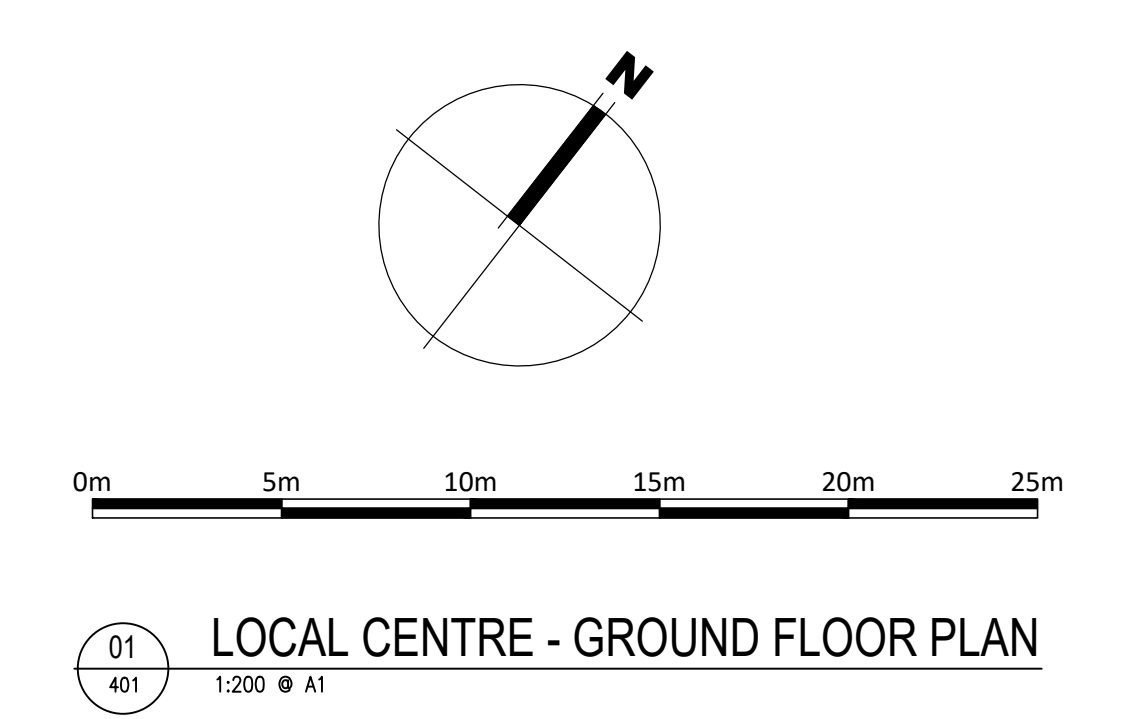
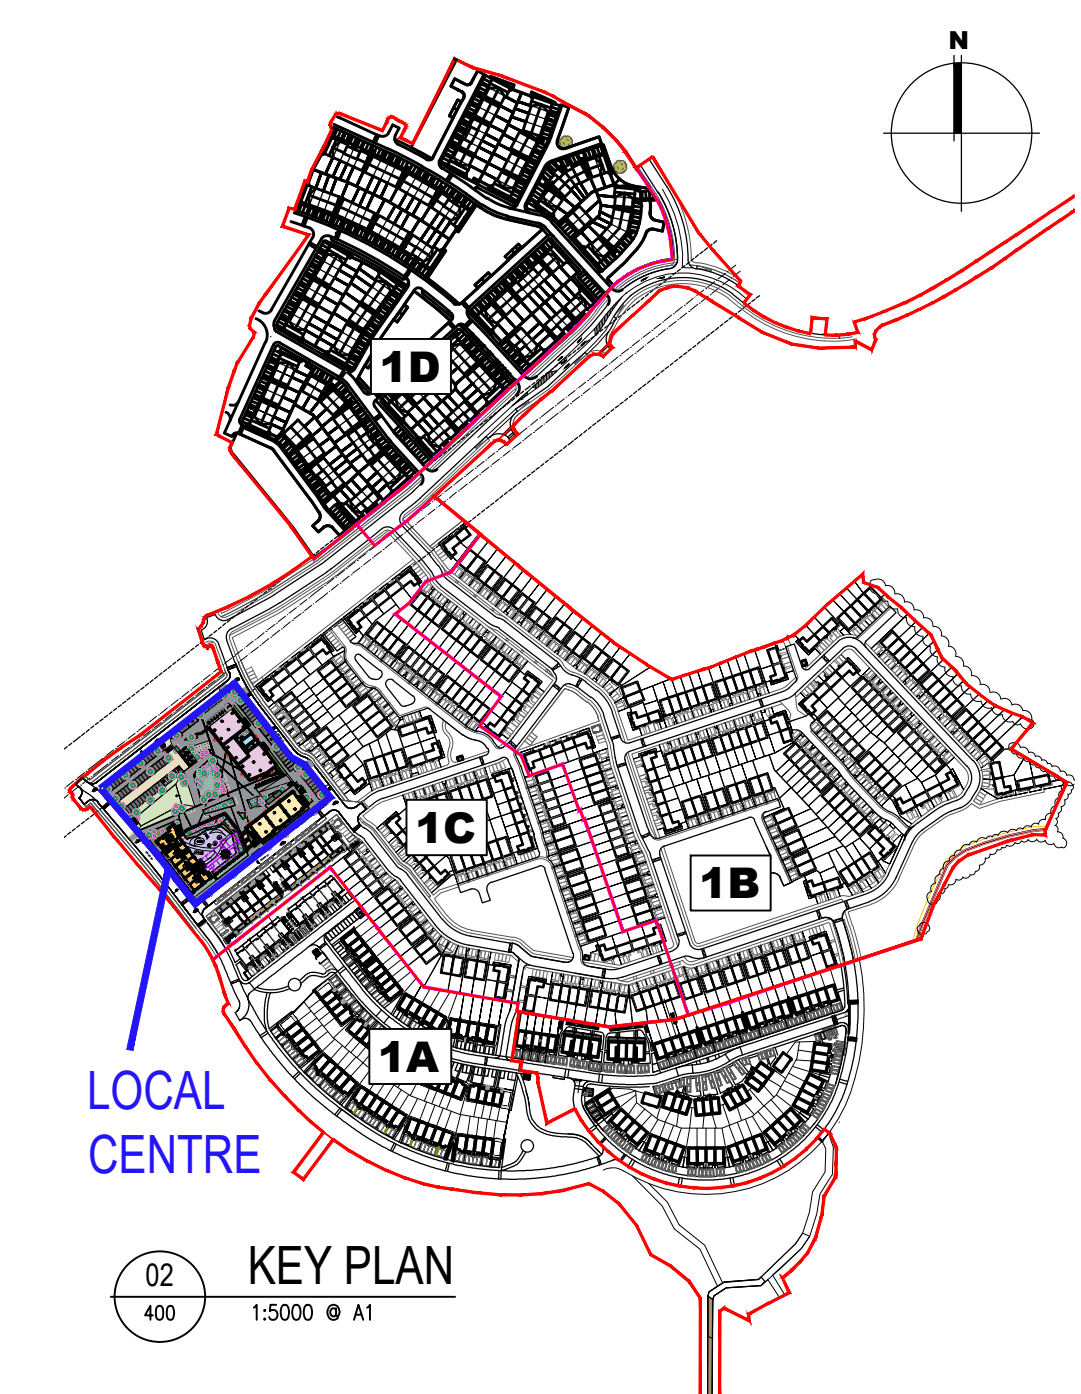


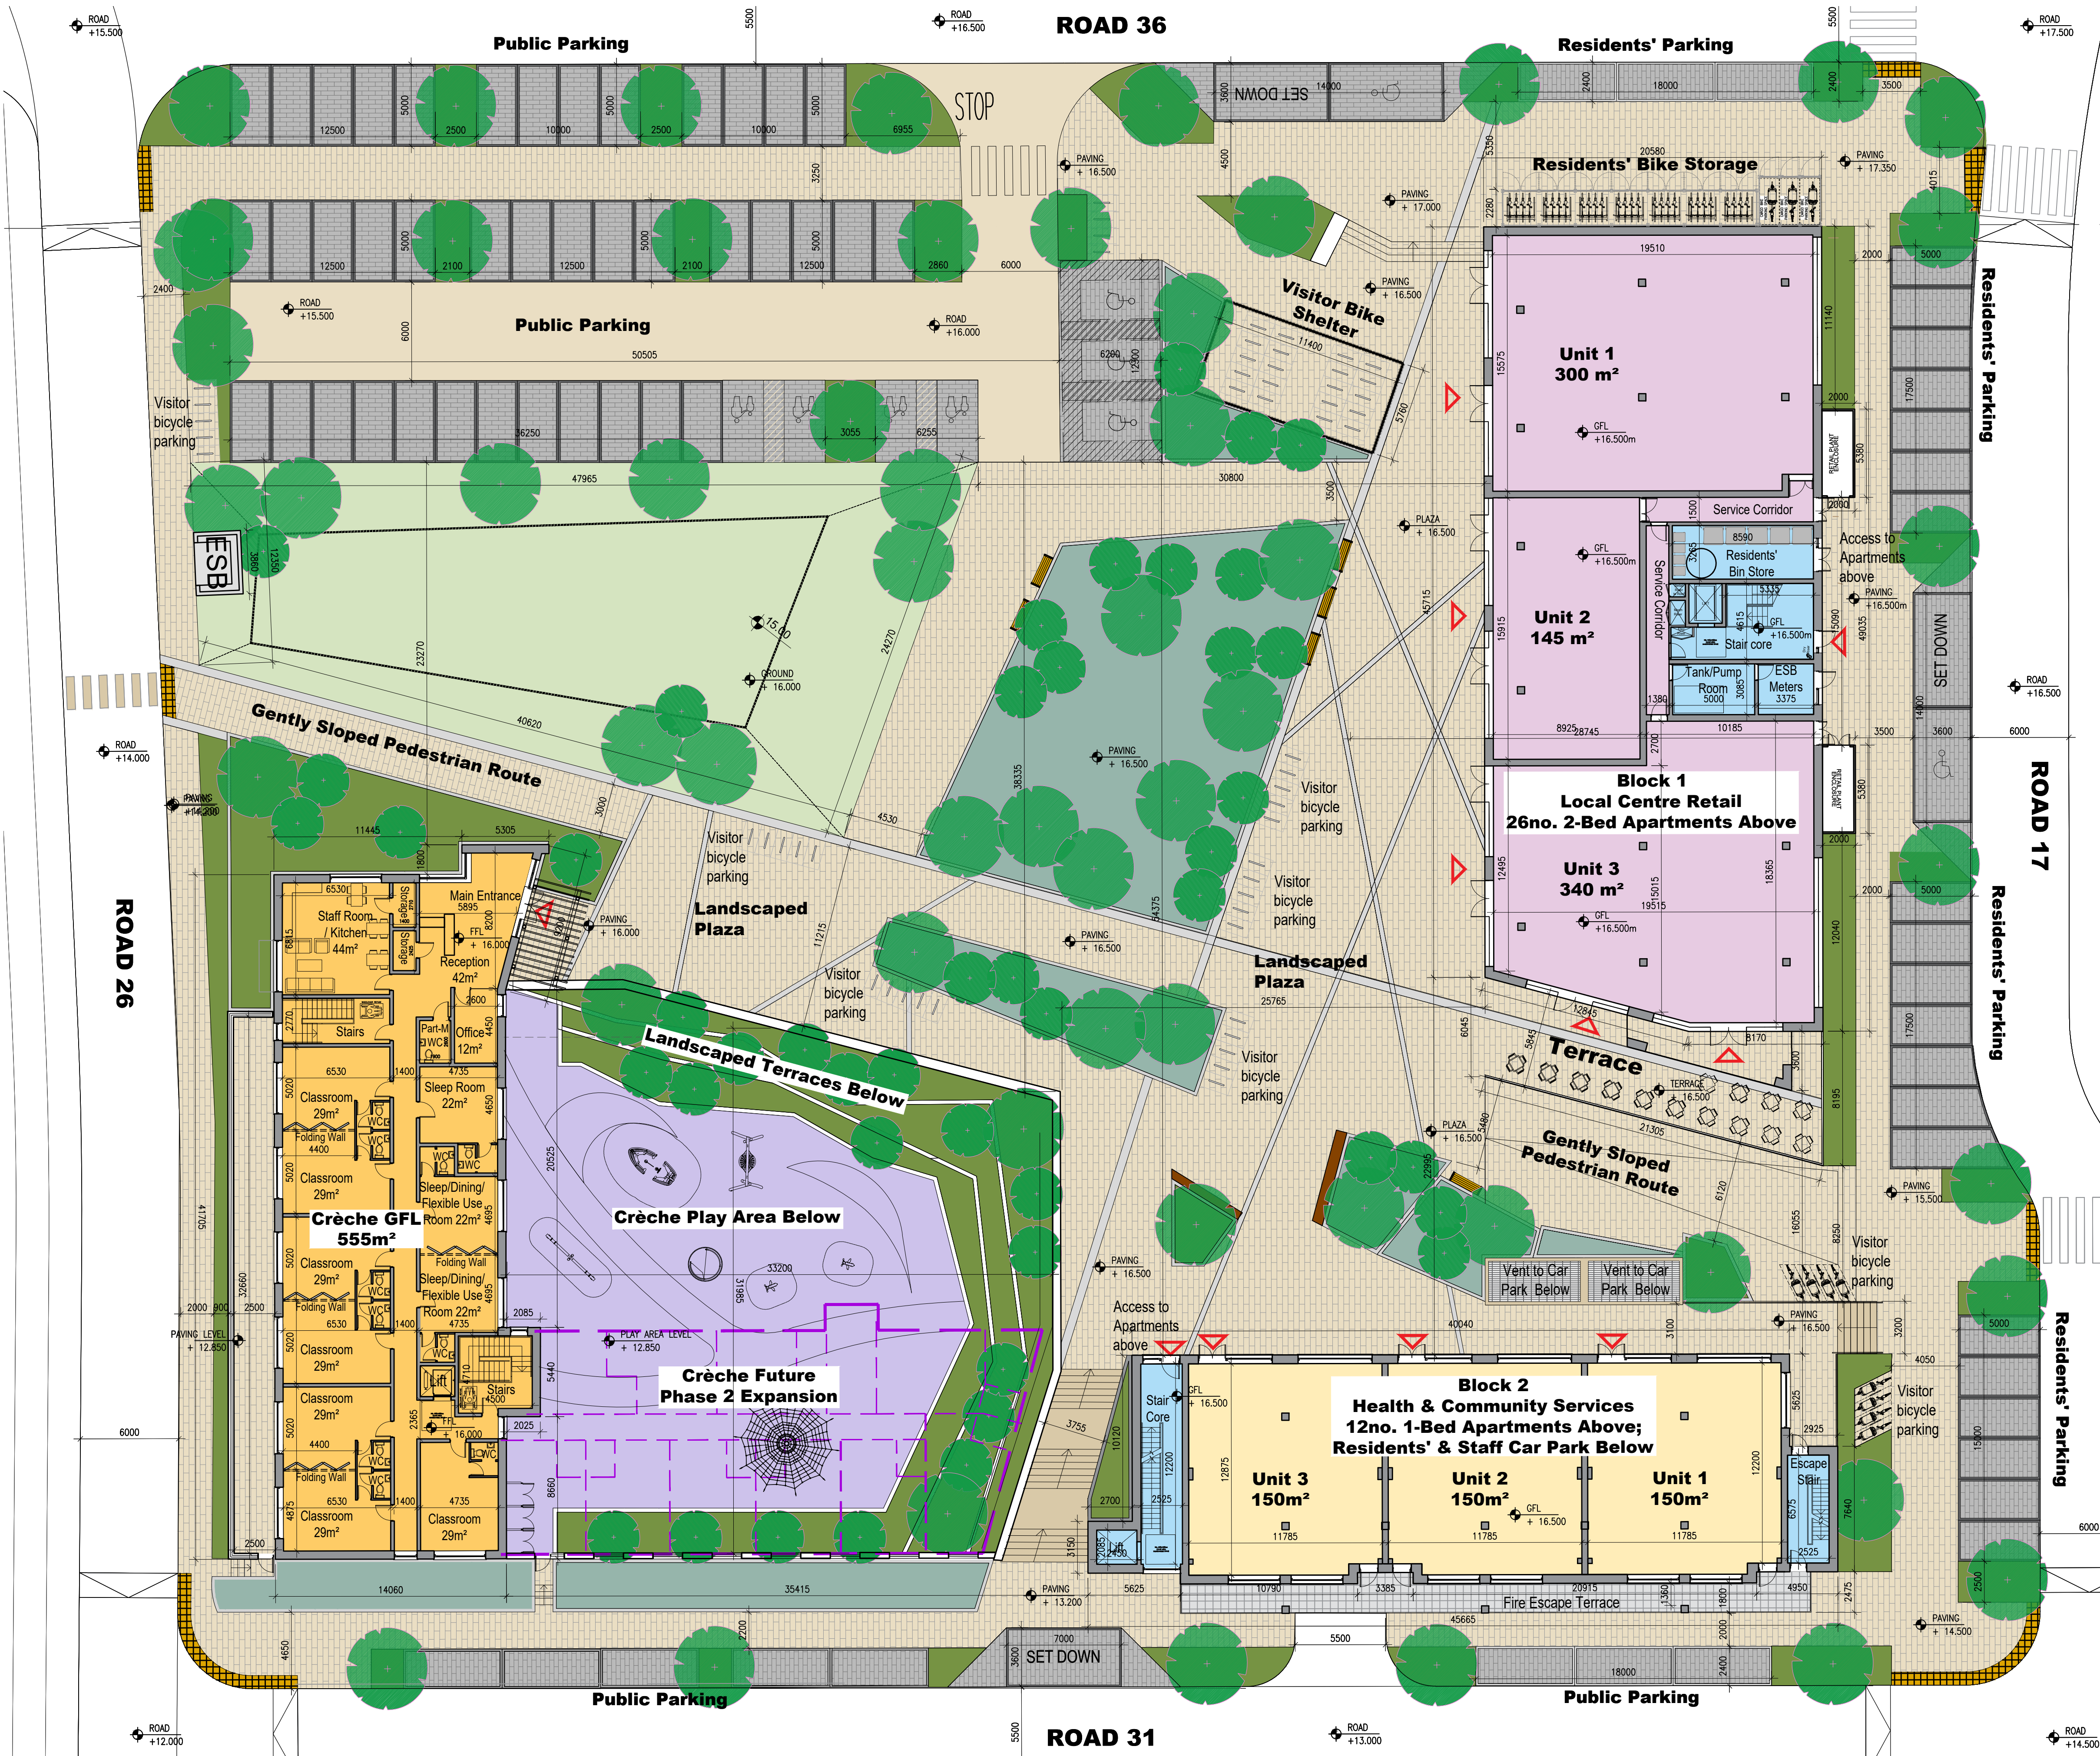

Notes		Issue Status		No.		Date		Revision		Initials	
1. Copyright Reserved		Progress		01		16/05/25		Planning Issue		ED	
2. Work to figured dimensions only. Do not scale drawing.		Planning Application									
3. The contractor is responsible for checking all levels and dimensions on site and shall refer all discrepancies to the Architect		Fire Cert									
4. Where appropriate, for details of r.c. structure, or mechanical and electrical details, see Engineers drawings		Disability Cert									
5. Proprietary items shall be fixed in strict accordance with manufacturers instructions.		Tender									
6. Sizes of proprietary items shall be checked with manufacturer.		Construction									
7. The contractor shall be responsible for the coordination of structure, finishes and services.		As Built									
		Information Only									

Project

Mixed Use Residential & Commercial Development at Kilbride, Arklow, Co. Wicklow

Drawing Title

LOCAL CENTRE - GROUND FLOOR PLAN

Drawing No

6191-PP-401

Scale

1:200 @ A1

Rev

01

Drawn

ED

Date

16/05/25

www.bkd.ie

bkdarchitects

BURKE-KENNEDY DOYLE

6-Z HARBOURTY TERRACE, DUBLIN 9, IRELAND

T: +353-1-619 2940 F: +353-1-619 2985

e:architects@bkd.ie