



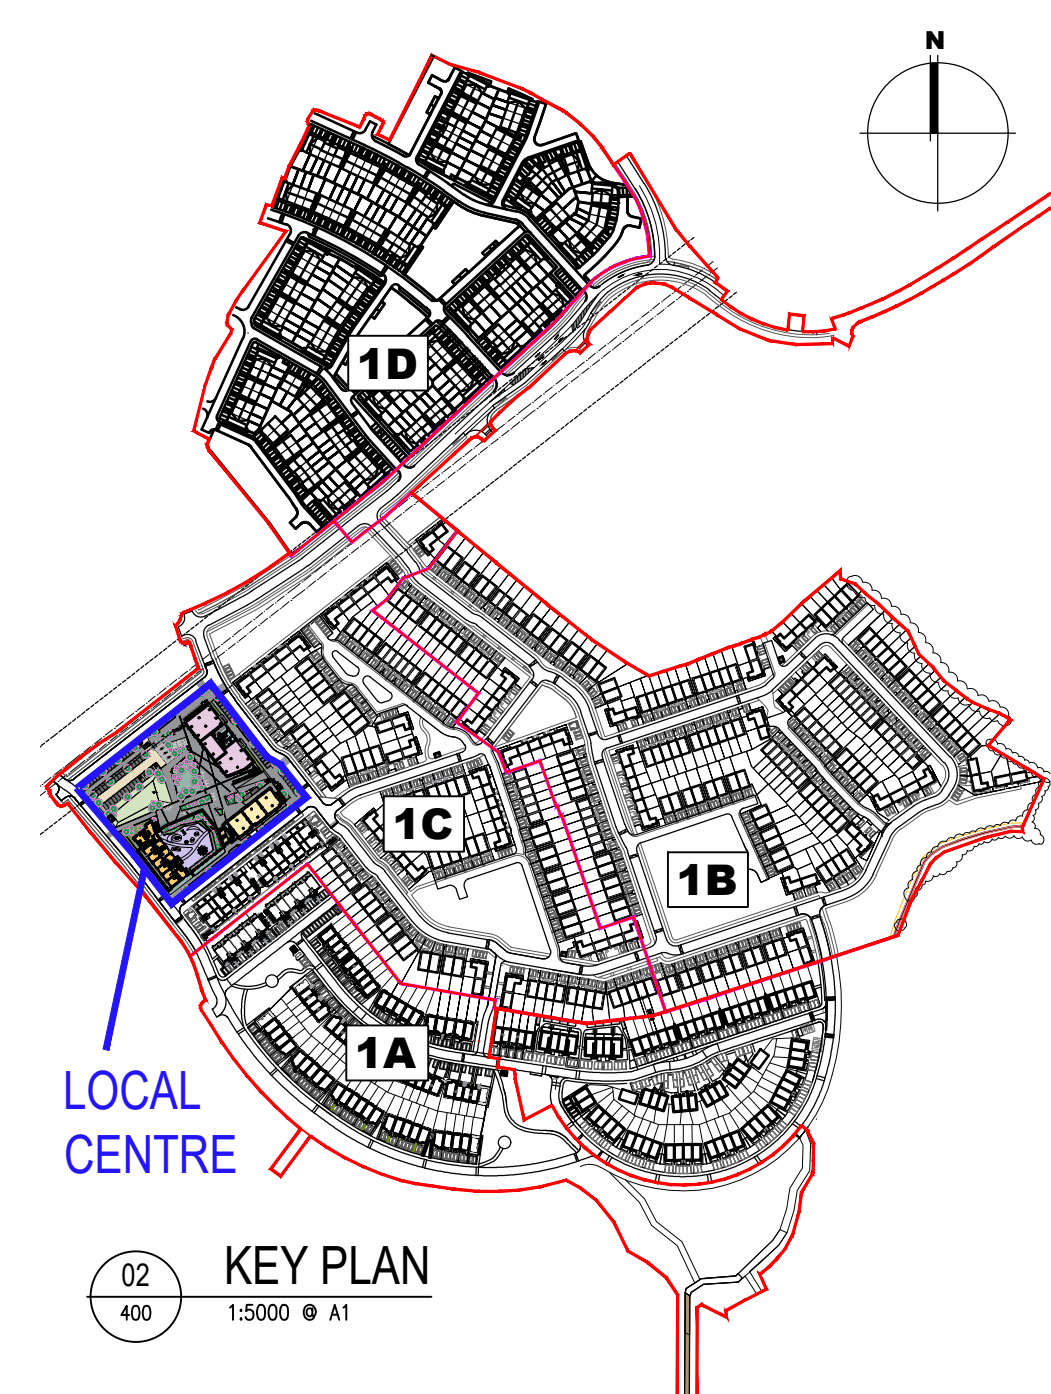

02
400

KEY PLAN
1:5000 @ A1

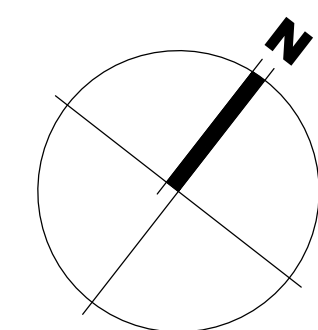

0m	5m	10m	15m	20m	25m
----	----	-----	-----	-----	-----

01 LOCAL CENTRE - FIRST FLOOR PLAN
402 1:200 @ A1

Notes		Issue Status				No. Date		Revision		Initials		Project Mixed Use Residential & Commercial Development at Kilbride, Arklow, Co. Wicklow 6-7 HARDICUT TERRACE, DUBLIN 8, IRELAND T: +353 1 618 2940 F: +353 1 618 2946 e: architecture@bkd.ie www.bkd.ie Drawing Title LOCAL CENTRE - FIRST FLOOR PLAN Drawing No 6191-PP-402 Scale 1:200 @ A1 Rev 01 Drawn ED Date 16/05/25 
1. Copyright Reserved		Progress				01		16/05/25		ED		
2. Work to figured dimensions only. Do not scale drawing.		Planning Application		■								
3. The contractor is responsible for checking all levels and dimensions on site and shall refer all discrepancies to the Architect		Fire Cert										
4. Where appropriate, for details of r.c. structure, or mechanical and electrical details, see Engineers drawings		Disability Cert										
5. Proprietary items shall be fixed in strict accordance with manufacturers instructions.		Tender										
6. Sizes of proprietary items shall be checked with manufacturer.		Construction										
7. The contractor shall be responsible for the coordination of structure, finishes and services.		As Built										
8. The contractor shall be responsible for the coordination of structure, finishes and services.		Information Only										
M:\Project Section - Current\6191 Arklow Housing\CAD\Drawings\Planning 2025\local Centre\6191-PP-402 - LC 1FP.dwg												