

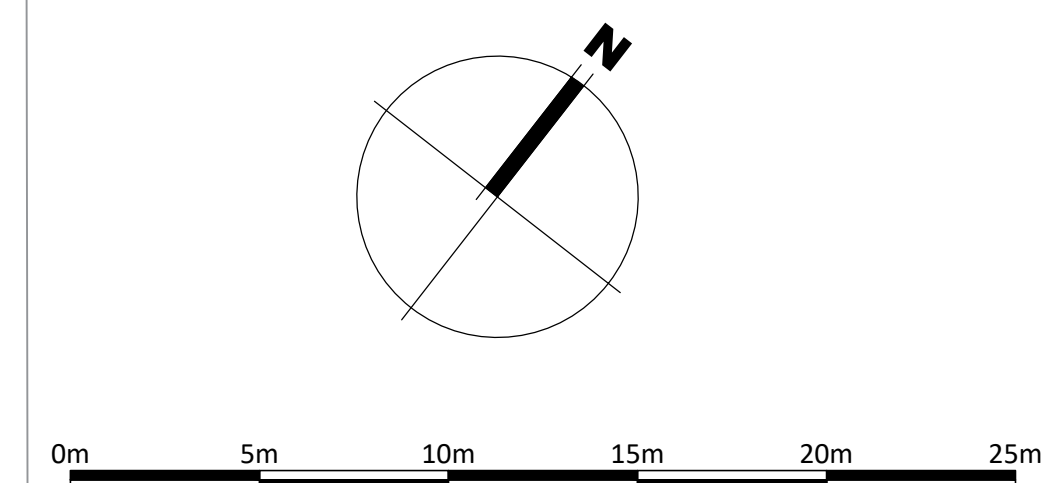
 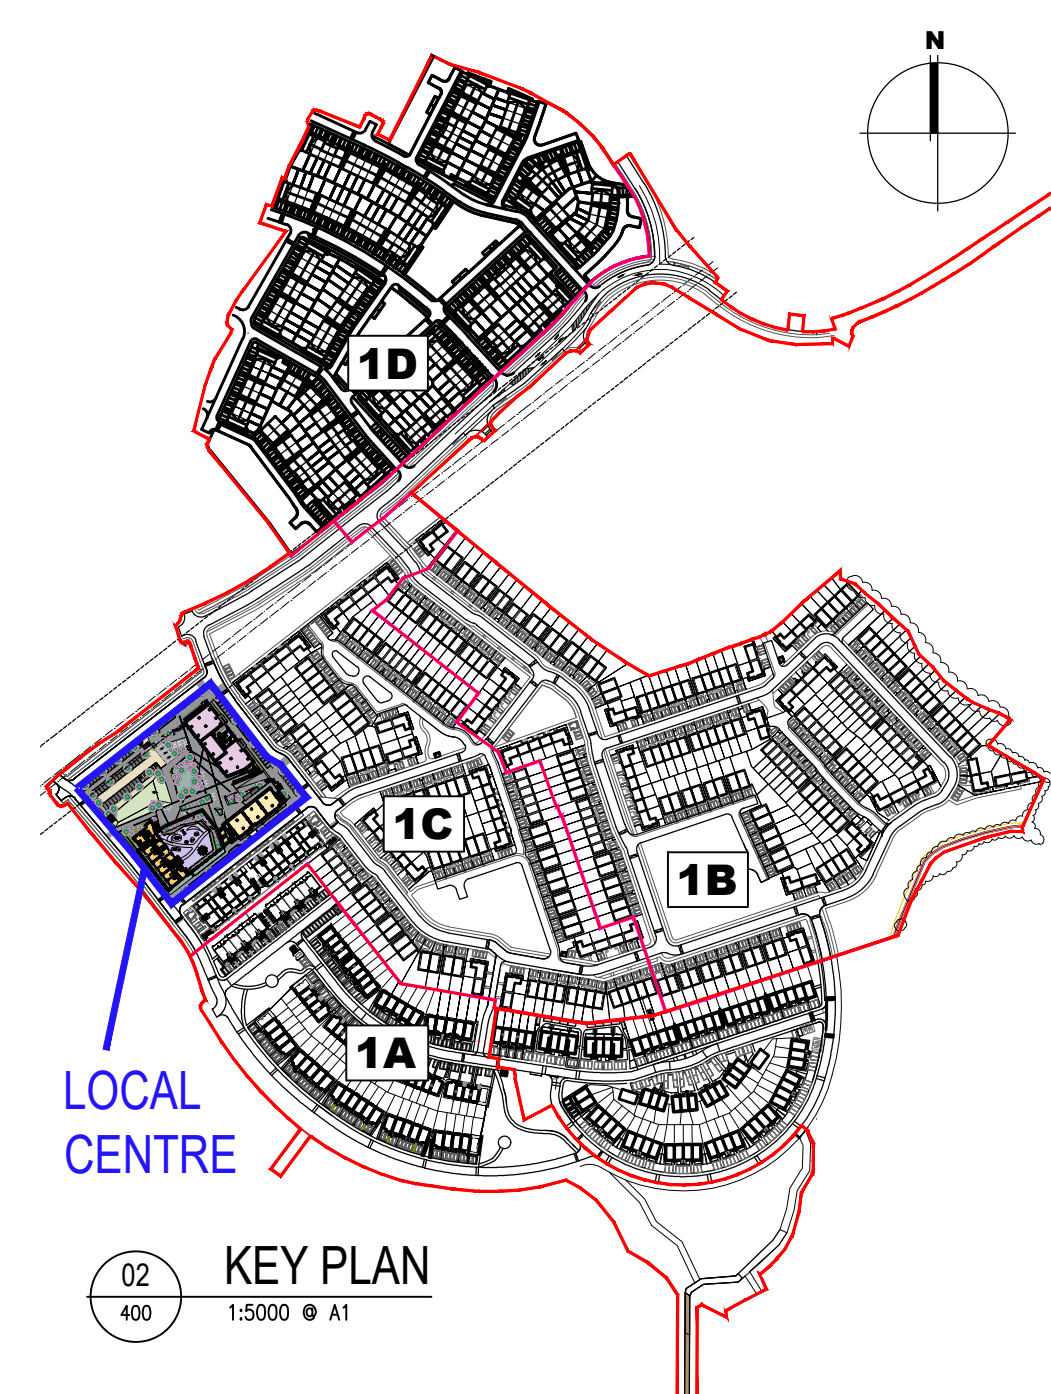


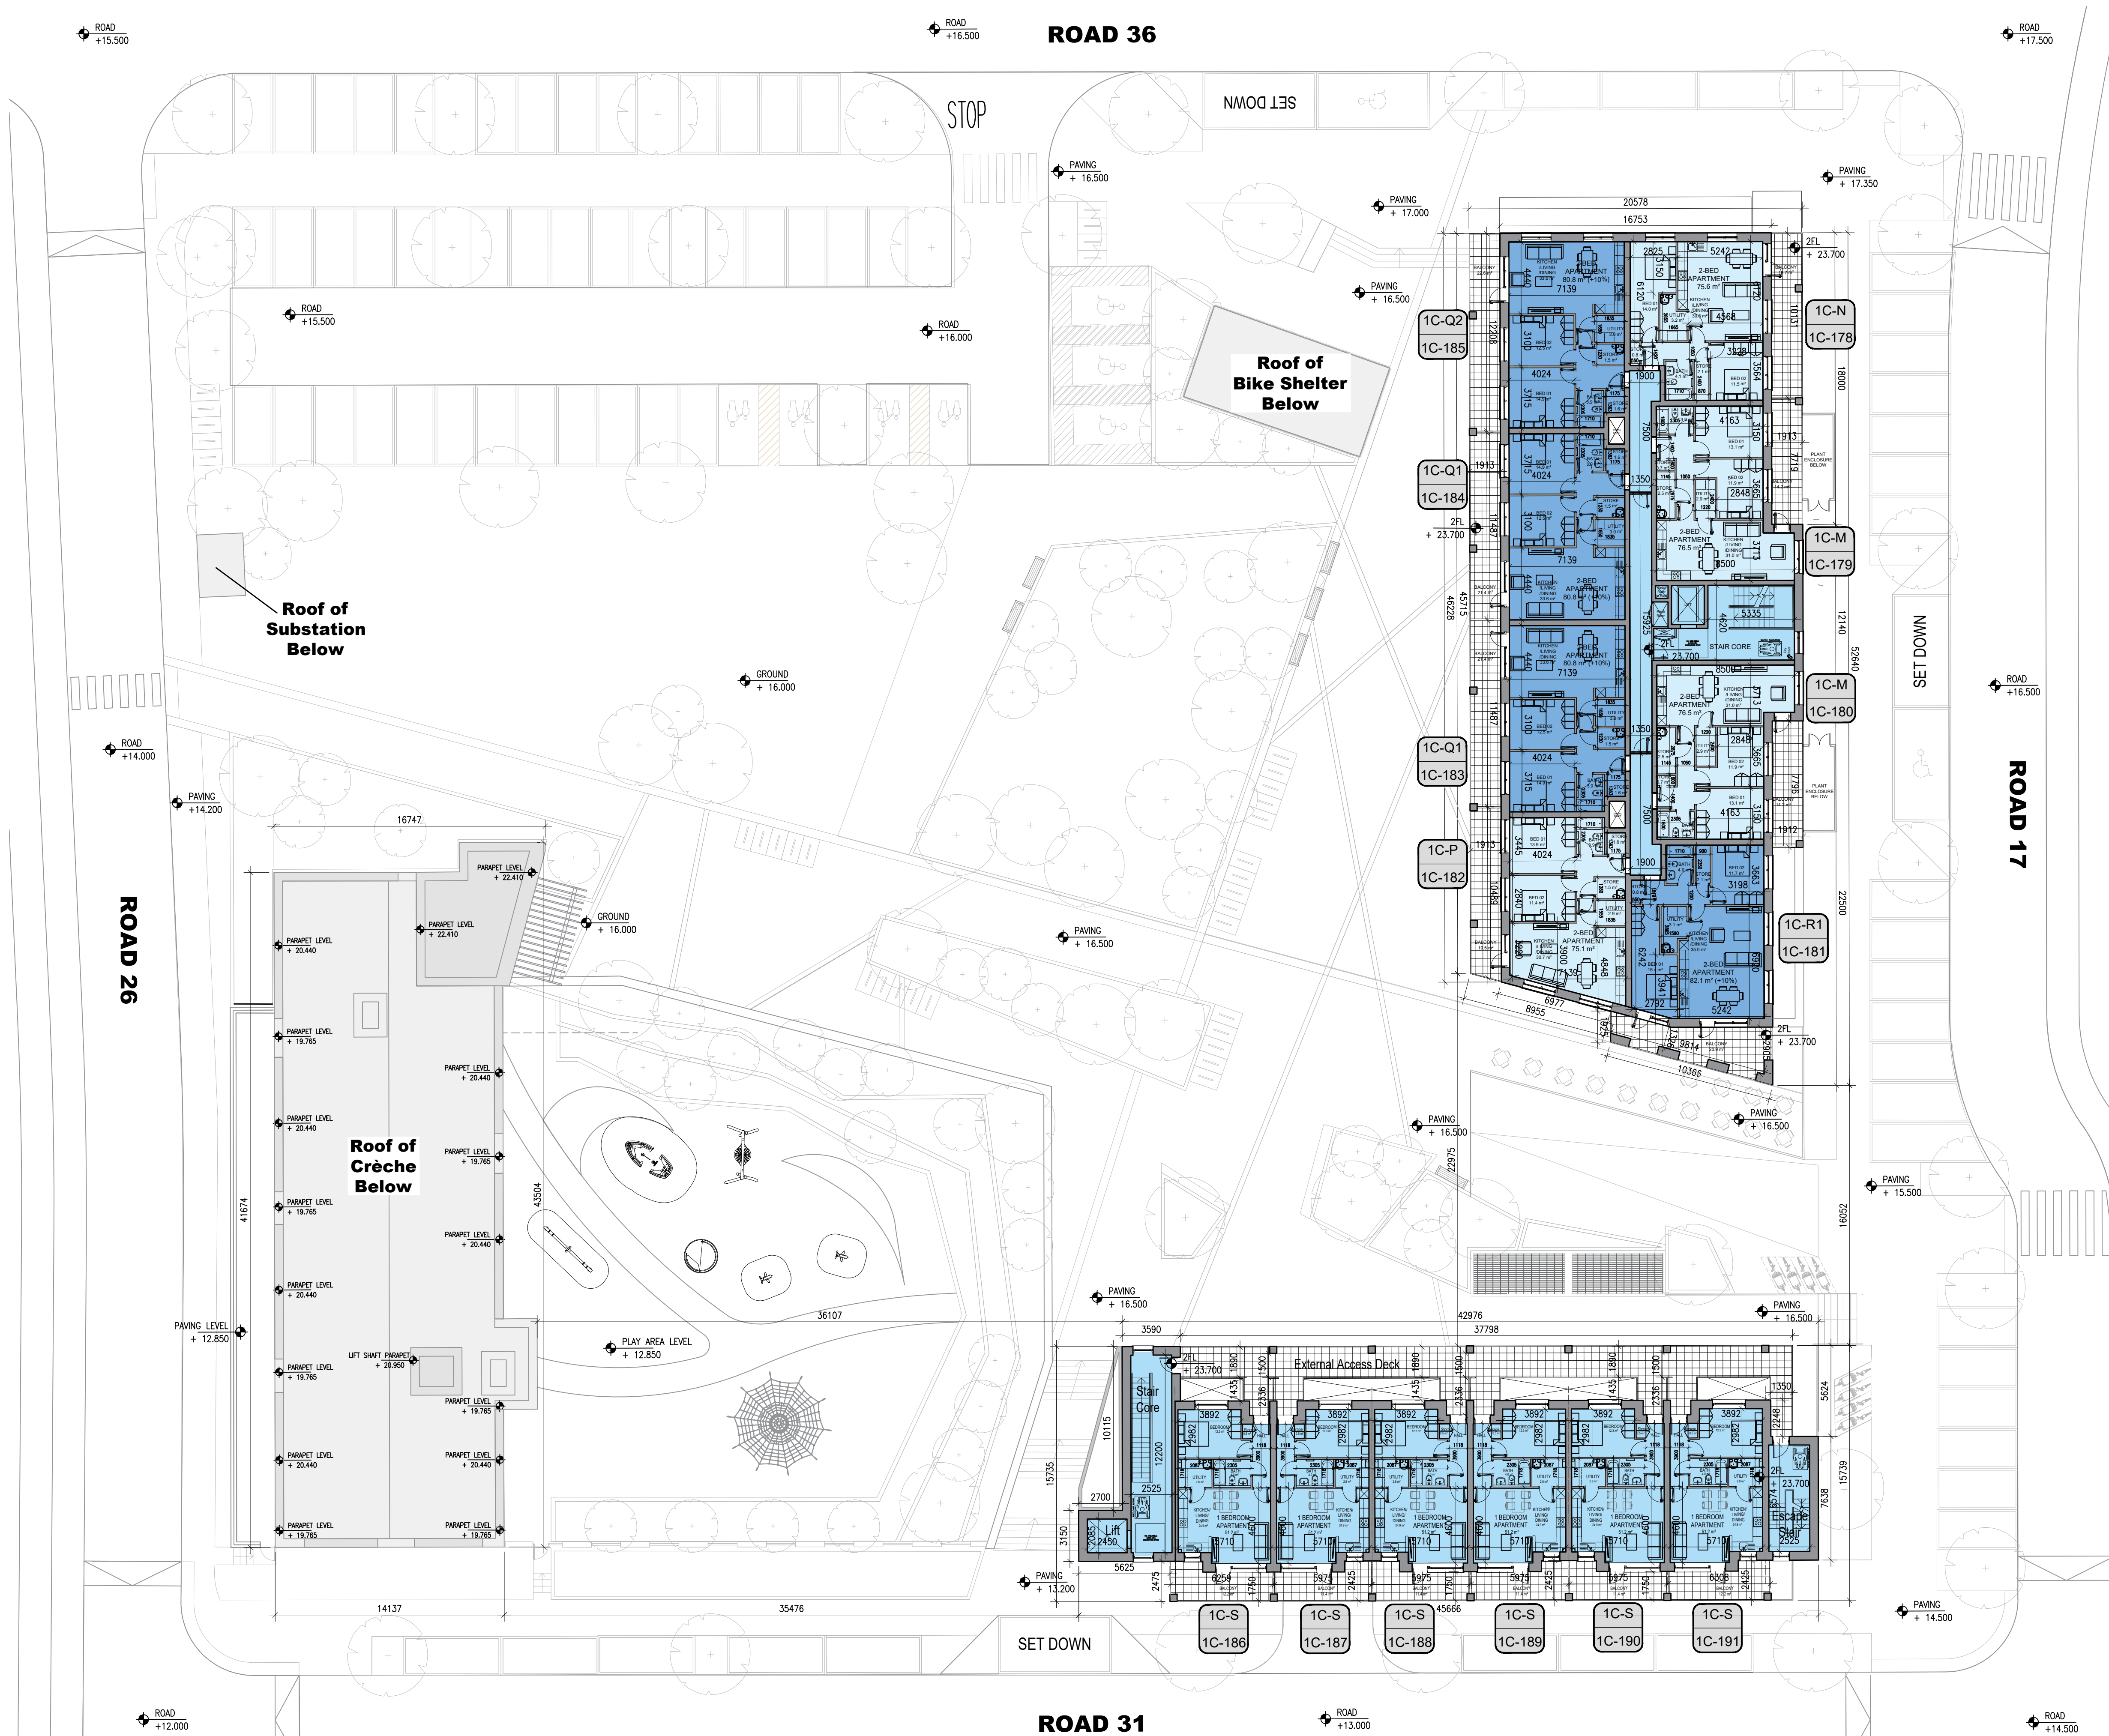

01 LOCAL CENTRE - SECOND FLOOR PLAN

Notes	Issue Status					No.	Date	Revision		Initials
1. Copyright Reserved	Progress					01	16/05/25	Planning Issue		ED
2. Work to figured dimensions only. Do not scale drawing.	Planning Application									
3. The contractor is responsible for checking all levels and dimensions on site and shall refer all discrepancies to the Architect	Fire Cert									
4. Where appropriate, for details of r.c. structure, or mechanical and electrical details, see Engineers drawings	Disability Cert									
5. Proprietary items shall be fixed in strict accordance with manufacturers instructions.	Tender									
6. Sizes of proprietary items shall be checked with manufacturer.	Construction									
7. The contractor shall be responsible for the coordination of structure, finishes and services.	As Built									
	Information Only									

Project		Mixed Use Residential & Commercial Development at Kilbride, Arklow, Co. Wicklow		6 - 7 HARDCURT TERRACE, DUBLIN 2, IRELAND T +353 -1 419 7942 F +353 -1 419 7955 e architects@bkd.ie www.bkd.ie	
Drawing Title		LOCAL CENTRE - SECOND FLOOR PLAN			
Drawing No		6191-PP-403			
Scale		1:200@A1	Rev	01	Drawn ED
		Date	16/05/25		



bkdarchitects
BURKE-KENNEDY DOYLE