

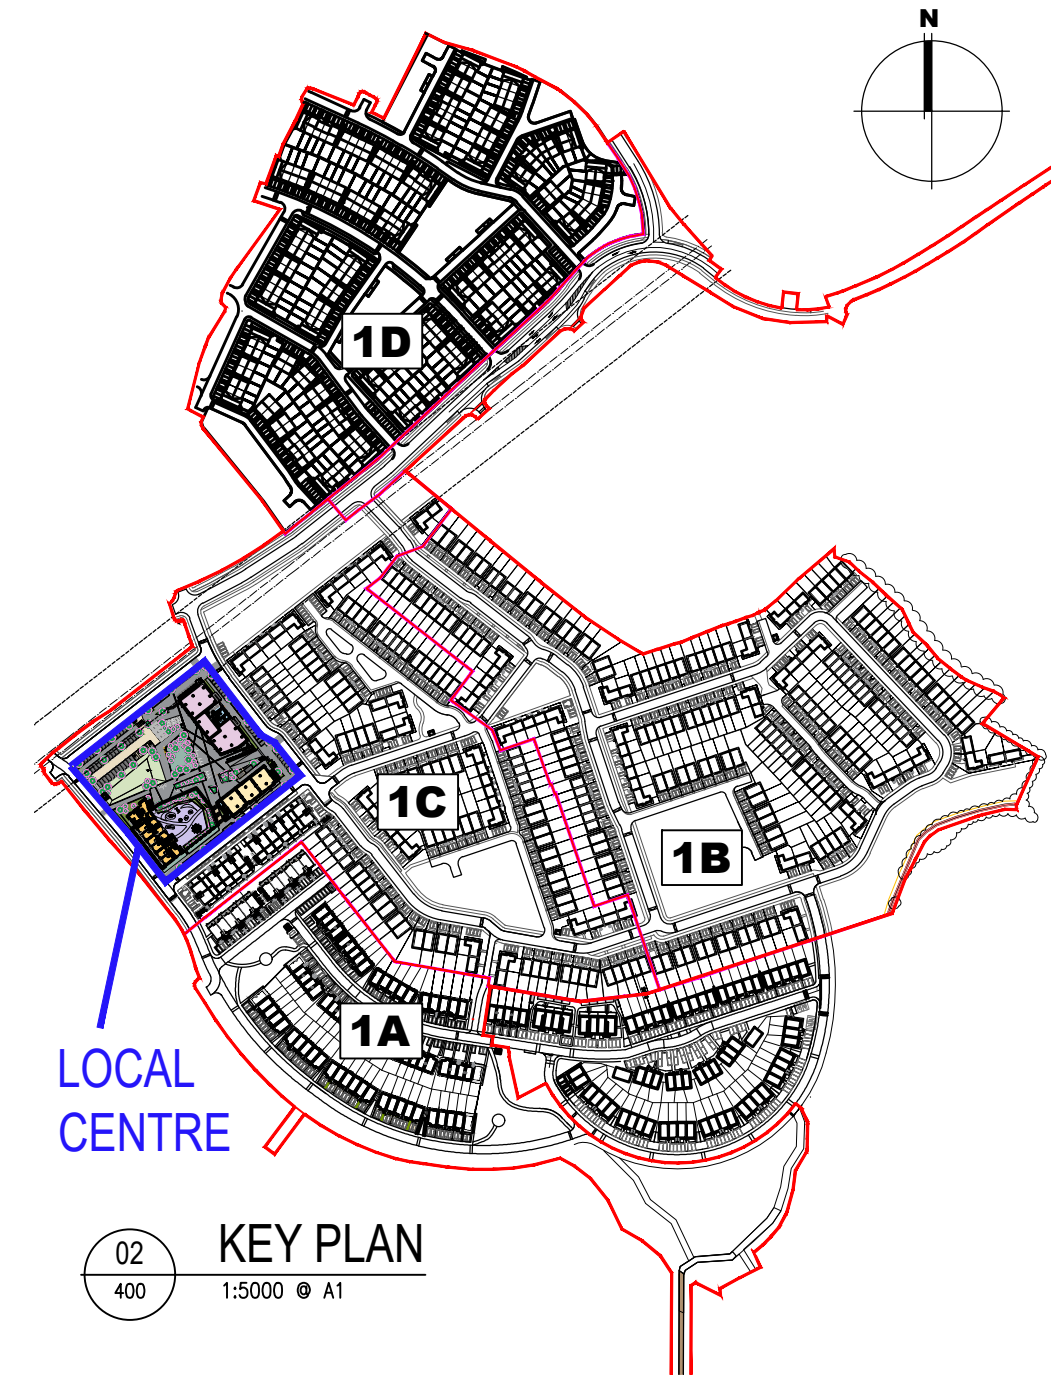


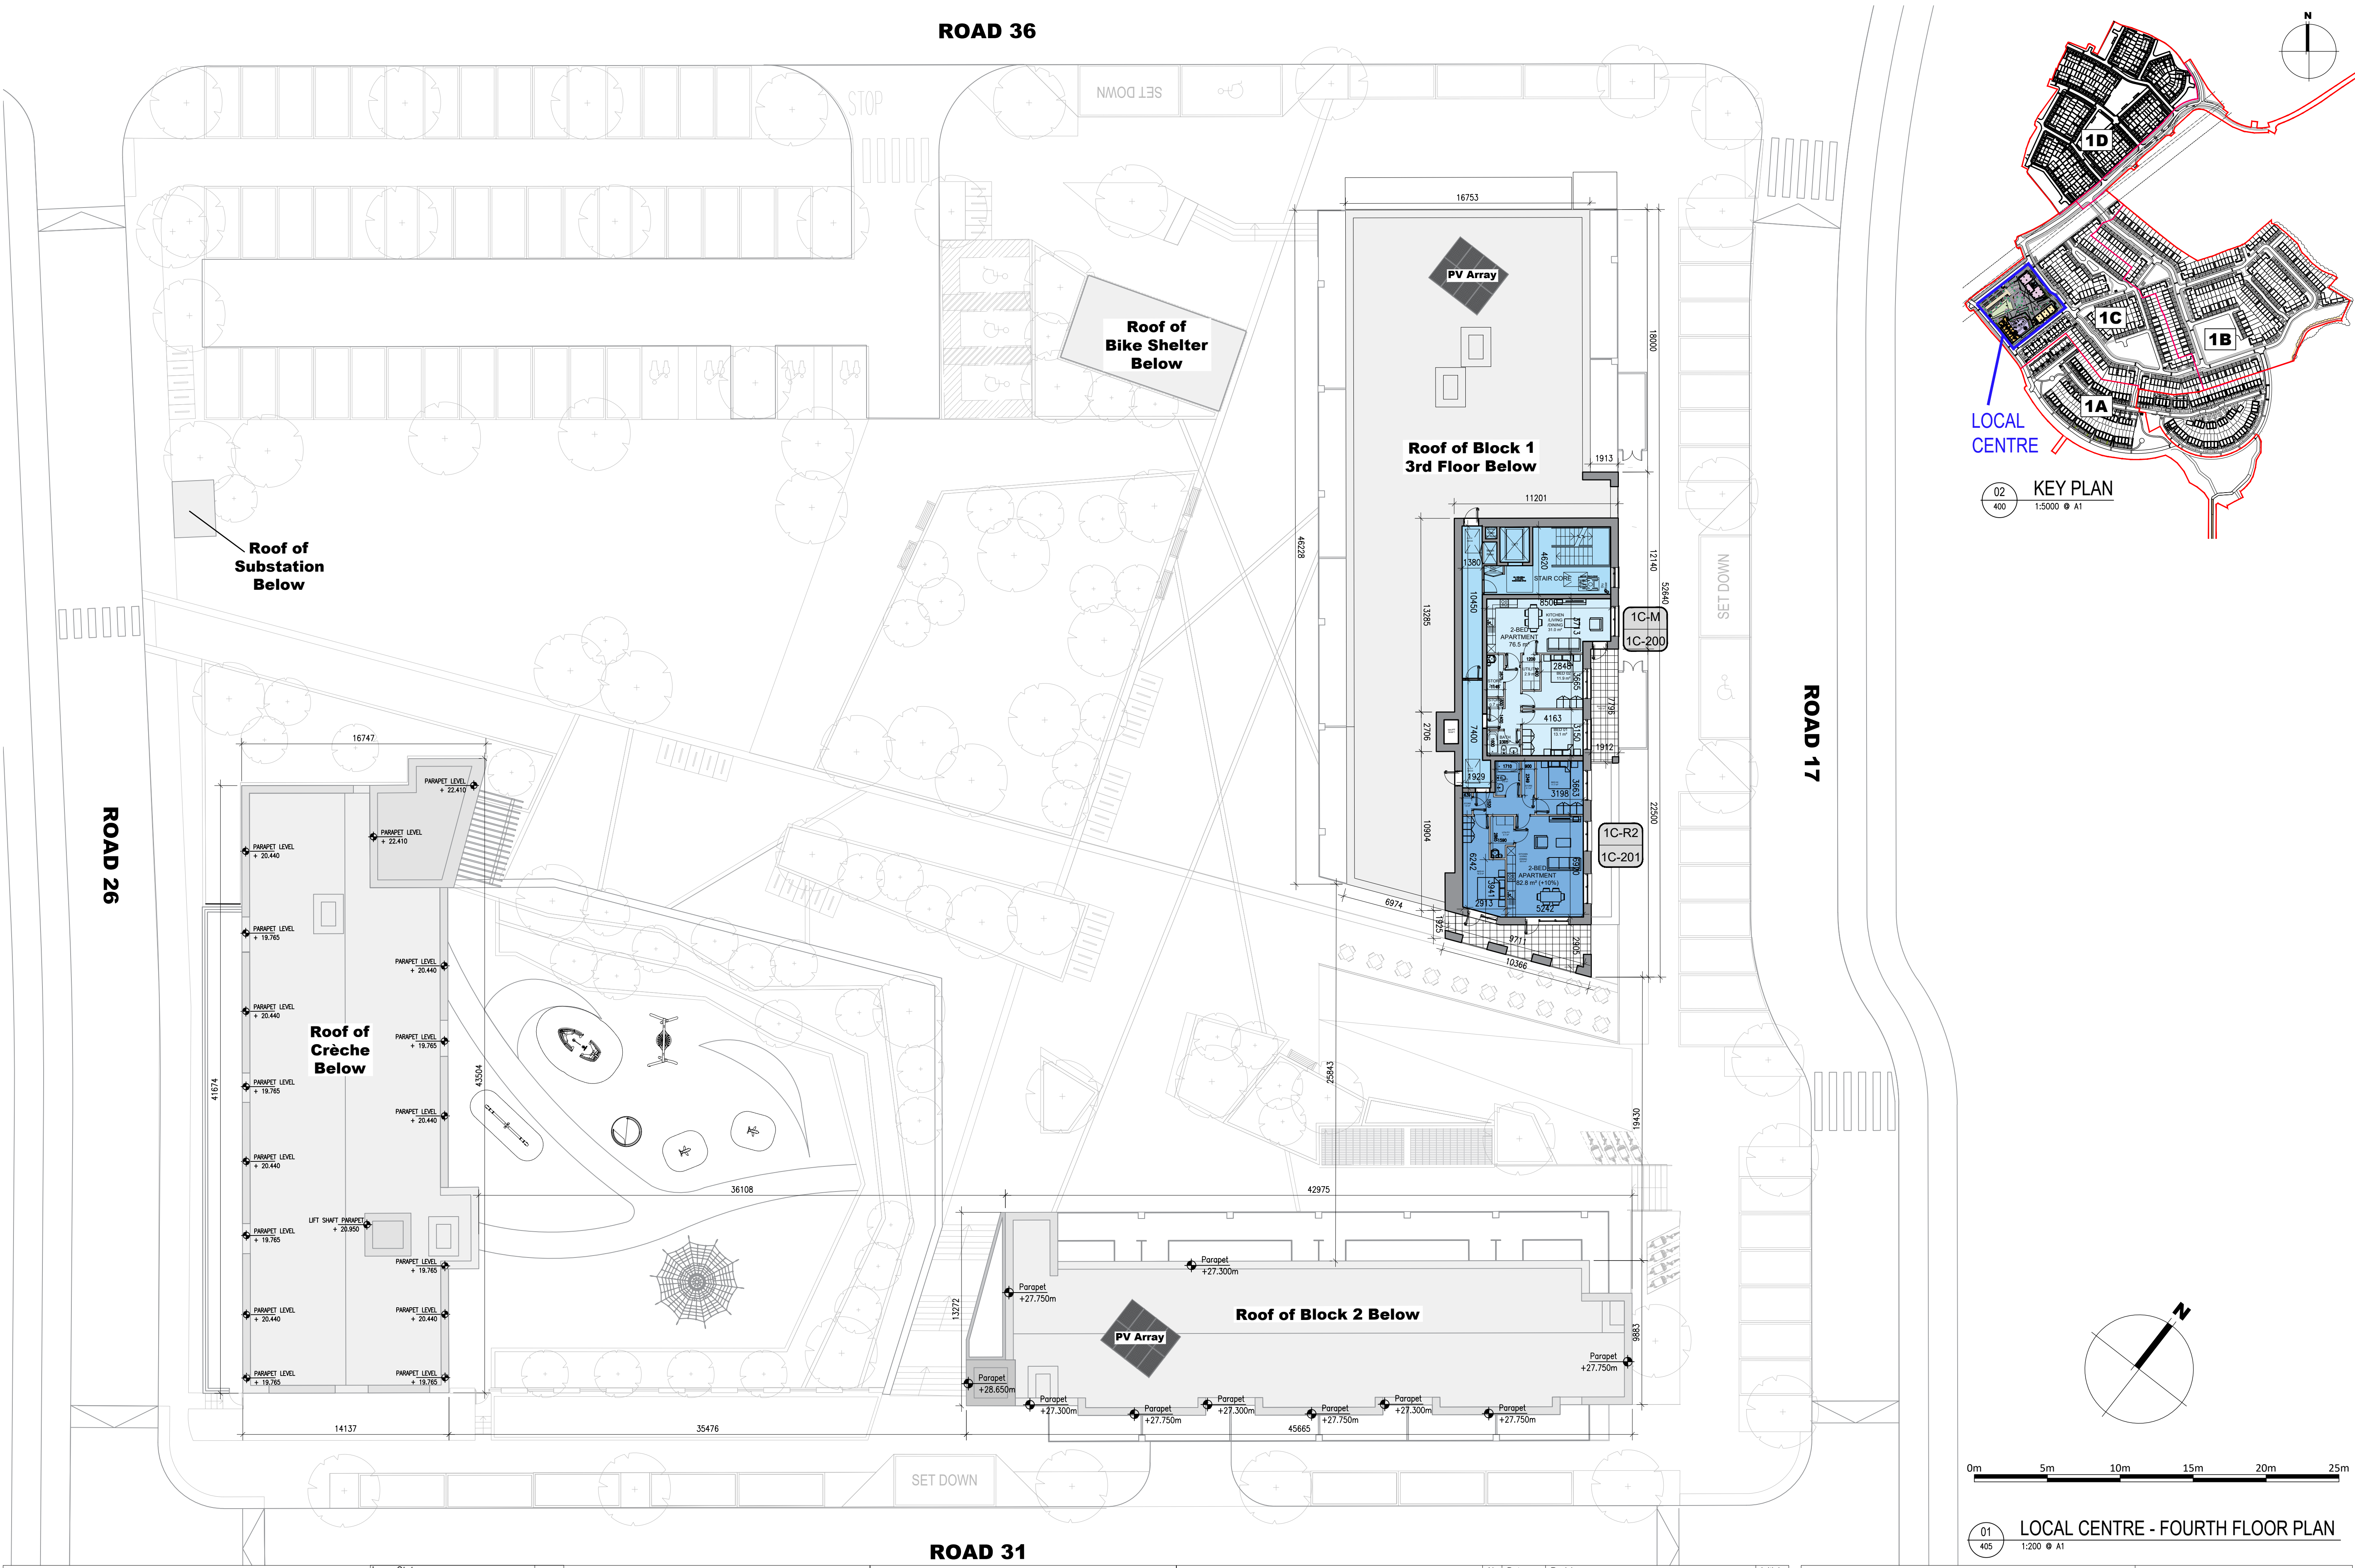

02
400
KEY PLAN
1:5000 @ A1

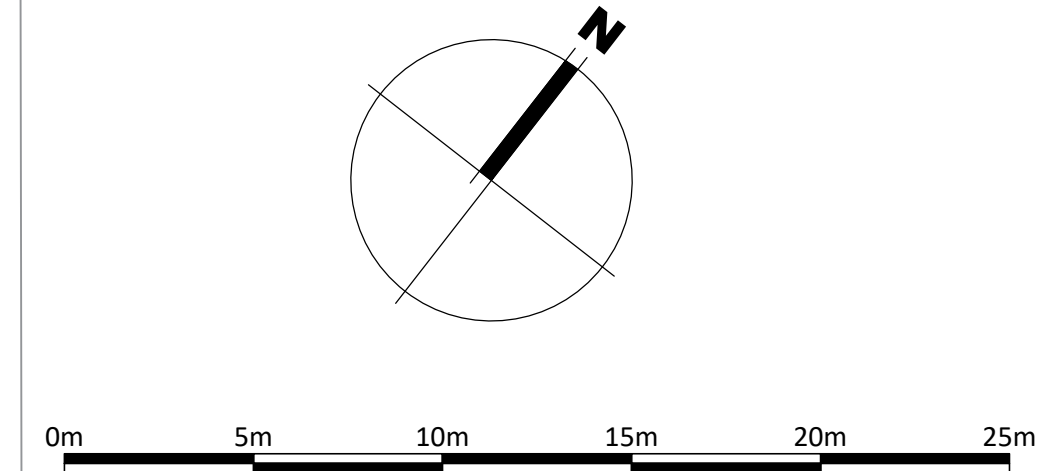

01
405
LOCAL CENTRE - FOURTH FLOOR PLAN
1:200 @ A1

Notes		Issue Status		No.		Date		Revision		Initials	
1. Copyright Reserved		Progress		01		16/05/25		Planning Issue		ED	
2. Work to figure dimensions only. Do not scale drawing		Planning Application									
3. The contractor is responsible for checking all levels and dimensions on site and shall refer all discrepancies to the Architect		Fire Cert									
4. Where appropriate, for details of r.c. structure, or mechanical and electrical details, see Engineers drawings		Disability Cert									
5. Proprietary items shall be fixed in strict accordance with manufacturers instructions.		Tender									
6. Sizes of proprietary items shall be checked with manufacturer.		Construction									
7. The contractor shall be responsible for the coordination of structure, finishes and services.		As Built									
		Information Only									

Project		Mixed Use Residential & Commercial Development at Kilbride, Arklow, Co. Wicklow		6-7 HARDICUT TERRACE, DUBLIN 2, IRELAND t +353 1 618 2400 f +353 1 676 7396 a architecture@bkd.ie www.bkd.ie
Drawing Title		LOCAL CENTRE - FOURTH FLOOR PLAN		bkd architects BURKE-KENNEDY DOYLE
Drawing No		6191-PP-405		
Scale		1:200@A1		
Rev		01		
Drawn		ED		
Date		16/05/25		