

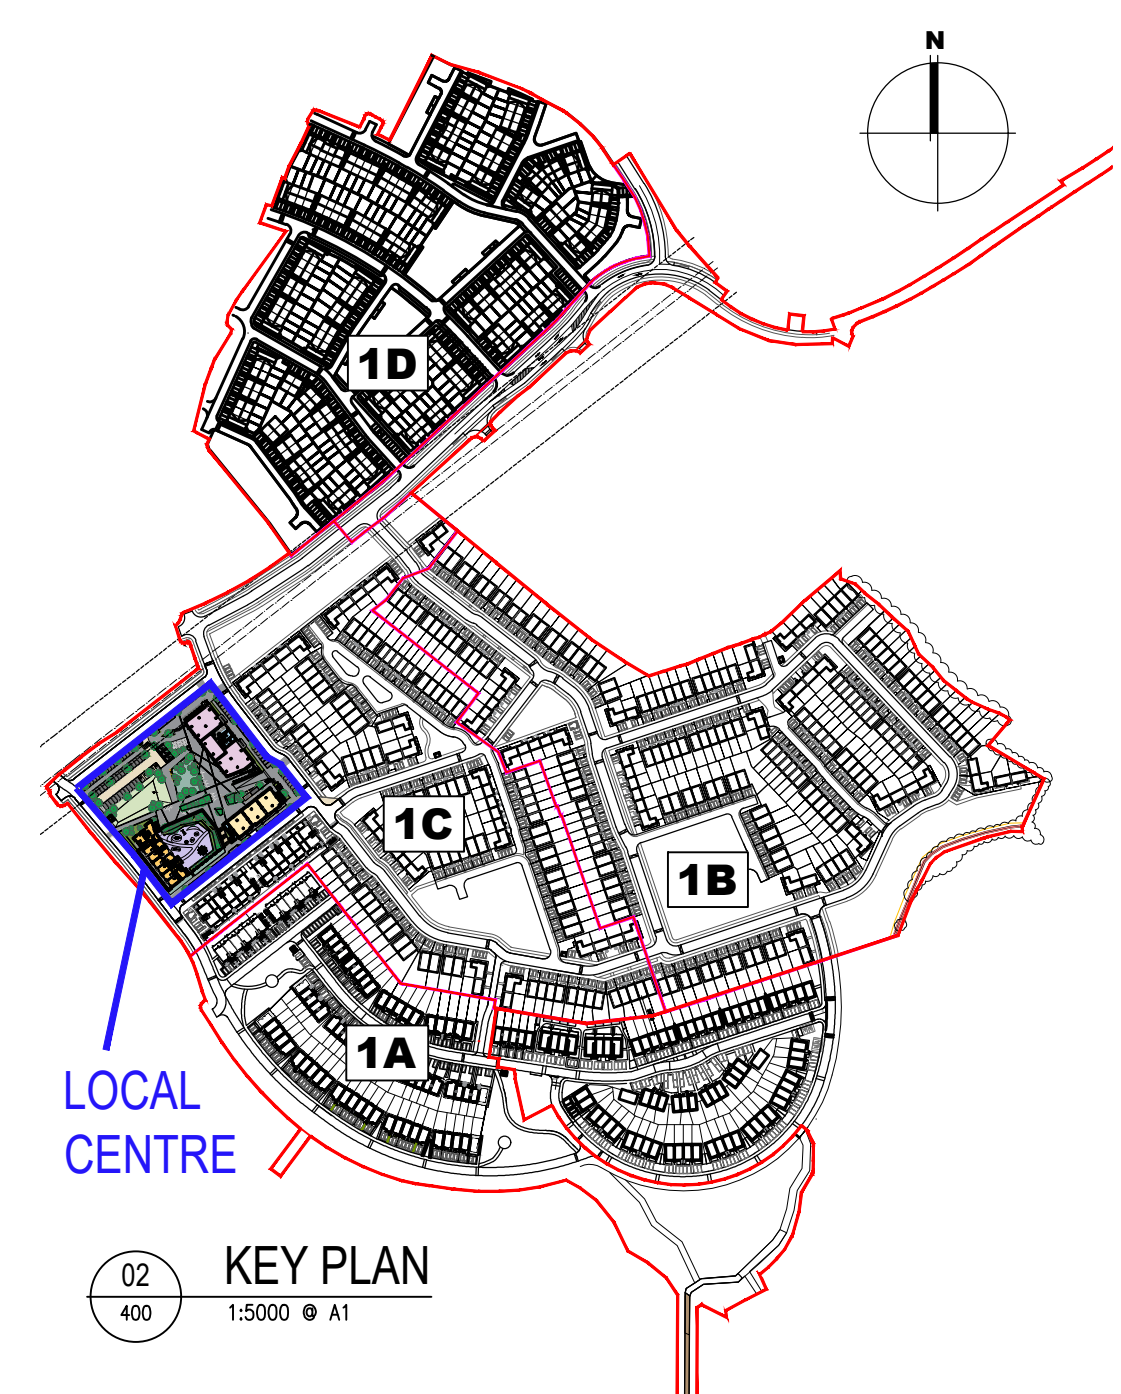


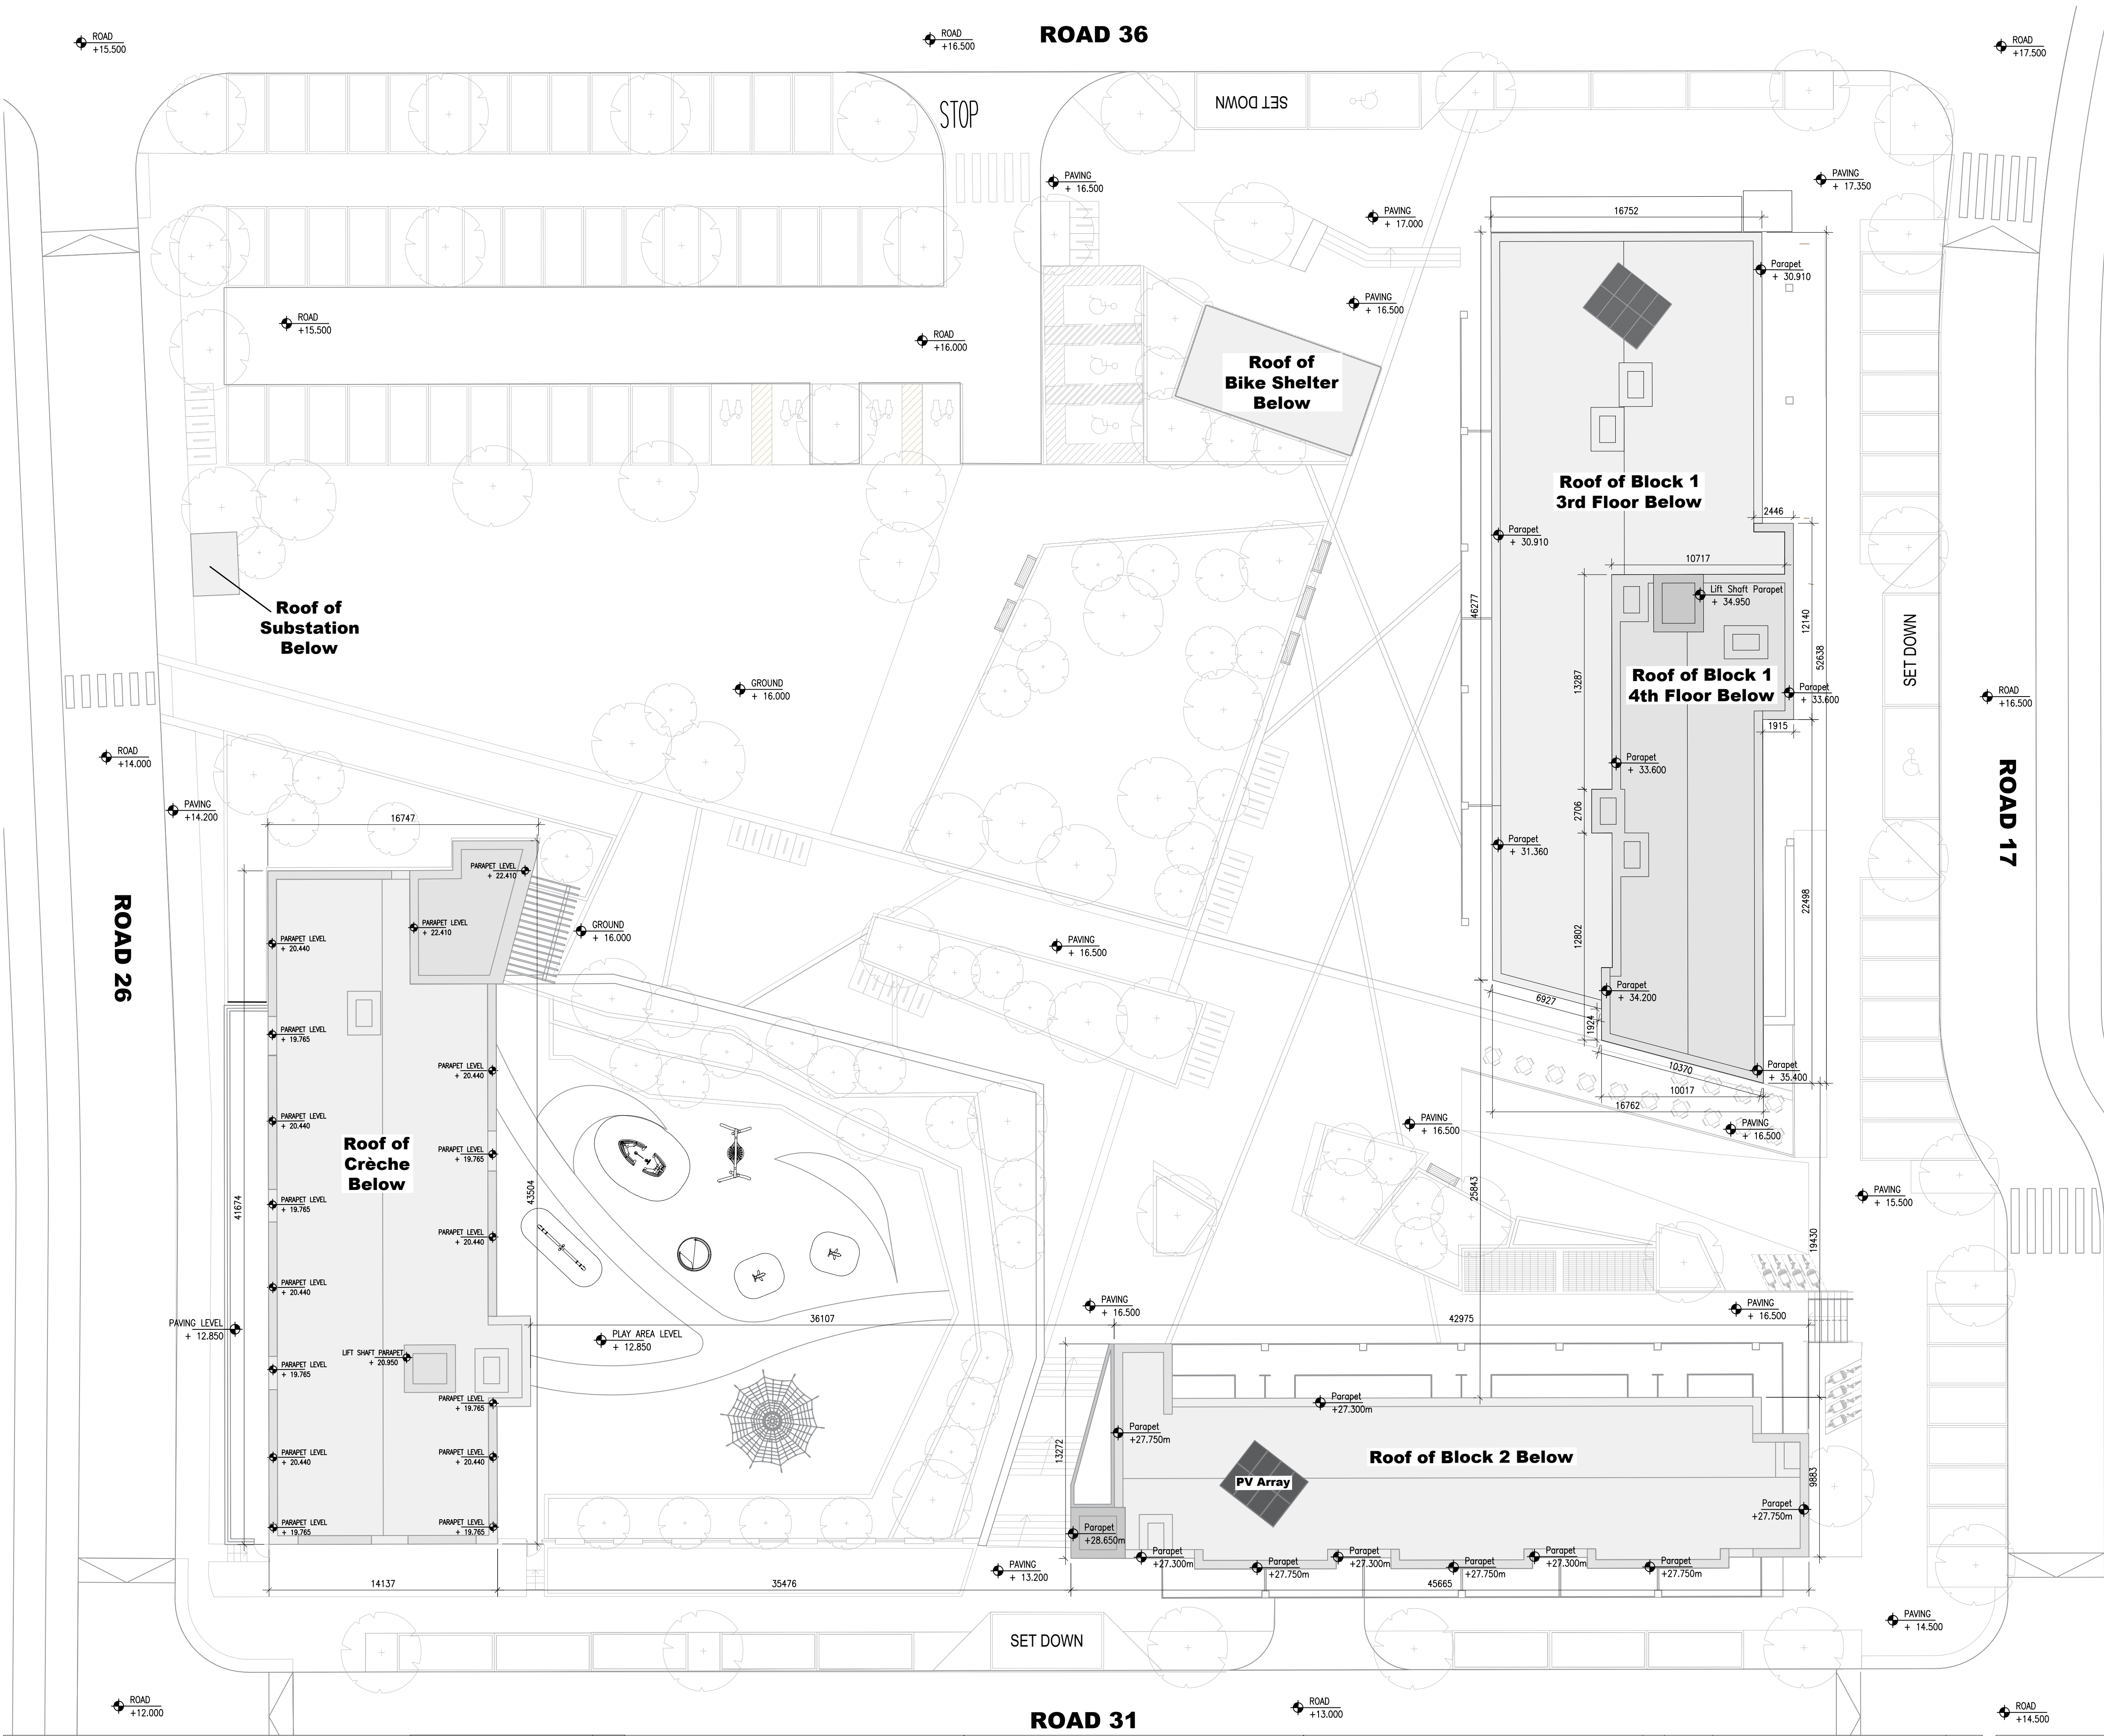

02
400
KEY PLAN
1:5000 @ A1

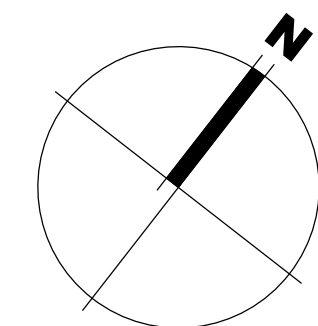

01
406
LOCAL CENTRE - ROOF PLAN
1:200 @ A1

Notes		Issue Status		No.		Date		Revision		Initials	
1. Copyright Reserved		Progress		01		16/05/25		Planning Issue		ED	
2. Work to figure dimensions only. Do not scale drawing.		Planning Application									
3. The contractor is responsible for checking all levels and dimensions on site and shall refer all discrepancies to the Architect.		Fire Cert									
4. Where appropriate, for details of r.c. structure, or mechanical and electrical details, see Engineers drawings.		Disability Cert									
5. Proprietary items shall be fixed in strict accordance with manufacturers instructions.		Tender									
6. Sizes of proprietary items shall be checked with manufacturer.		Construction									
7. The contractor shall be responsible for the coordination of structure, finishes and services.		As Built									
		Information Only									

M:\Project Section - Current\6191 Arklow Housing\CAD\Drawings\Planning 2025\Local Centre\6191-PP-406 - LC Roof Plan.dwg 20/05/2025 10:58:20

Project				6-7 HARDCOURT TERRACE, DUBLIN 2, IRELAND t +353-1-618 2400 f +353-1-676 7396 a architecture@bkd.ie www.bkd.ie			
Mixed Use Residential & Commercial Development at Kilbride, Arklow, Co. Wicklow							
Drawing Title				LOCAL CENTRE - ROOF PLAN			
Drawing No				6191-PP-406			
Scale	1:200@A1	Rev	01	Drawn	ED	Date	16/05/25



bkdarchitects
BURKE-KENNEDY DOYLE