




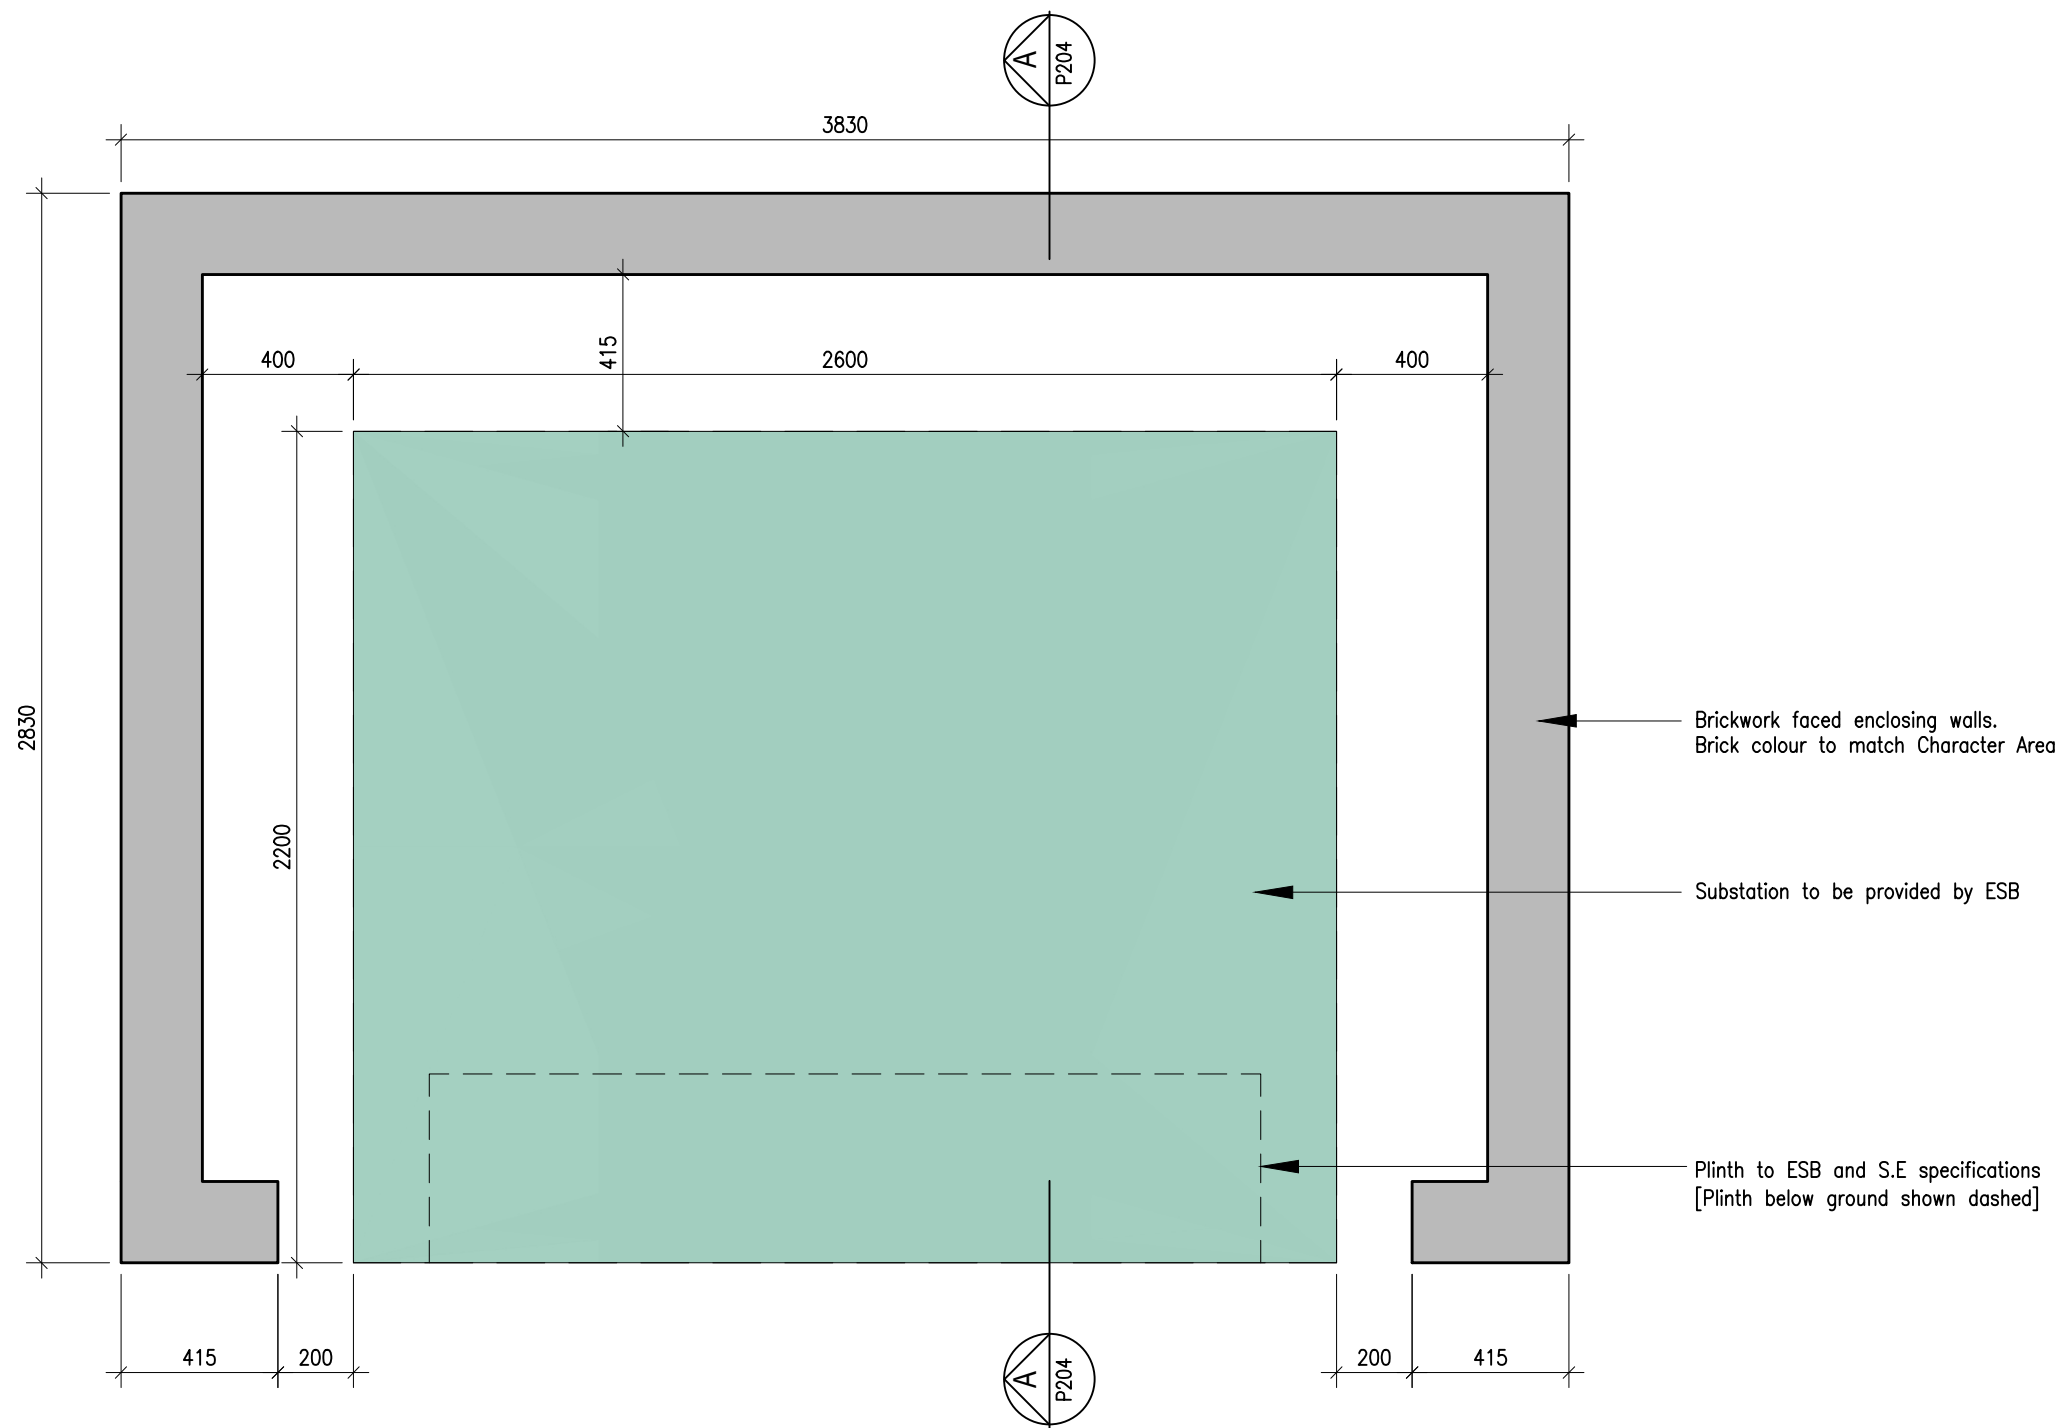


01 Substation Plan
PP-520 1:20 @A1

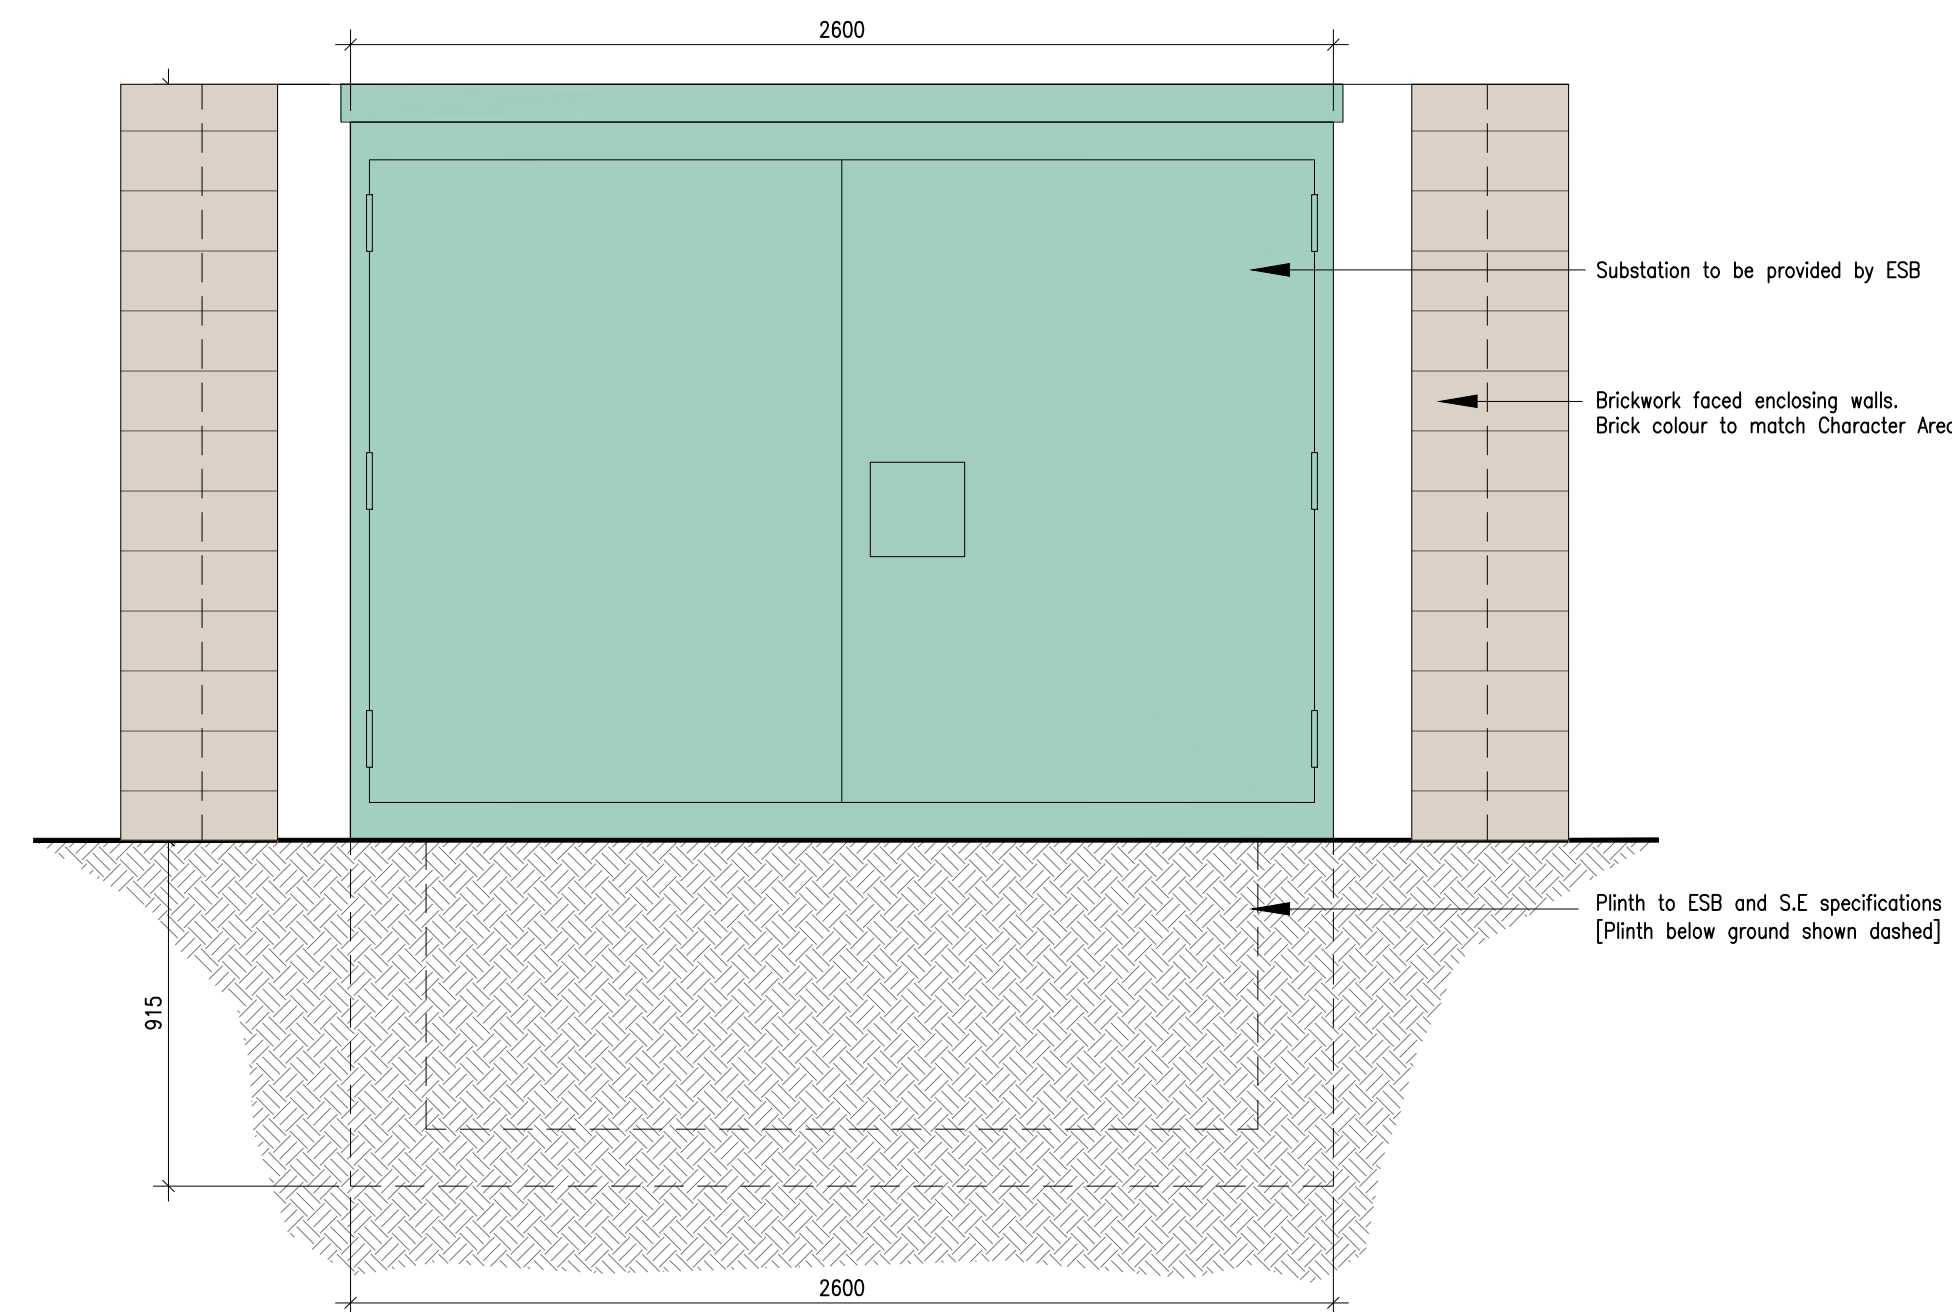

02 Front Elevation
PP-520 1:20 @A1

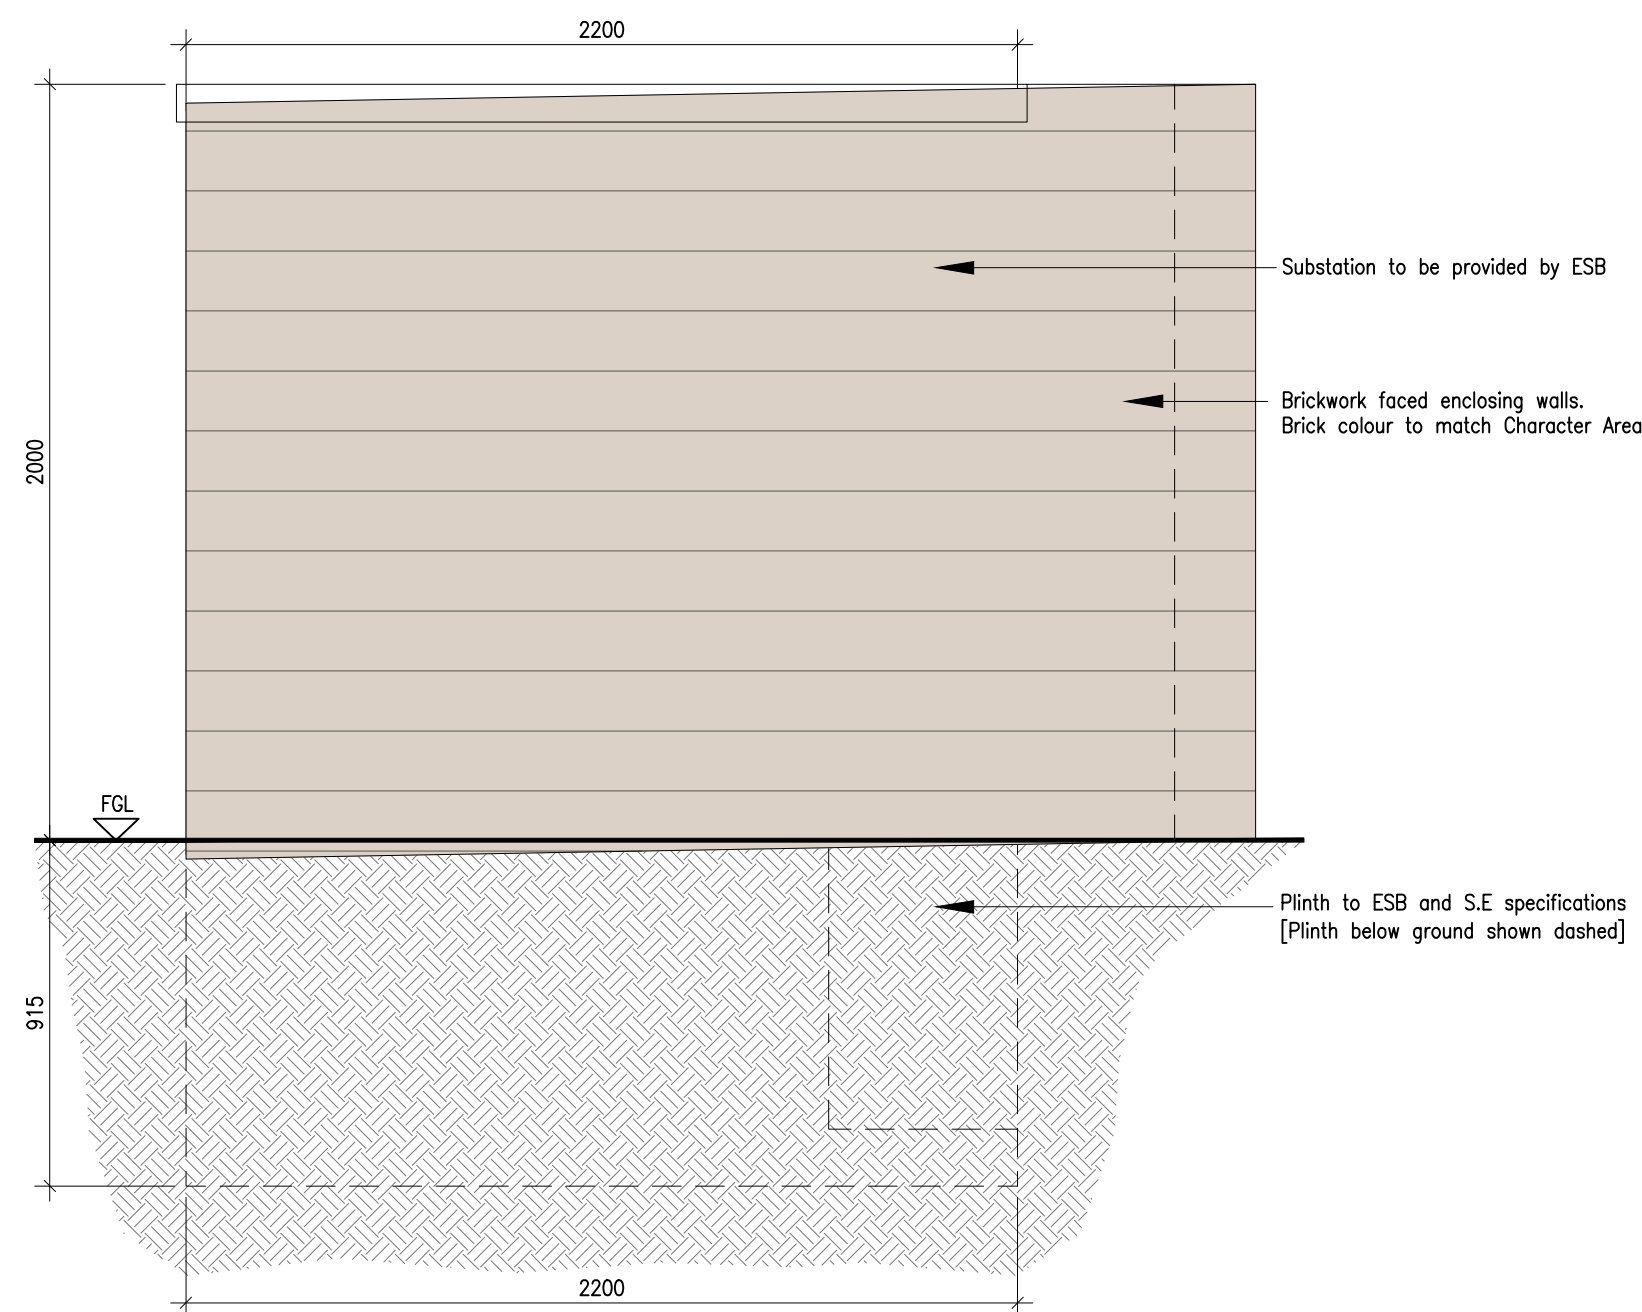



03 Side Elevation
PP-520 1:20 @A1

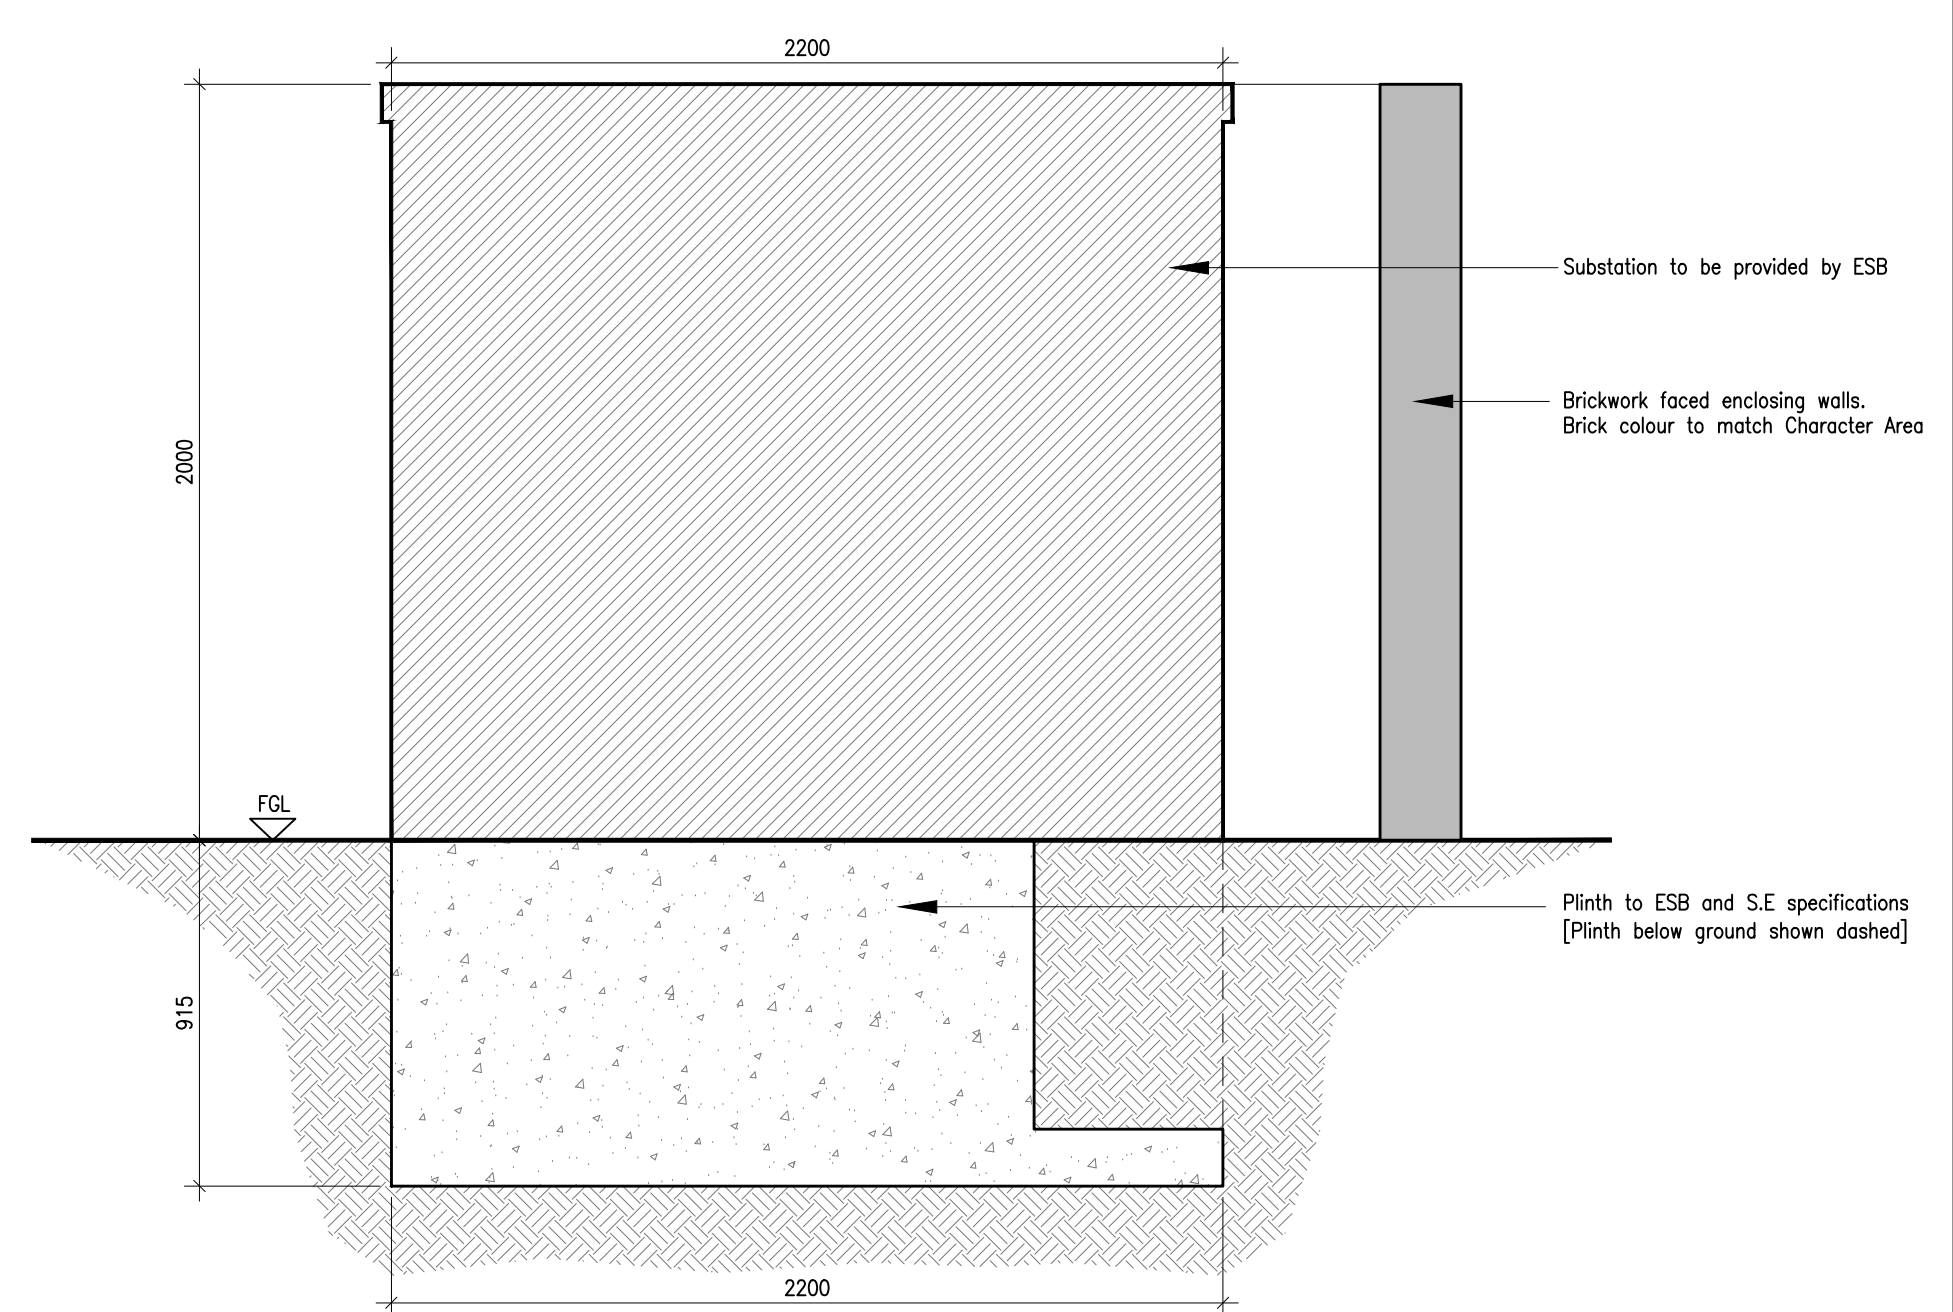

04 Section AA
PP-520 1:20 @A1

Location of ESB Substations

05 Key Plan
PP-520 NTS @A1

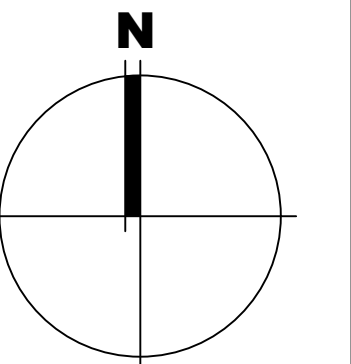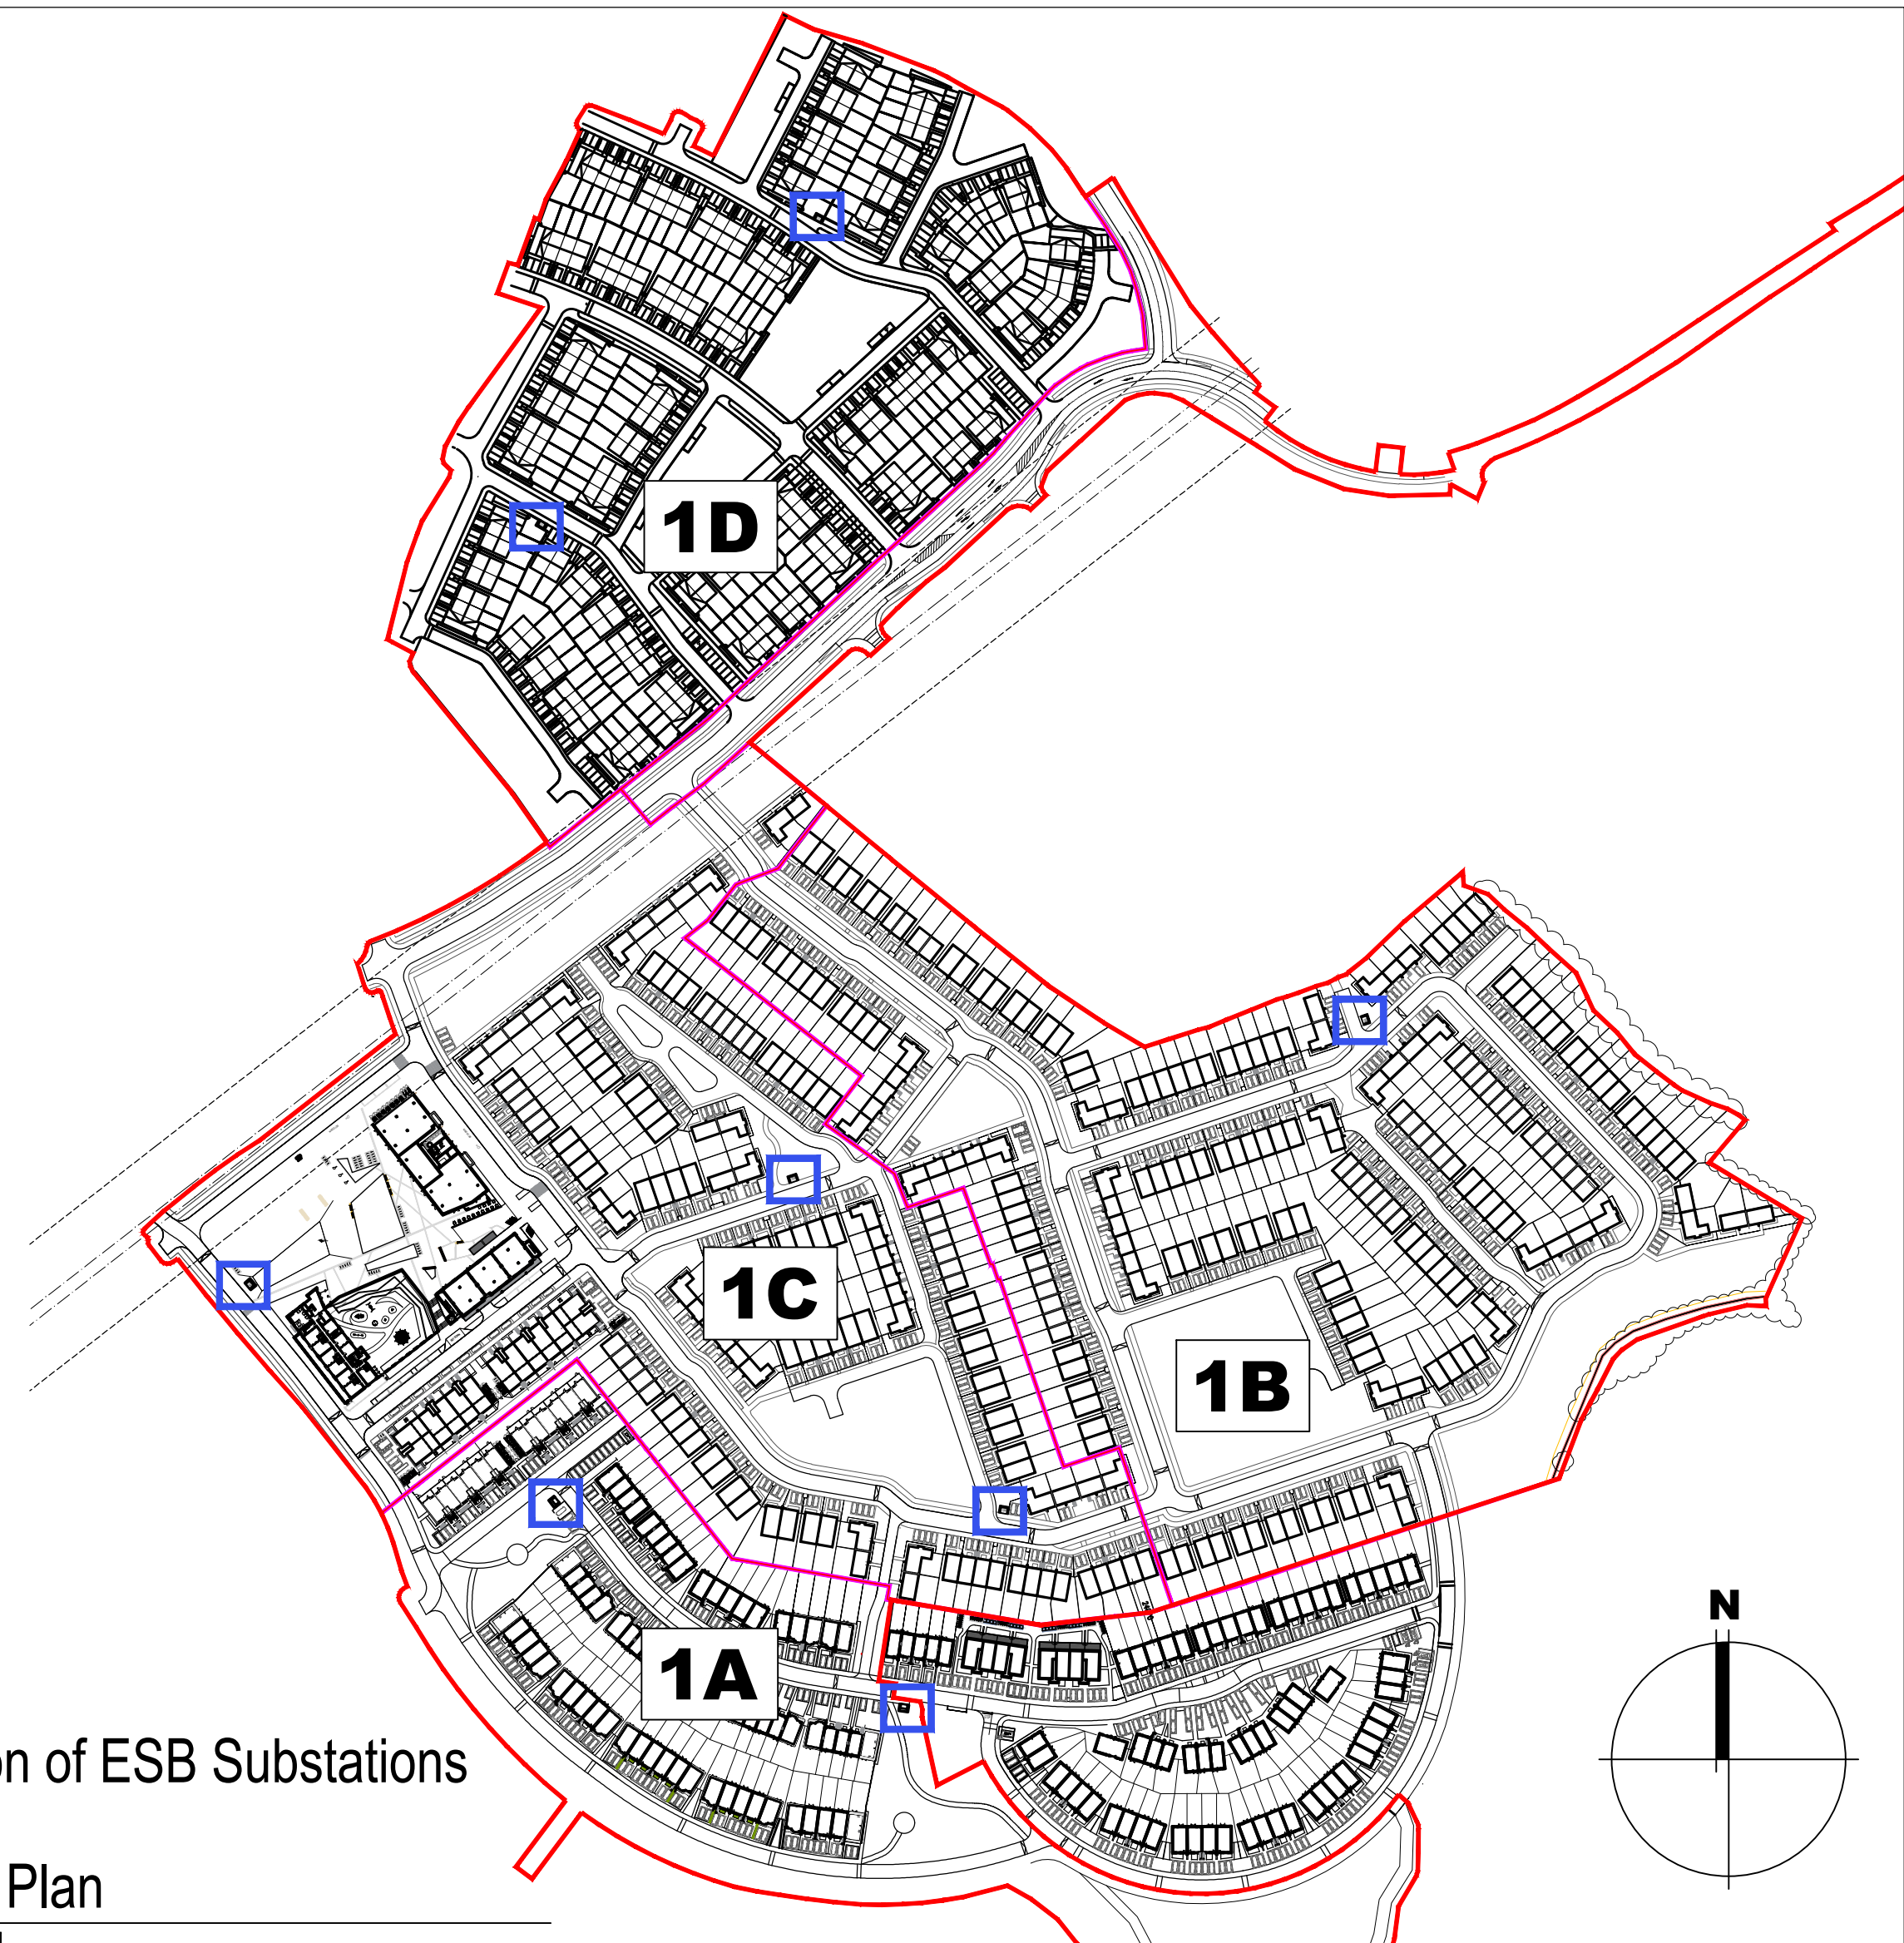

Notes		Issue Status		No.		Date	Revision	Initials	
1. Copyright Reserved		Progress							
2. Work to figure dimensions only. Do not scale drawing.		Planning Application							
3. The contractor is responsible for checking all levels and dimensions on site and shall refer all discrepancies to the Architect		Fire Cert							
4. Where appropriate, for details of r.c. structure, or mechanical and electrical details, see Engineers drawings		Disability Cert							
5. Proprietary items shall be fixed in strict accordance with manufacturers instructions.		Tender							
6. Sizes of proprietary items shall be checked with manufacturer.		Construction							
7. The contractor shall be responsible for the coordination of structure, finishes and services.		As Built							
		Information Only							
M:\Project Section - Current\6191 Arklow Housing\CAD\Drawings\Planning 2025\Details\6191-PP-520 - ESB Substation Details.dwg 20/05/2025 17:55:46									

Project	Portmarnock South Phase 1E Portmarnock Real Estate Developments			6-7 HARDOULT TERRACE, DUBLIN 2, IRELAND t +353-1-618 2400 f +353-1-676 7395 e info@bkd.ie www.bkd.ie	
Drawing Title	Phase 1 - ESB Substation Details				
Drawing No	6191-PP-520				
Scale	1:20@A1	Rev	01	Drawn	RT; ED
				Date	13/05/25

bkdarchitects

BURKE-KENNEDY DOYLE